



ARCHITECTURAL
WARD99 ARCHITECTS INC.

STRUCTURAL
VX ENGINEERING INC.



MECHANICAL
DEI Consulting Engineers Inc.

ELECTRICAL
DEI Consulting Engineers Inc.

E1.1	LEGEND AND SCHEDULES
E1.2	ELECTRICAL DETAILS
E2.1	PARTIAL GROUND FLOOR DEMOLITION AND RENOVATION PLANS AND NOTES

IT IS THE CONTRACTOR'S RESPONSIBILITY TO ENSURE THAT ALL CONSTRUCTION CONFORMS TO THE REQUIREMENTS OF THE ONTARIO BUILDING CODE. NOTATIONS MADE ON THESE DRAWINGS ARE FOR YOUR INFORMATION AND ASSISTANCE ONLY AND DO NOT NECESSARILY COMMENT ON ALL AREAS OF CONSTRUCTION.

THE ONTARIO BUILDING CODE REQUIRES THAT A COPY OF THE DRAWINGS AND SPECIFICATIONS THAT HAVE BEEN REVIEWED BY OUR DEPARTMENT BE KEPT AT THE CONSTRUCTION SITE AT ALL TIMES.

PORTABLE FIRE EXTINGUISHERS TO BE INSTALLED IN CONFORMANCE WITH O.F.C. 6.2. SEE ATTACHED HANDOUT AND REVIEW PLACEMENT WITH BUILDING INSPECTOR ON SITE.

**FIRE ALARM SYSTEM TO BE DESIGNED, INSTALLED
AND TESTED AS PER CAN/ULC-S524, CAN/ULC
S537 AND APPLICABLE O.B.C. REQUIREMENTS**

EXISTING. RE-VERIFICATION REQUIRED.

WHERE FIRE PROTECTION AND LIFE SAFETY SYSTEMS, AND SYSTEMS WITH FIRE PROTECTION AND LIFE SAFETY FUNCTIONS, ARE INTEGRATED WITH EACH OTHER, THE SYSTEMS SHALL BE TESTED AS A WHOLE IN ACCORDANCE WITH CAN/ULC-S1001, "INTEGRATED SYSTEMS TESTING OF FIRE PROTECTION AND LIFE SAFETY SYSTEMS", TO VERIFY THAT THE SYSTEMS HAVE BEEN PROPERLY INTEGRATED AND REPORT PROVIDED TO THE BUILDING INSPECTOR PRIOR TO OCCUPANCY.

- = 1 HOUR FIRE SEPARATION
- = EXISTING FIRE SEPARATION (REPAIR ANY/ALL DEFICIENCIES)
- = EXIT
- = BARRIER-FREE ENTRANCE
- = FIRE RATED DOOR WITH SELF-CLOSING AND POSITIVE LATCH

CLOSEST MAIN STREET INTERSECTION:
LAURENTIAN DR. AND CARTIER DR.

PROJECT TITLE:
TRILLIUM JUNIOR PUBLIC SCHOOL INTERIOR RENOVATIONS
WATERLOO REGION DISTRICT SCHOOL BOARD

PROJECT ADDRESS:
79 LAURENTIAN DR, KITCHENER, ON N2E 1C3

OWNER:
WATERLOO REGION DISTRICT SCHOOL BOARD

OWNER'S CONTACT INFORMATION:
51 ARDELT AVENUE, KITCHENER, ON N2C 2R5

CONSULTANT:
ward99 architects inc.

CONSULTANT'S CONTACT INFORMATION:
7811 Pine Valley Dr, Unit #1,
Woodbridge ON L4L0L2
TEL: 416-613-5880
EMAIL: INFO@WARD99ARCHITECTS.COM

ROOM NAME 1	TITLE: ROOM NAME
AREA #	REFERS TO ROOM NUMBER
D-CL-OP	REFERS TO AREA IN m2
	REFERS TO OCCUPANT LOAD

26 114163 79 LAURENTIAN DR

Industrial / Commercial / Institutional
Elementary School New School

ONTARIO ASSOCIATION
OF
ARCHITECTS
Tina Ranieri d'Ovidio
TINA RANIERI D'OVIDIO
LICENCE
5980

City of Toronto 2024 Building Code Data Matrix Part 11 - Renovation of Existing Building					Building Code Reference
11.0	Building Code Version:	O Reg. 163/24 _____		Last Amendment:	O Reg. 5/25 _____
11.01	Project Type:	☐ Addition ☒ Renovation ☐ Addition and Renovation ☐ Change of use			[A]1.1.2.
11.02	Major Occupancy Classification:	Description: Renovation to the existing one storey school building to provide for a renovation to the existing main office area and provision for a new barrier-free washroom. Area of renovation is 146.92m ² . Occupancy: Group A, Division 2 Use: Elementary School "Group A, Division 2, up to 2 Storeys"			3.1.2.1.(1) O.B.C. 3.2.2.25
11.03	Superimposed Major Occupancies:	☒ No ☐ Yes Description:			3.2.2.7
11.04	Building Area (m ²)	Description: Building Area (m ²):	Existing 2354.43 m ²	New 0 m ²	Total 2354.43 m ²
11.05	Building Height	☒ Storey Above Grade ☐ Storey Below Grade 3.90 (m) Above Grade			[A]1.4.1.2 & 3.2.1.1.
11.06	Number of Streets/Firefighter Access	☒ Street(s)			3.2.2.10. & 3.2.2.5
11.07	Building Size	☐ Small ☒ Medium ☐ Large ☐ >Large			T.11.2.1.1.B.-N.
11.08	Existing Building Classification:	Change in Major Occupancy: ☐ Yes ☒ No Not Applicable (no change of major occupancy) Construction Index: - Hazard Index: - Importance Category: ☐ Low ☐ Normal ☐ High ☐ Post-disaster *Building is an elementary school.			11.2.1.1. T.11.2.1.1.B.T.O.N. 4.2.1.(3) 5.2.2.1.(2)
11.09	Renovation Type:	☐ Basic Renovation ☒ Extensive Renovation			11.3.3.1. 11.3.3.2.
11.10	Occupant Load:	Floor Level/Area	Occupancy Type	Based On	Occupant Load (Persons)
*Note: OCCUPANCY OF THE SCHOOL BUILDING REMAINS UNCHANGED.					
11.11	Plumbing Fixture Requirements	Ratio: M:F = 50:50 Except as otherwise noted Note: Ground Floor Revisions: Demolish two existing single-use staff washrooms and replace with two new single-use staff washrooms. Addition of one new barrier-free washroom.			374, 11.34, 11.35, 11.42.4, and 11.42.5
11.12	Barrier-free Design:	☒ Yes ☐ No Existing - 11.3.3.2. Extensive Renovation _____ Barrier-free Entrances: Number: n/a Barrier-free entrances remains unchanged. Renovation complies with OBC 3.8.			11.3.12, 11.3.2, 11.3.3.2.
11.13	Reduction in Performance Level:	Structural: ☐ No ☐ Yes By Increase in Occupant Load: ☐ No ☐ Yes (explain) By Change of Major Occupancy: ☐ No ☐ Yes (explain) Plumbing: ☐ No ☐ Yes (explain) Sewage-System: ☐ No ☐ Yes (explain) Extension of combustible construction: ☒ No ☐ Yes			11.4.2.1 11.4.2.2 11.4.2.3 11.4.2.4 11.4.2.5 11.4.2.6
11.14	Compensating Construction:	☒ No ☐ Yes _____ Structural: ☐ No ☐ Yes (explain) Increase in Occupant Load: ☐ No ☐ Yes (explain) Change of Major Occupancy: ☐ No ☐ Yes (explain) Plumbing: ☐ No ☐ Yes (explain) Sewage-System: ☐ No ☐ Yes (explain) Extension of Combustible Construction: ☐ No ☐ Yes (explain)			11.4.3.1 11.4.3.2 11.4.3.3 11.4.3.4 11.4.3.5 11.4.3.6 11.4.3.7.
11.15	Compliance Alternatives Proposed:	☒ No ☐ Yes (list numbers and describe)			11.5.1

11.16 General Notes:

Renovations to the existing one-story non-sprinklered school building; double classification is as follows: O.D.G. Classification: 3.2.2.25 Group A Division 2, up to 2 Stories

- building is not more than 45 m in height
- building is permitted to be combustible or noncombustible construction
- floor assemblies shall be fire separations and, if of combustible construction, shall have a fire-resistance rating not less than 45 min
- except as permitted by Article 3.2.2.17, mezzanines shall have, if of combustible construction, a fire-resistance rating not less than 45 min
- except as permitted by Article 3.2.2.17, roof assemblies shall have, if of combustible construction, a fire-resistance rating not less than 45 min
- loadbearing walls, columns and arches supporting an assembly required to have a fire-resistance rating shall
- (a) have a fire-resistance rating not less than 45 min, or
- (b) be of noncombustible construction.


*Note: The existing school is less than 2 stories in height and is constructed of noncombustible construction. Rating at the roof level is not required.

3.2.3.6.3 (b) Sprinklered Corridors: The 45 min fire resistance rating for the fire separation required at a corridor, in an assembly occupancy, is permitted to be waived if the floor area in which the corridor is located is sprinklered. *Note: The existing school is not sprinklered and in such a fire separation with a 1 hour fire-resistance rating is required.

Scope of Work:

1. Complete renovation of the existing main office and staff work spaces in the one storey school.
2. Demolition of existing masonry and gypsum board finished partitions, flooring , wall and ceiling assemblies, millwork and fittings, door and window assemblies and provision for new partitions and assemblies to suit the new main office and staff spaces.
3. Removal of two single-use staff washrooms and replacement with two single-use staff washrooms and one barrier-free washroom.
4. Mechanical and electrical upgrades including new light fixtures and devices to suit the renovated layout.
5. Structural upgrades to suit the new layout.

NOTE: THIS DRAWING IS NOT TO BE SCALED. THE CONTRACTOR IS RESPONSIBLE FOR THE VERIFICATION OF ALL SITE DIMENSIONS AND FOR NOTIFYING THE ARCHITECT OF ANY SITE CONDITIONS AND SITE MEASUREMENTS THAT ARE NOT CONSISTENT WITH THE DRAWINGS.

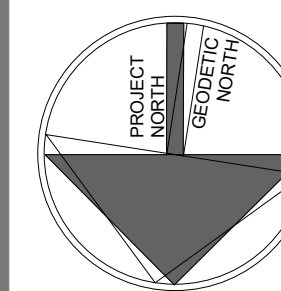[illegible]

project

TRILLIUM JUNIOR PUBLIC SCHOOL INTERIOR RENOVATIONS
WATERLOO REGION DISTRICT SCHOOL BOARD

79 Laurentian Dr, Kitchener, ON N2E 1C3

drawing

PROJECT TITLE, DRAWING LIST, PROJECT KEY PLAN, AND INFORMATION
STATEMENT AND LEGEND

drawing scale





N/A
ward99 project number
25022 - WRDSB TRILLIUM PS


ward99
architects


Wa
RD
99

ward99 architects inc.
7611 Pine Valley Dr. Unit 11,
Woodbridge ON L4L0A2
info@ward99architects.com
416 613 5850 www.ward99architects.com

  A0.0

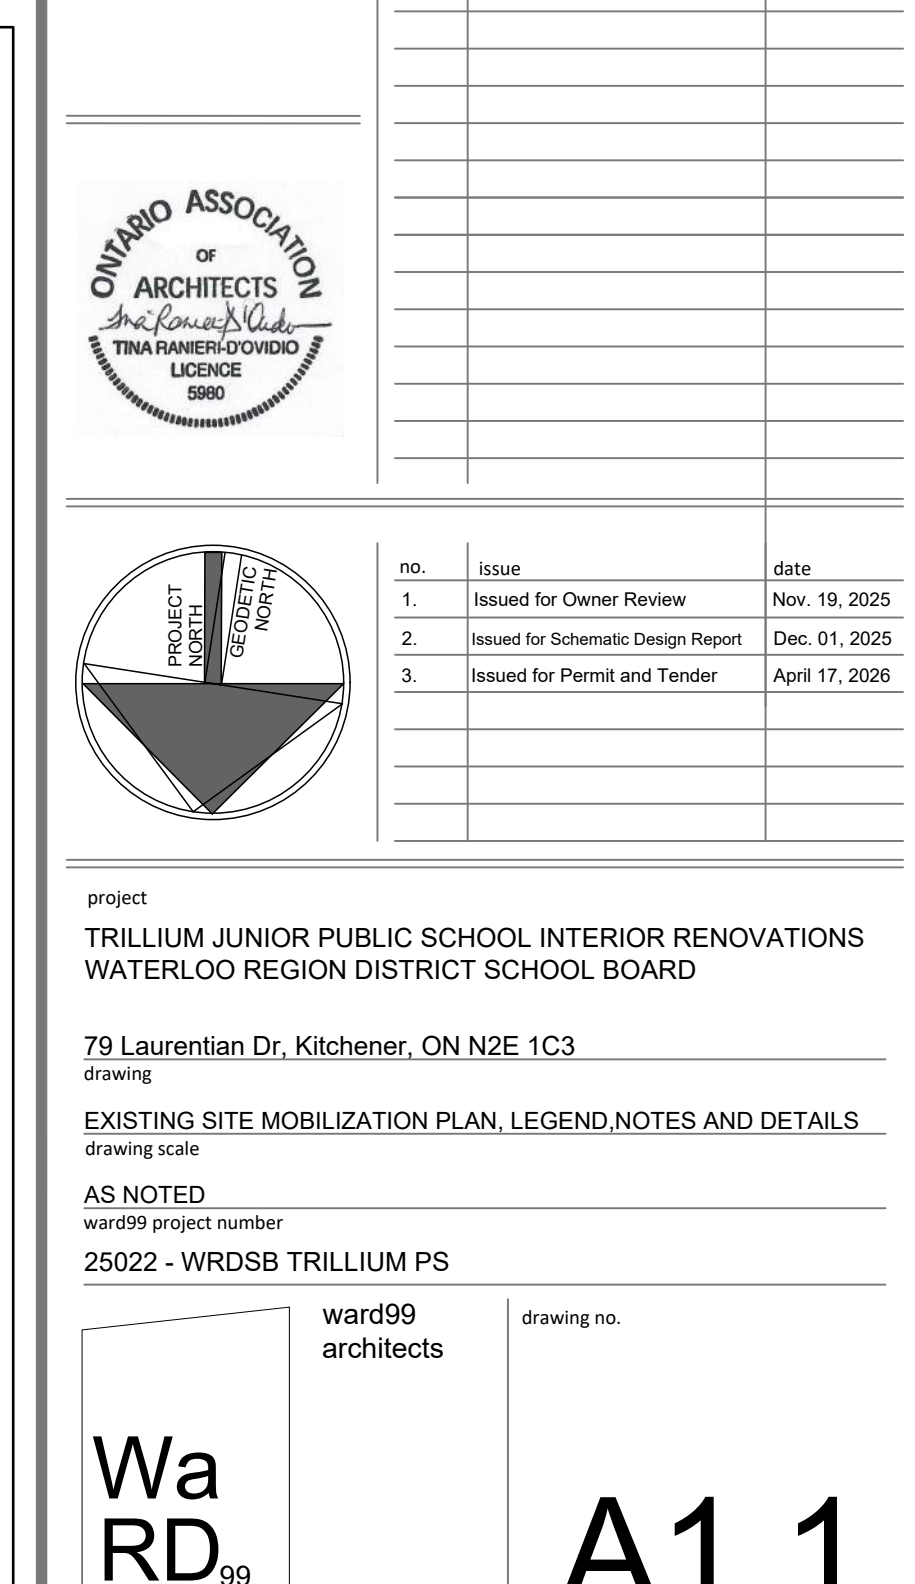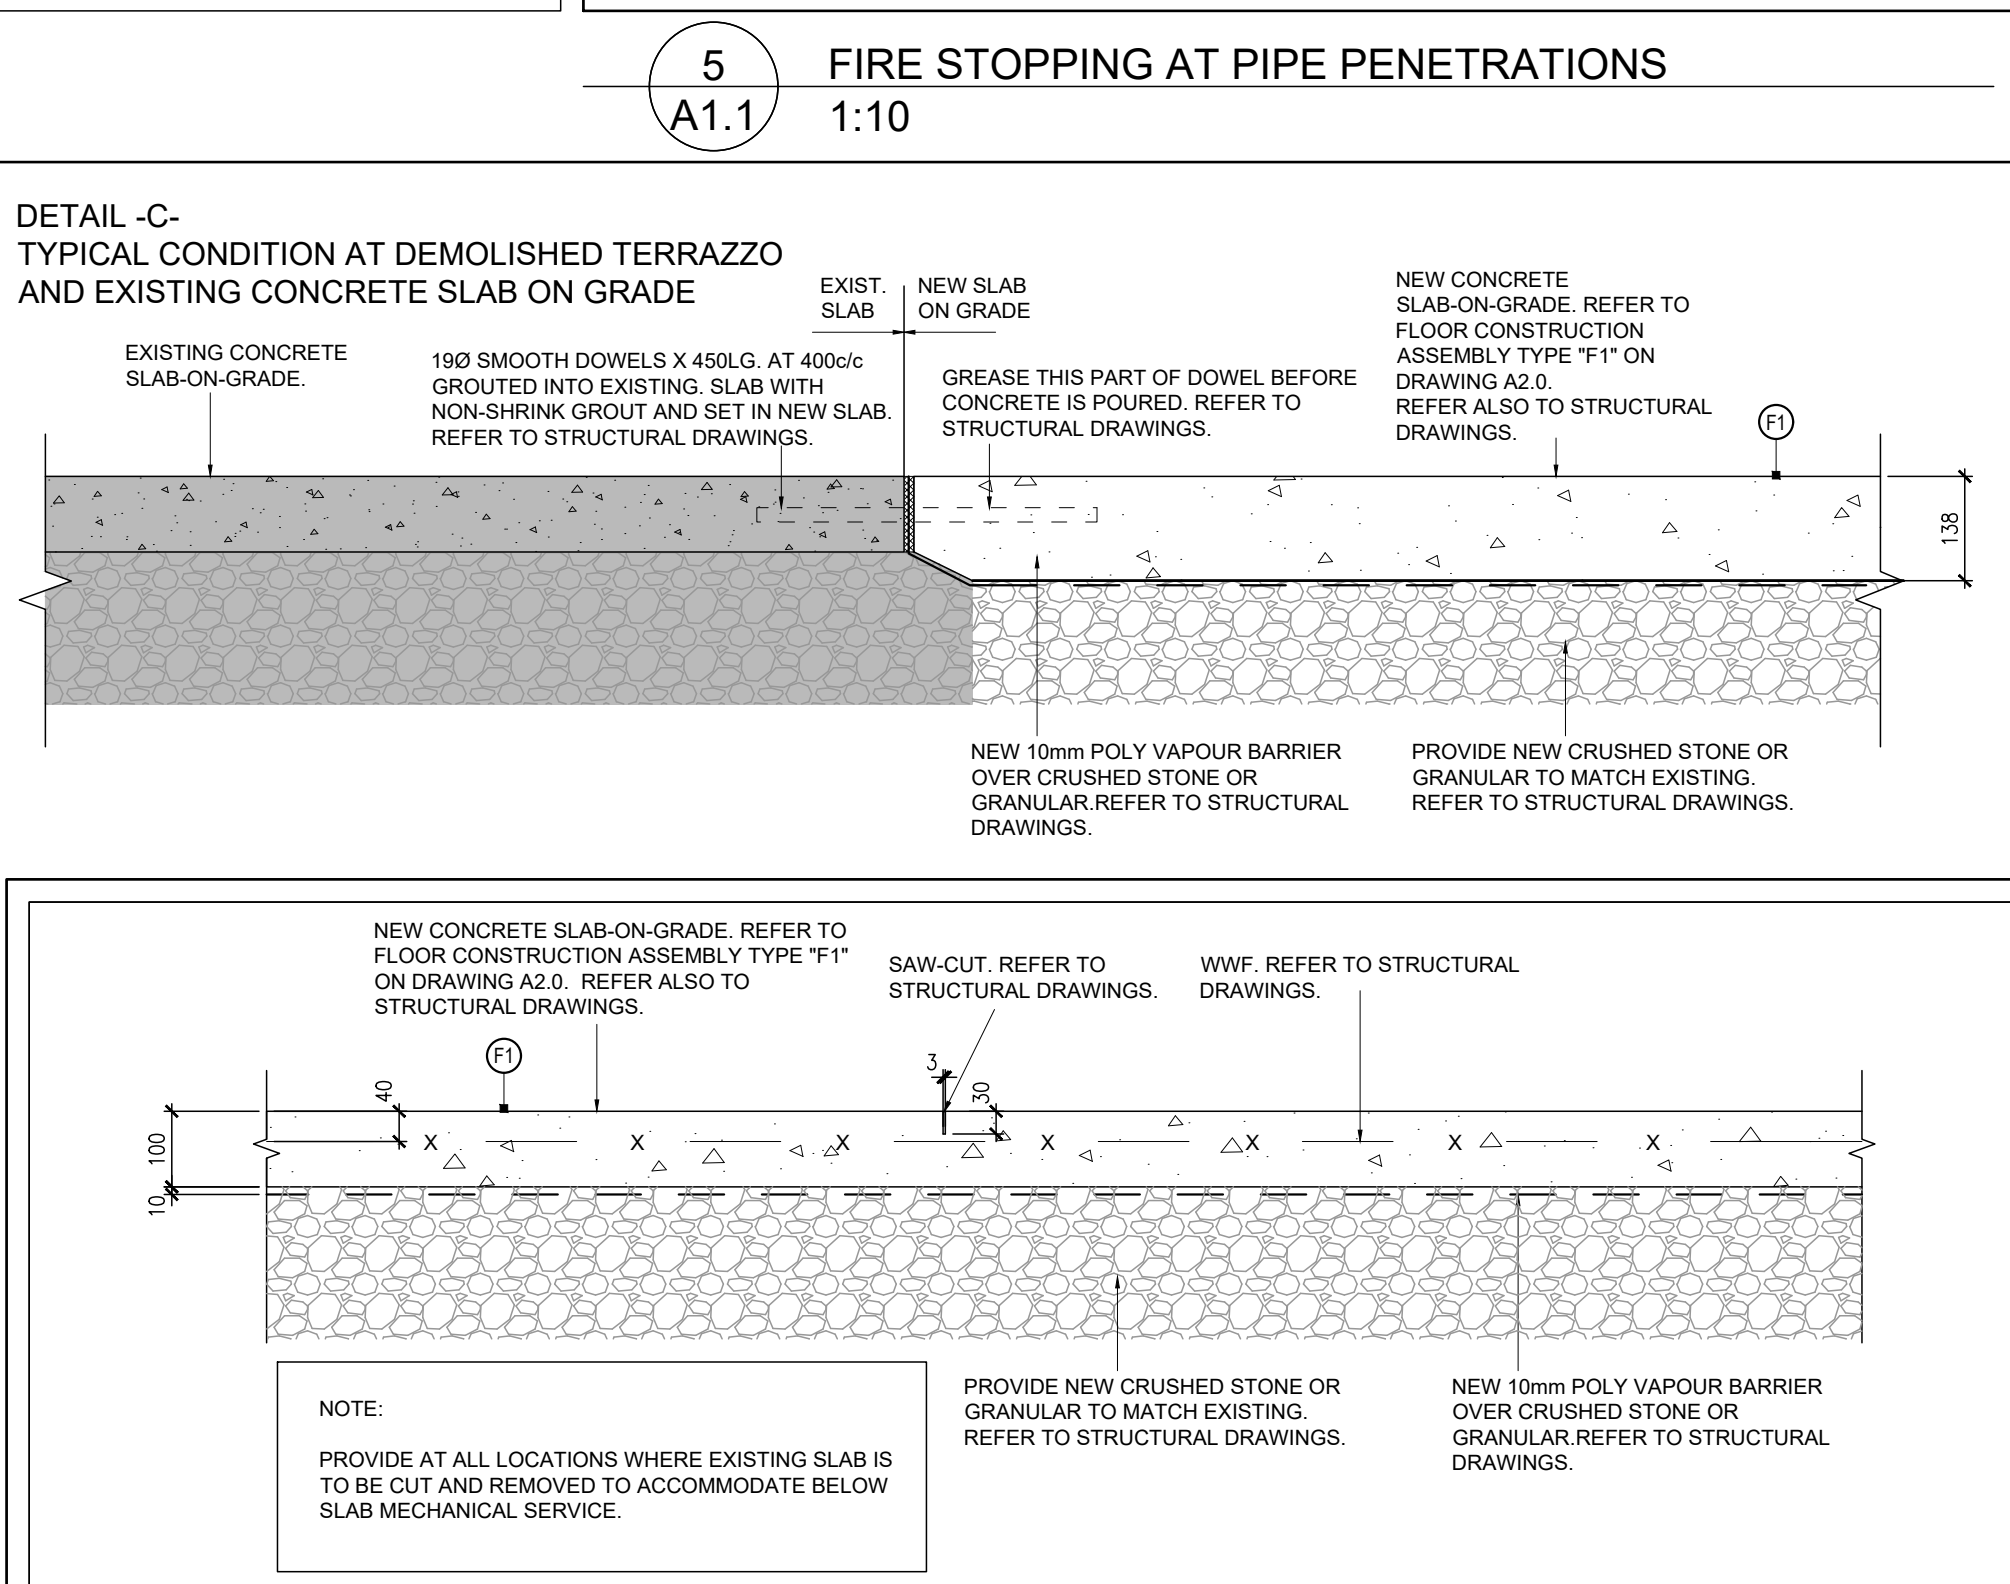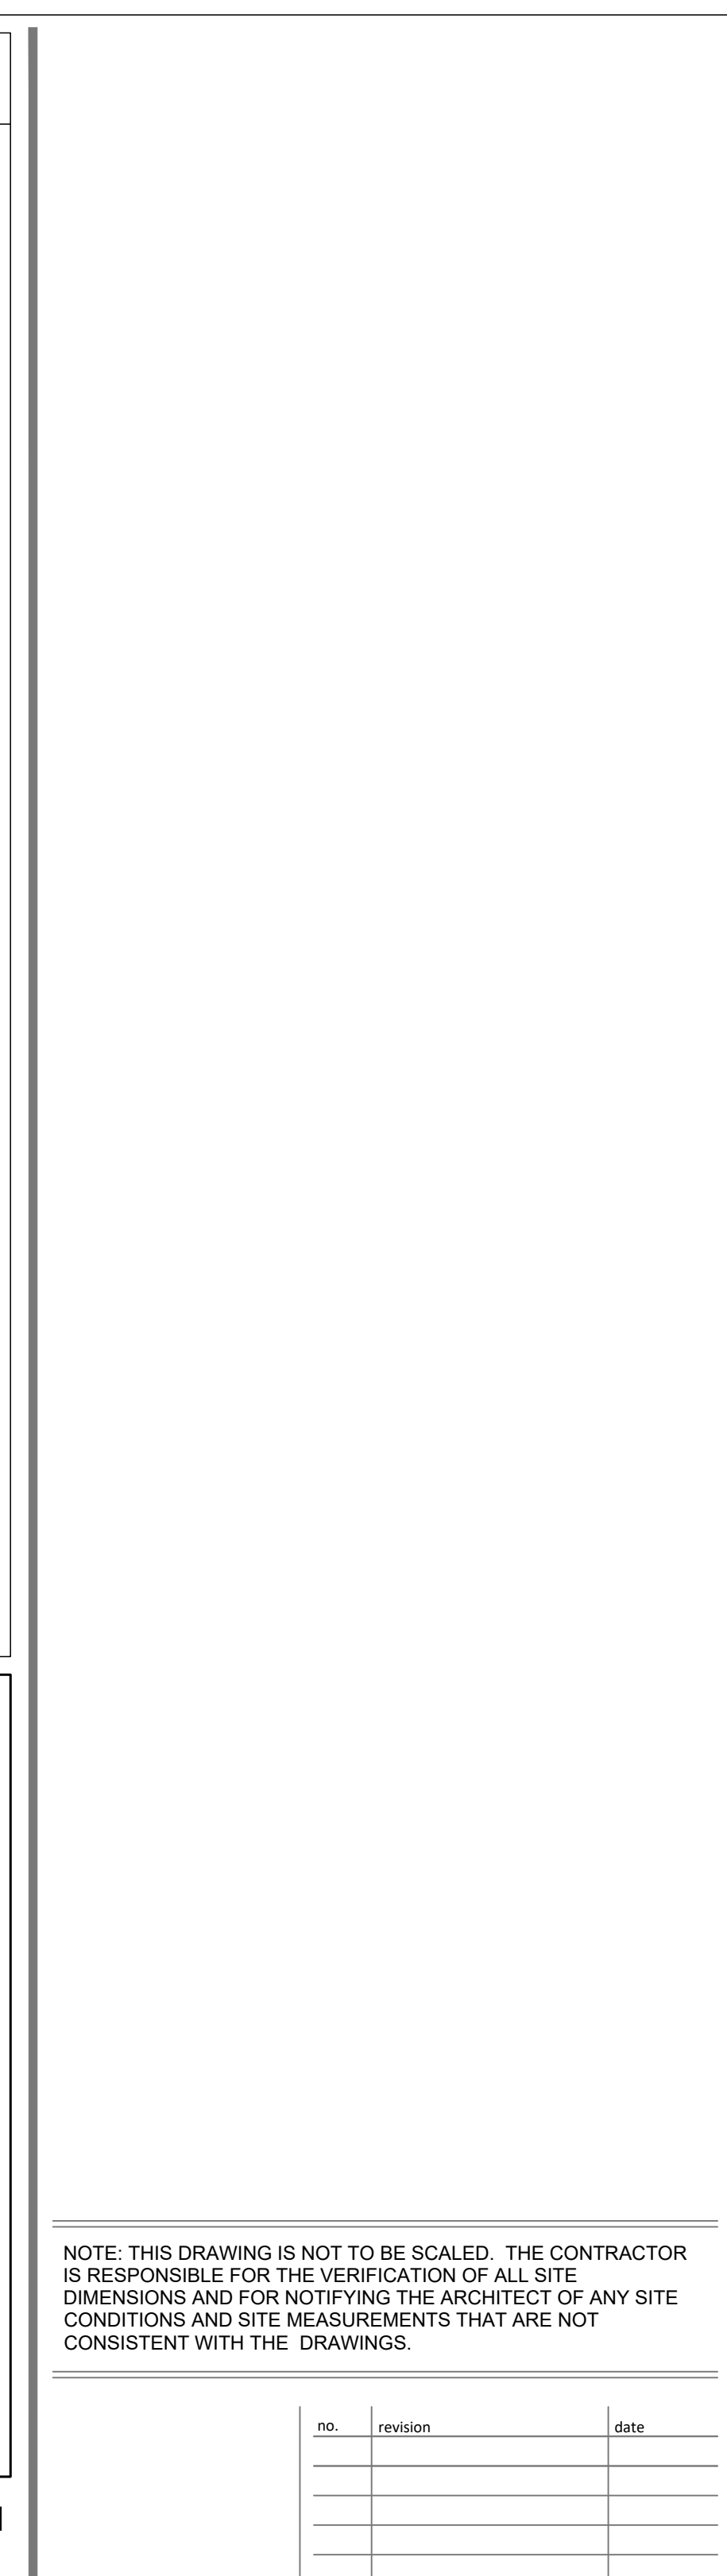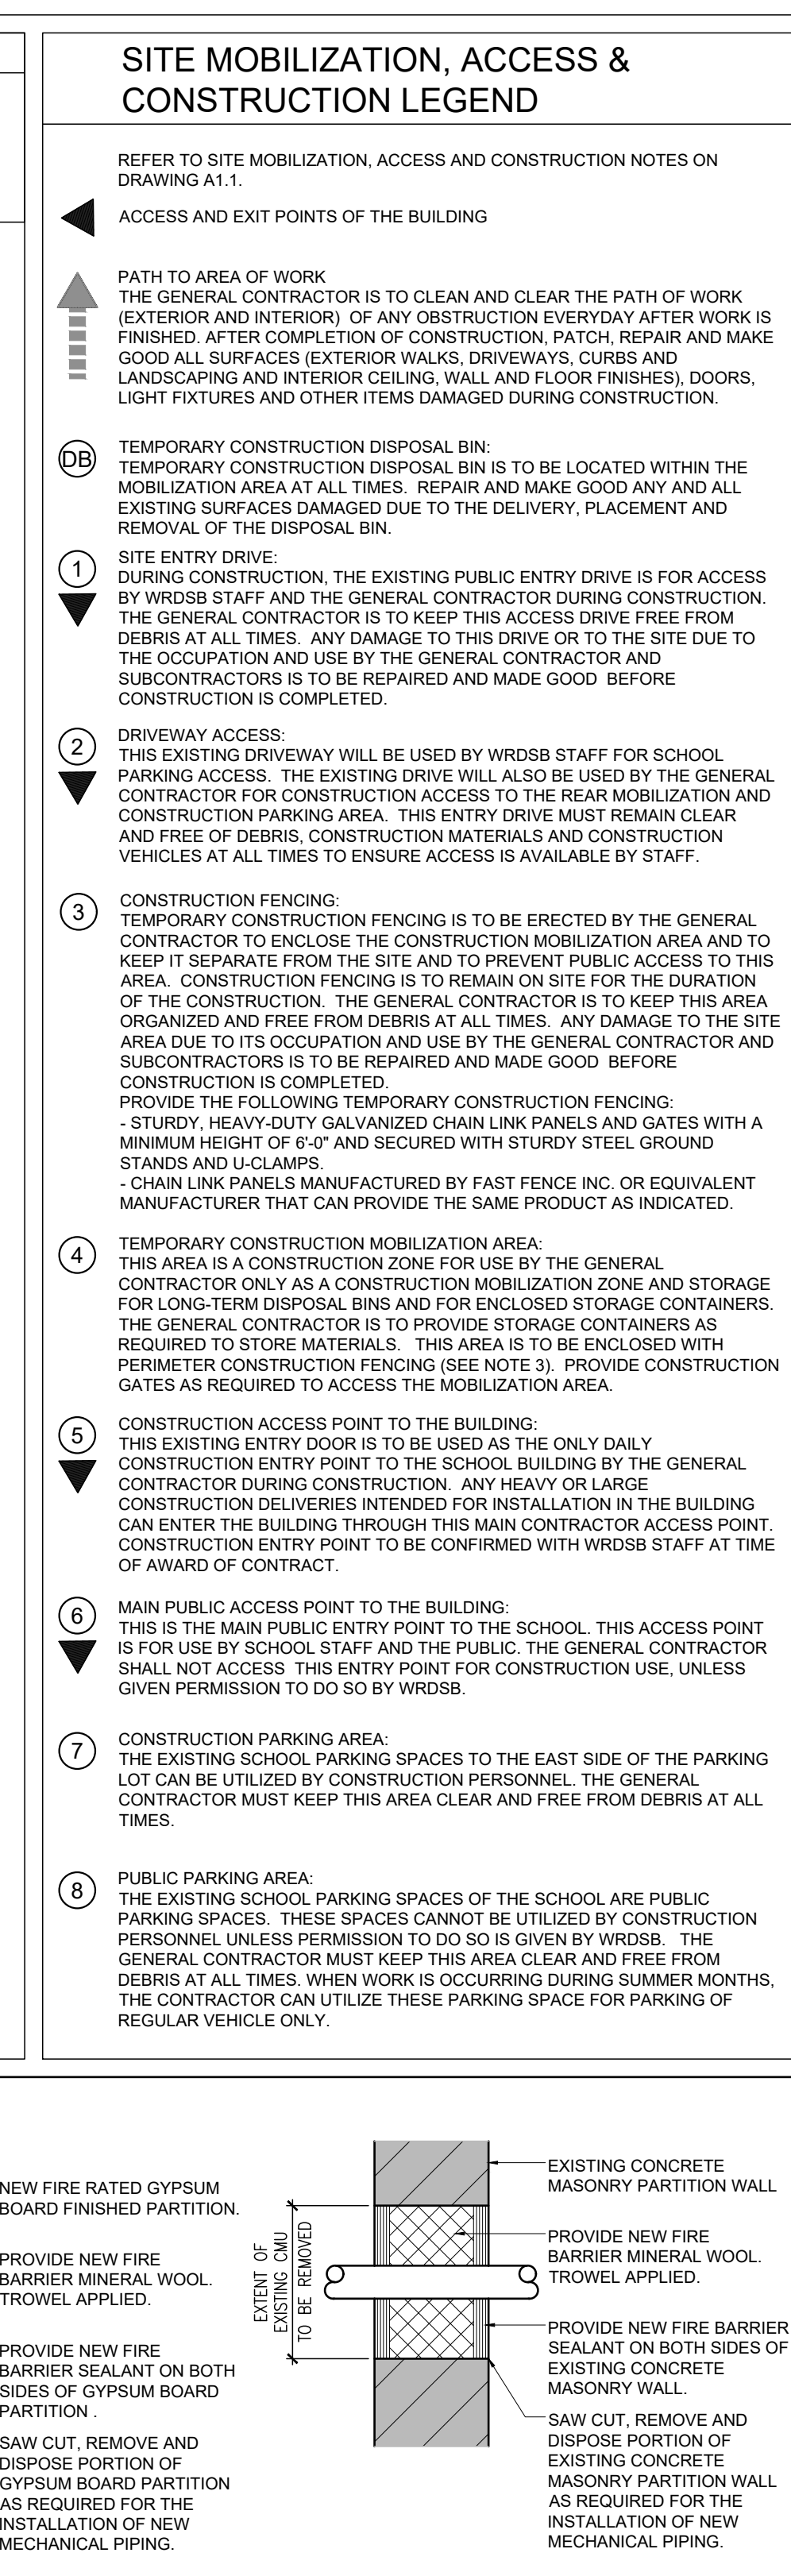






7611 Pine Valley Dr. Unit 11,
Woodbridge ON L4L0A2
info@warriorarchitects.com


ward99 architects inc.
7611 Pine Valley Dr. Unit 11,
Woodbridge ON L4L0A2
info@ward99architects.com
416 613 5880 www.ward99architects.com




A5.3

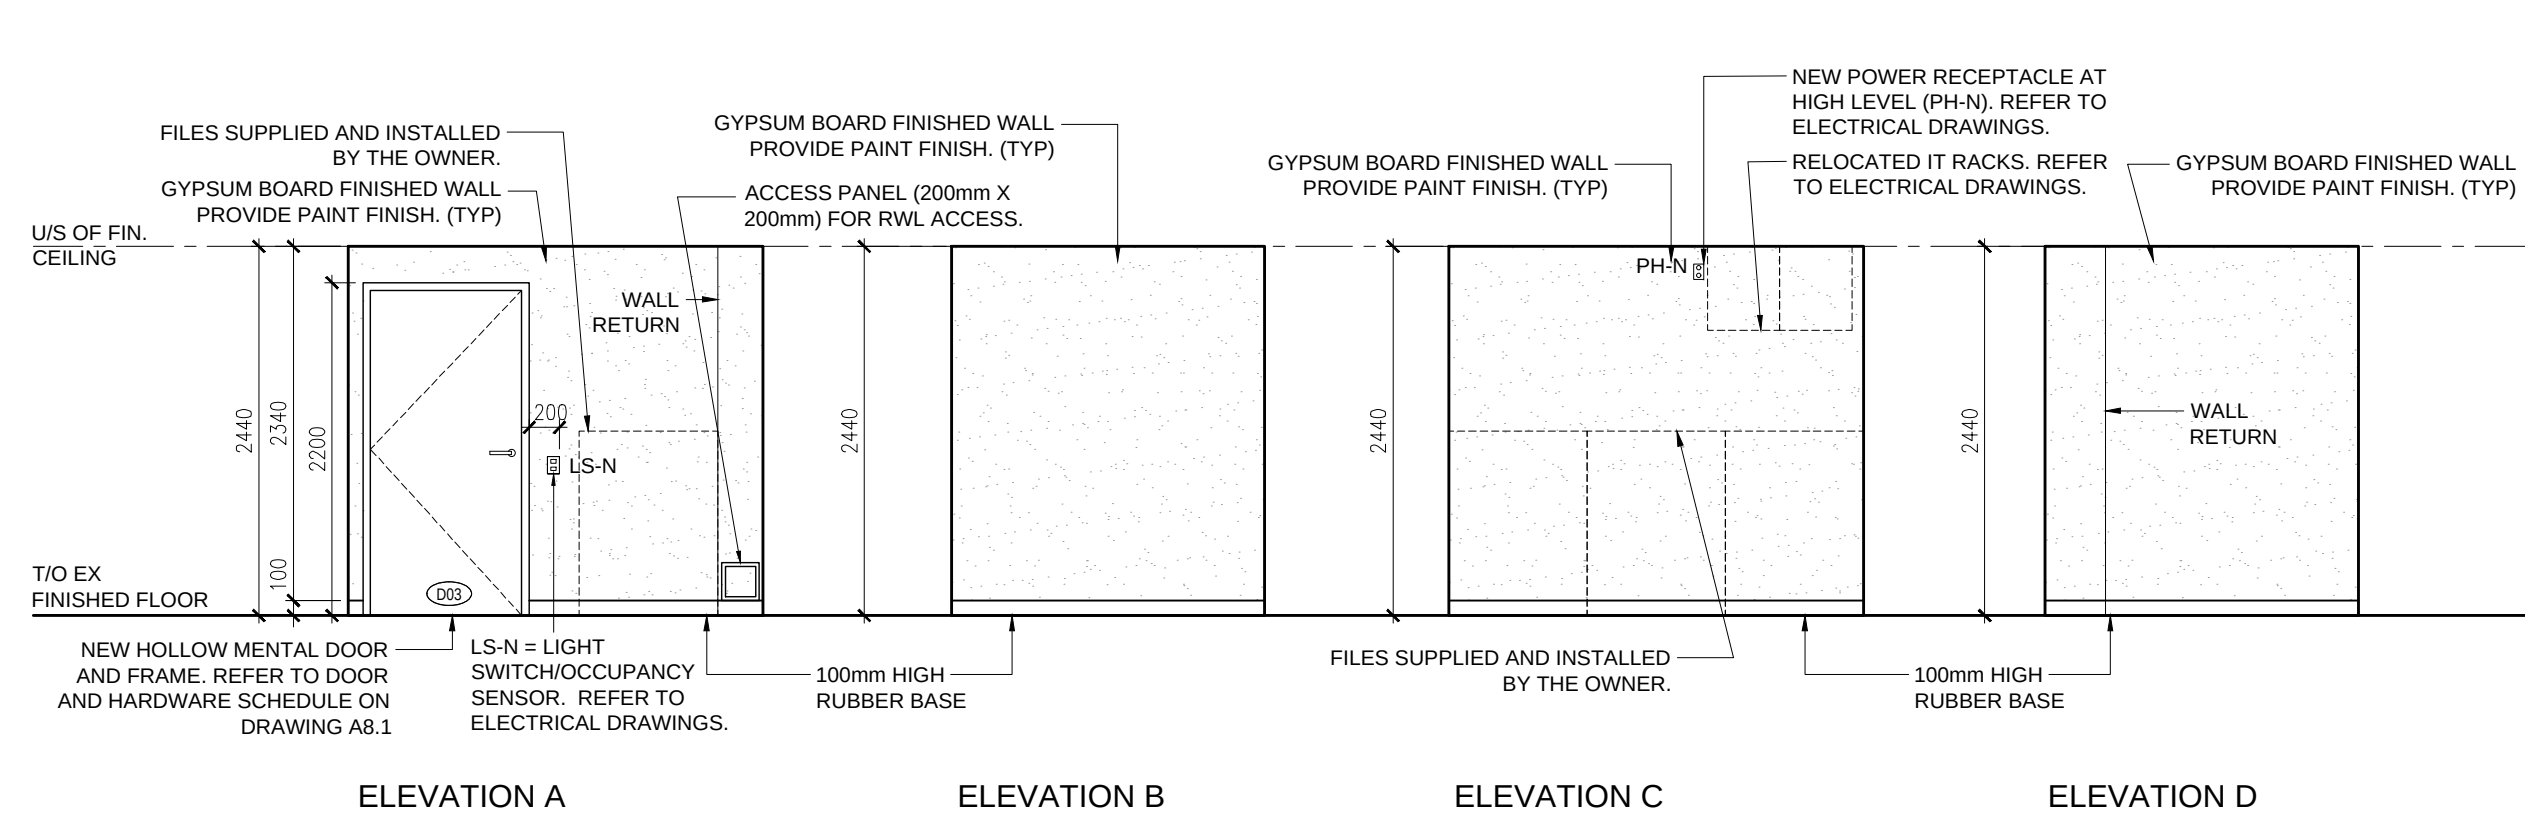

8 INTERIOR ELEVATION AT OSR ROOM F3
A6.1 1:50

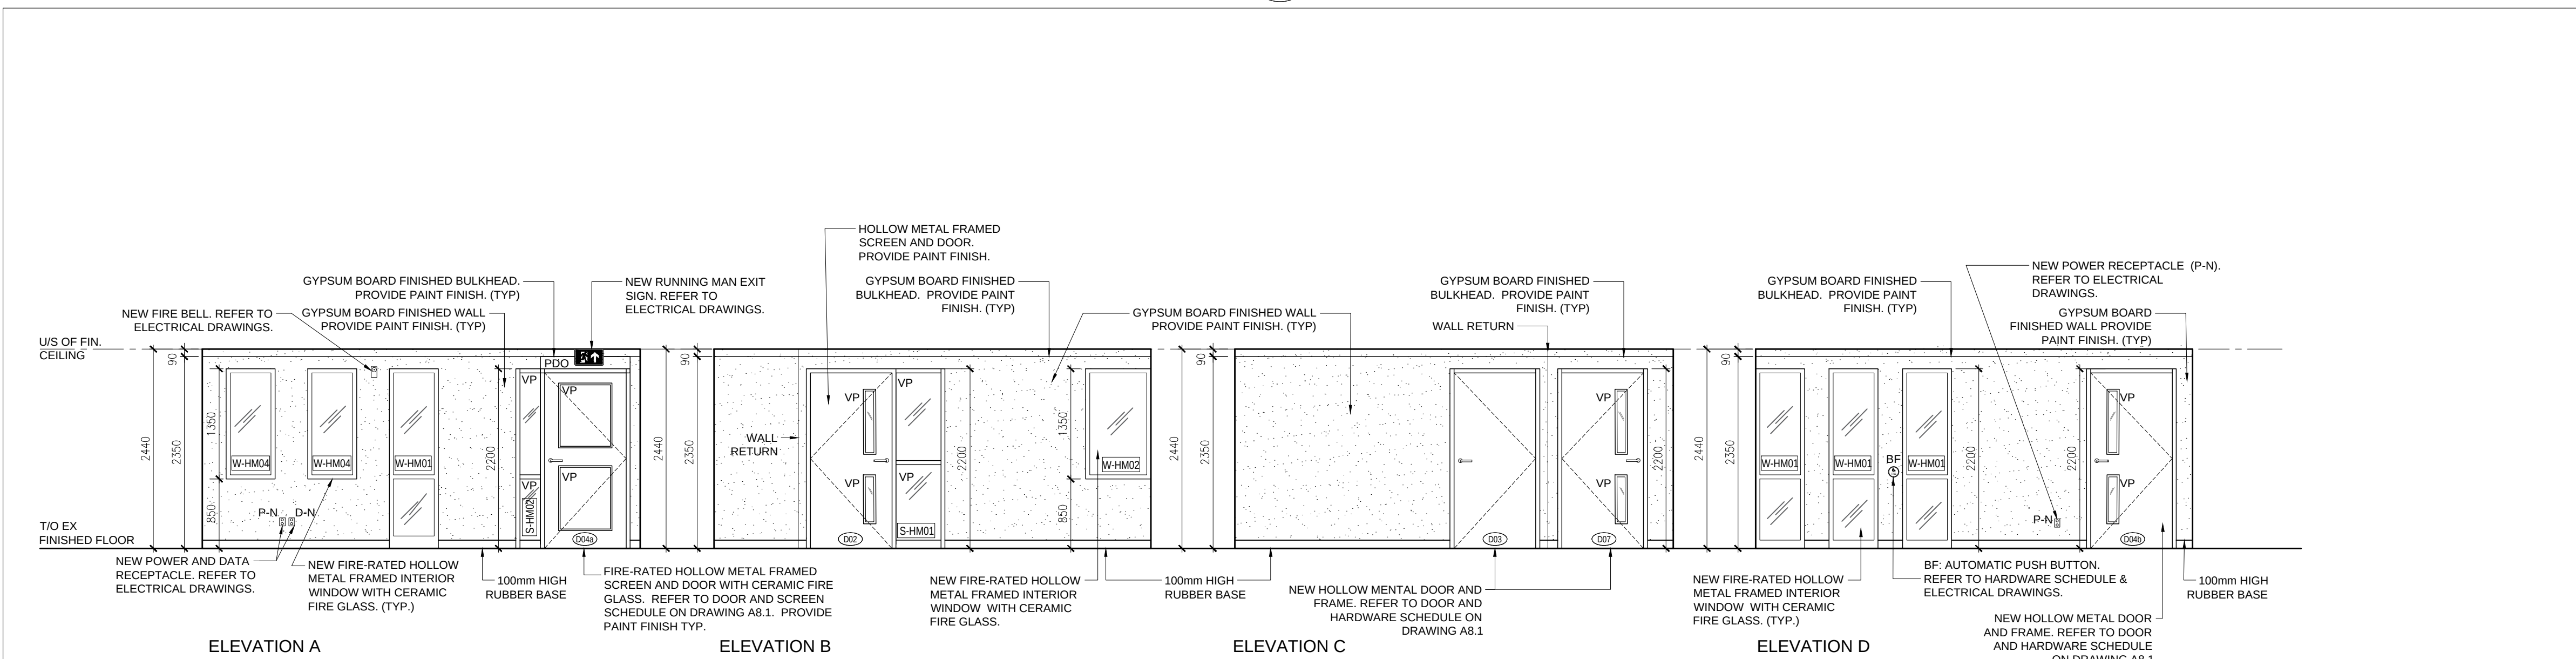


ELEVATION C

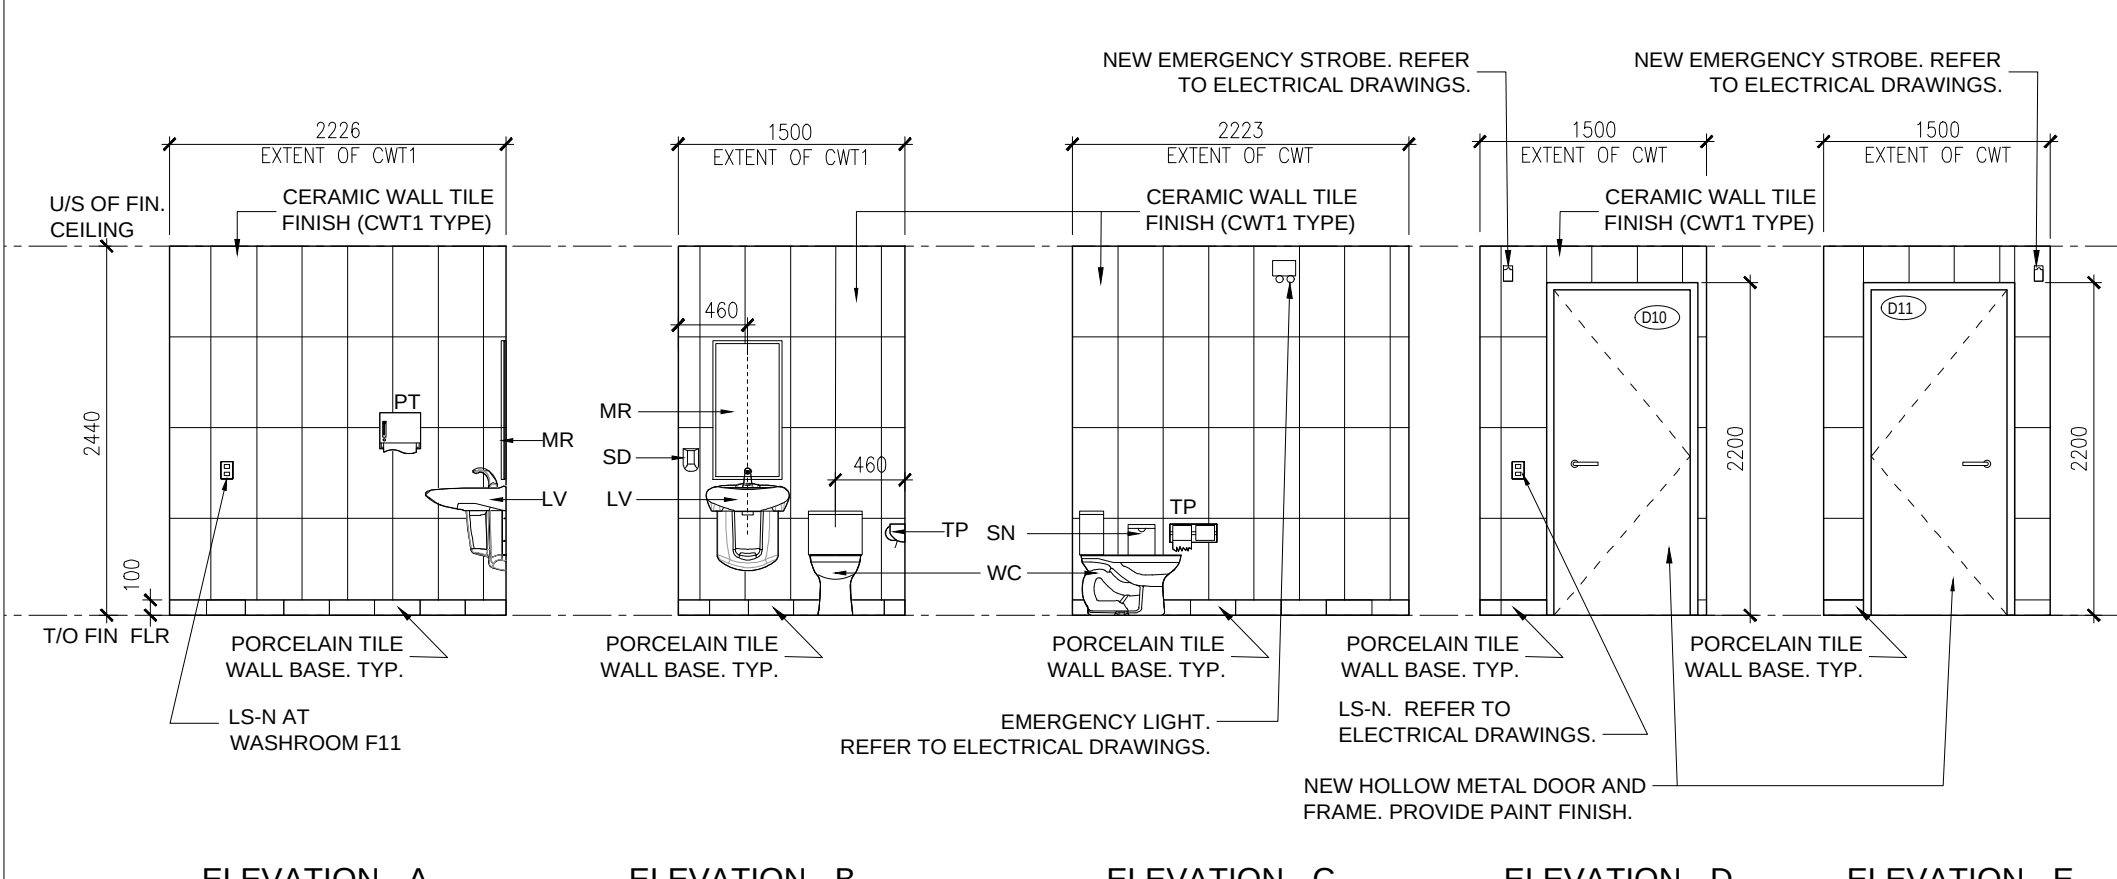





4 INTERIOR ELEVATION AT STAFF WASHROOM F10/F11
A6.1 1:50

no.	issue	date
1.	Issued for Owner Review	Nov. 19, 2025
2.	Issued for Schematic Design Report	Dec. 01, 2025
3.	Issued for Permit and Tender	April 17, 2026

A6.1

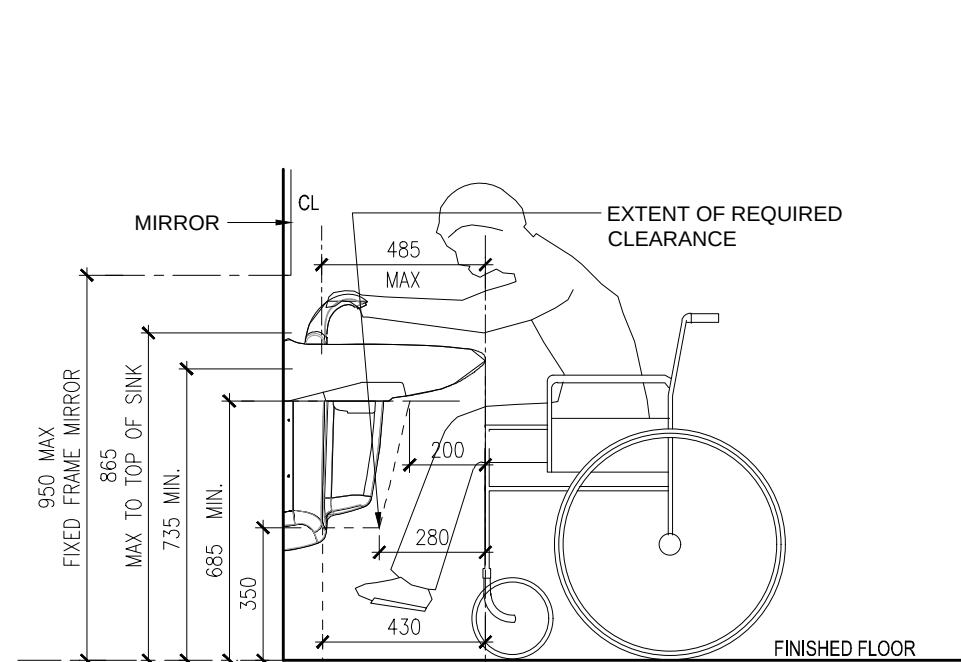

   1 BARRIER-FREE WATER CLOSING
A6.1 REQUIREMENTS

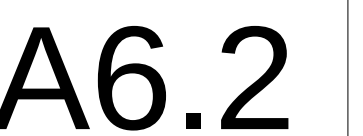



ward99 architects inc.
7611 Pine Valley Dr. Unit 11,
Woodbridge ON L4L0A2
info@ward99architects.com
416 613 5880 www.ward99architects.com

A7.1



ward99 architects inc.
7611 Pine Valley Dr. Unit 11,
Woodbridge ON L4L0A2
info@ward99architects.com

A7.2



A7.4



A7.9



A7.


Wa
RD₉₉

DOOR AND HARDWARE SCHEDULE													DOOR FRAME AND SCREEN				DOOR, DOOR FRAME & SCREEN NOTES		DOOR HARDWARE REQUIREMENTS & NOTES	
DOOR No.	ROOM NAME	FIRE RATING	WIDTH	HEIGHT	THICK	MATERIAL	FINISH	TYPE	VISION PANEL	MATERIAL	FINISH	TYPE	VISION PANEL							
D02	PRINCIPAL'S OFFICE	-	1000mm	2150mm	45mm	HOLLOW METAL	PNT	D3	TGL	HOLLOW METAL	PNT	S-HM01	TGL				REFER TO HOLLOW METAL SCREEN ELEVATION TYPE S-HM01 ON DRAWING 4/A8.1 FOR HOLLOW METAL FRAMED SCREEN DETAILS AND DETAILS ON 2/A8.2.		1-1/2 HINGE (PAIRS), LOCKSET, MASTER KEY, CYLINDER, KICK PLATE, FLOOR STOP	
D03	OSR	-	1000mm	2150mm	45mm	HOLLOW METAL	PNT	D1	-	HOLLOW METAL	PNT	F1	-				REFER TO HOLLOW METAL DOOR FRAME DETAILS B, E, AND F ON DRAWING 2/A8.2.		1-1/2 HINGE (PAIRS), LOCKSET, MASTER KEY, CYLINDER, KICK PLATE, FLOOR STOP	
D04a	MAIN OFFICE	3/4 HR	1000mm	2150mm	45mm	HOLLOW METAL	PNT	D2	CFG	HOLLOW METAL	PNT	S-HM02	CFG				REFER TO HOLLOW METAL SCREEN ELEVATION TYPE S-HM02 ON DRAWING 4/A8.1 FOR FIRE-RATED HOLLOW METAL FRAMED SCREEN DETAILS. REFER TO PLAN DETAILS ON 1/A8.2.		1-1/2 HINGE (PAIRS), LOCKSET, MASTER KEY, CYLINDER, KICK PLATE, OVERHEAD STOP, ELECTRIC STRIKE, POWER DOOR OPERATOR, 2 WALL ACTUATORS, CLOSER, REFER TO ELECTRICAL DRAWINGS AND HARDWARE LIST.	
D04b	MAIN OFFICE	-	1000mm	2150mm	45mm	HOLLOW METAL	PNT	D3	TGL	HOLLOW METAL	PNT	F1	-				REFER TO HOLLOW METAL DOOR FRAME DETAILS B, E, AND F ON DRAWING 2/A8.2.		1-1/2 HINGE (PAIRS), LOCKSET, MASTER KEY, CYLINDER, KICK PLATE, OVERHEAD STOP.	
D05	WORK ROOM	3/4 HR	1000mm	2150mm	45mm	HOLLOW METAL	PNT	D3	CFG	HOLLOW METAL	PNT	F1	-				REFER TO FIRE-RATED HOLLOW METAL DOOR FRAME DETAILS I, F, AND H ON DRAWING 1/A8.2. REFER TO PLAN DETAILS ON 7/A8.1.		1-1/2 HINGE (PAIRS), LOCKSET, MASTER KEY, INTERFACE BOX, CYLINDER, KICK PLATE, OVERHEAD STOP, ELECTRIC STRIKE, POWER DOOR OPERATOR, 2 WALL ACTUATORS, CLOSER, REFER TO ELECTRICAL DRAWINGS AND HARDWARE SPECIFICATIONS.	
D07	SEMINAR ROOM	-	1000mm	2150mm	45mm	HOLLOW METAL	PNT	D3	TGL	HOLLOW METAL	PNT	F1	-				REFER TO HOLLOW METAL DOOR FRAME DETAILS B, E, AND F ON DRAWING 2/A8.2.		1-1/2 HINGE (PAIRS), LOCKSET, MASTER KEY, CYLINDER, KICK PLATE, FLOOR STOP.	
D08a	STAFF LOUNGE	-	1000mm	2150mm	45mm	HOLLOW METAL	PNT	D3	TGL	HOLLOW METAL	PNT	S-HM01	TGL				REFER TO HOLLOW METAL SCREEN ELEVATION TYPE S-HM01 ON DRAWING 4/A8.1 FOR HOLLOW METAL FRAMED SCREEN DETAILS AND DETAILS ON 2/A8.2.		1-1/2 HINGE (PAIRS), LOCKSET, MASTER KEY, CYLINDER, KICK PLATE, OVERHEAD STOP.	
D08b	STAFF LOUNGE	-	1000mm	2150mm	50mm	ALUM	CLEAR ANODIZED	D3	IGU	ALUM	CLEAR ANODIZED	S-AL01	IGU				REFER TO ALUMINUM CURTAIN WALL SCREEN DETAILS ON DRAWING 6/A4.2.		CONTINUOUS HINGE, LOCKSET, MASTER KEY, CYLINDER, OVERHEAD STOP	
D09	B-FREE WRM	3/4 HR	1000mm	2150mm	45mm	HOLLOW METAL	PNT	D1	-	HOLLOW METAL	PNT	F1	-				REFER TO FIRE-RATED HOLLOW METAL DOOR FRAME DETAILS L, N, AND Q ON DRAWING 1/A8.2 AND PLAN DETAILS ON 7/A8.1.		CONTINUOUS HINGE, LOCKSET, MASTER KEY, INTERFACE BOX, CYLINDER, KICK PLATE, OVERHEAD STOP, ELECTRIC STRIKE, POWER DOOR OPERATOR, MOUNTING PLATE, 2 WALL ACTUATORS, EMERGENCY PANIC SYSTEM, CLOSER, REFER TO ELECTRICAL DRAWINGS AND HARDWARE SPECIFICATIONS.	
D10	WRM	-	900mm	2150mm	45mm	HOLLOW METAL	PNT	D1	-	HOLLOW METAL	PNT	F1	-				REFER TO HOLLOW METAL DOOR FRAME DETAILS H, J, AND I ON DRAWING 2/A8.2 AND PLAN DETAILS ON 7/A8.1.		CONTINUOUS HINGE, LOCKSET, MASTER KEY, CYLINDER, KICK PLATE, OVERHEAD STOP.	
D11	WRM	-	900mm	2150mm	45mm	HOLLOW METAL	PNT	D1	-	HOLLOW METAL	PNT	F1	-				REFER TO HOLLOW METAL DOOR FRAME DETAILS H, J, AND I ON DRAWING 2/A8.2 AND PLAN DETAILS ON 7/A8.1.		CONTINUOUS HINGE, LOCKSET, MASTER KEY, CYLINDER, KICK PLATE, OVERHEAD STOP.	
D16	LIBRARY	3/4 HR	1000mm	2150mm	45mm	HOLLOW METAL	PNT	D2	CFG	HOLLOW METAL	PNT	S-HM03	CFG				REFER TO HOLLOW METAL SCREEN ELEVATION TYPE S-HM03 ON DRAWING 4/A8.1 FOR HOLLOW METAL FRAMED SCREEN DETAILS.		CONTINUOUS HINGE, LOCKSET, MASTER KEY, CYLINDER, KICK PLATE, OVERHEAD STOP, CLOSER.	


GENERAL DOOR HARDWARE SCHEDULE NOTES

- REFER TO DRAWING 6/A8.1 FOR DOOR TYPE ELEVATION.
 - REFER TO DRAWING 2/A8.1 FOR HOLLOW METAL FRAMED WINDOW ELEVATION TYPES.
 - REFER TO DRAWING 3/A8.1 FOR HOLLOW METAL FRAMED DOOR ELEVATION TYPES.
 - REFER TO DRAWING 4/A8.1 FOR HOLLOW METAL FRAMED SCREEN ELEVATION TYPES.
 - SUPPLY AND INSTALLATION OF DOOR HARDWARE, INCLUDING AUTOMATIC DOOR HARDWARE IS CARRIED IN THE PROJECT CASH ALLOWANCE.
 - REFER TO DETAIL 5/A8.1 FOR DOOR HARDWARE LOCATION.
NOTE: THE FOLLOWING:
- AT 1025mm FROM TOP OF FINISHED FLOOR TO CENTER OF LOCKSET/LATCH SET.
- AT 100mm FROM DOOR SIDE EDGE TO CENTER OF DEADLOCK.
DOOR HINGES TO BE INSTALLED AS FOLLOWS:
- TOP HINGE: 125mm MAXIMUM FROM TOP OF HINGE TO TOP EDGE OF DOOR.
- CENTER HINGE: CENTERED BETWEEN TOP AND BOTTOM HINGE.
- BOTTOM HINGE: 265mm MAXIMUM FROM BOTTOM OF HINGE TO BOTTOM DOOR EDGE.
 - PAIN ALL NEW HOLLOW METAL DOORS, SCREENS AND FRAMES AND NEW HOLLOW METAL WINDOW FRAMES, BOTH SIDES, WITHIN THE PROJECT SCOPE OF WORK.
- CONTRACTOR TO SITE VERIFY ALL EXISTING OPENINGS PRIOR TO FABRICATION OF DOOR AND WINDOW REPLACEMENTS.
 - LIST OF ABBREVIATIONS:
TGL = SINGLE TEMPERED GLAZING UNITS.
CFG = CERAMIC FIRE GLASS UNITS.
IGU = INSULATED DOUBLE GLAZING UNITS.
HM = HOLLOW METAL.
ALUM = ALUMINUM FRAME.
PNT = PAINT FINISH.
 - SITE VERIFY ALL EXISTING CONDITIONS PRIOR TO FABRICATION AND INSTALLATION OF NEW HOLLOW METAL DOOR FRAMES, ALUMINUM FRAMED STOREFRONT DOOR AND SCREENS AND HOLLOW METAL WINDOW FRAMES.

7 DOOR AND DOOR FRAME HARDWARE SCHEDULE AND NOTES A8.1 N.T.S.

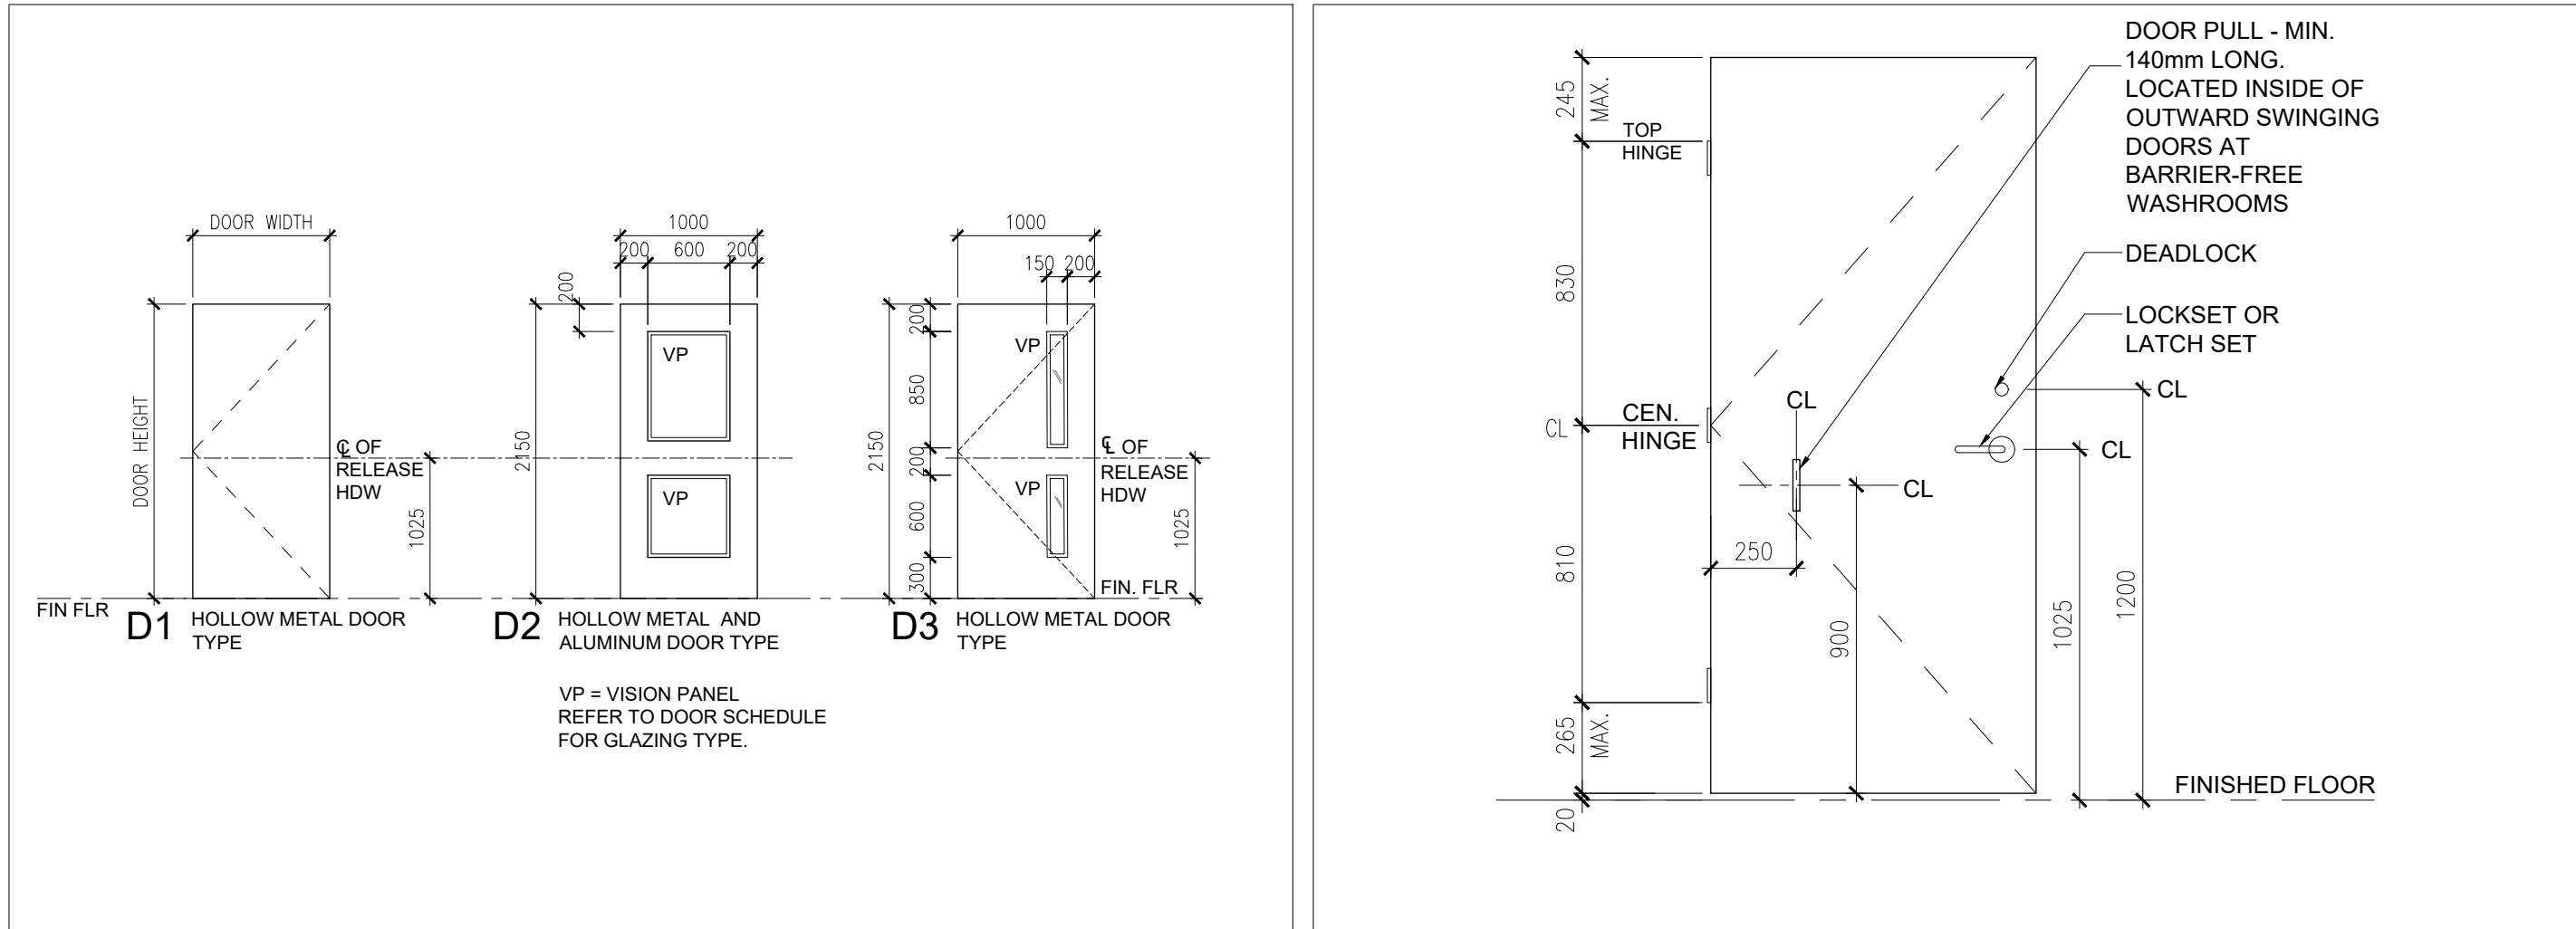


6 DOOR TYPE ELEVATIONS A8.1 1:50

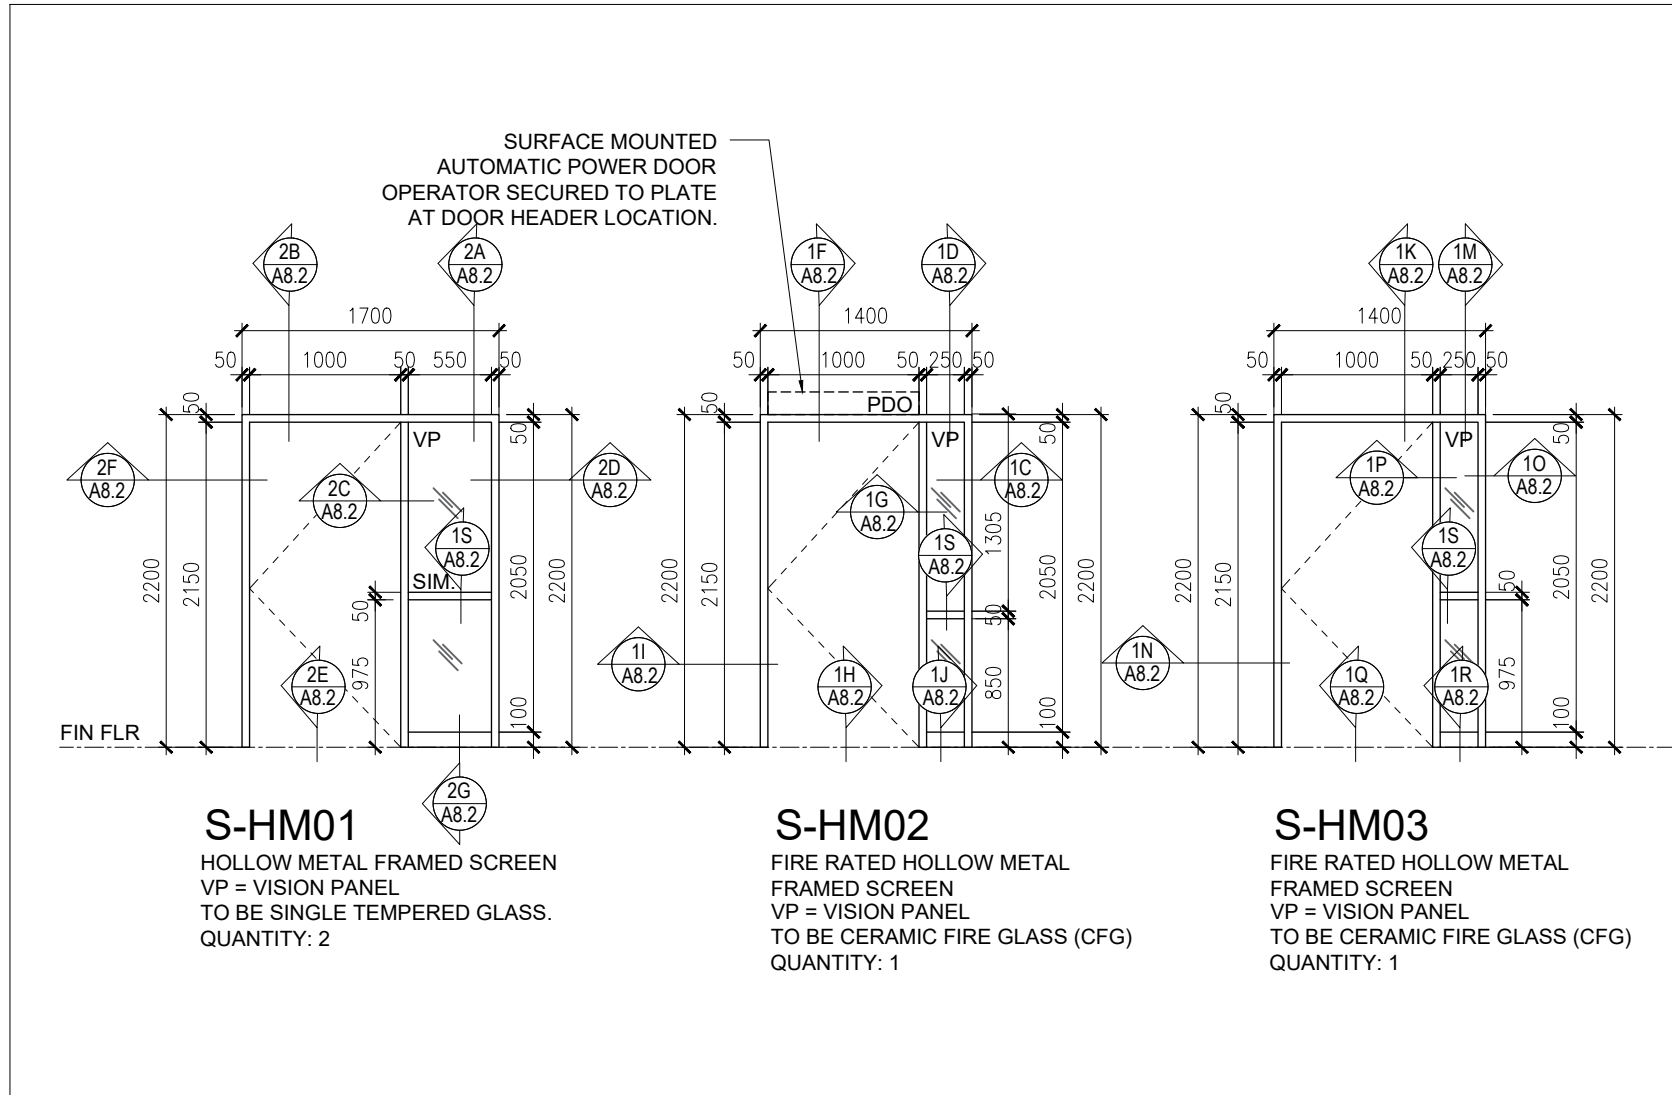


4 HOLLOW METAL FRAMED SCREEN ELEVATION TYPES A8.1 1:50

5 DOOR HARDWARE A8.1 1:20

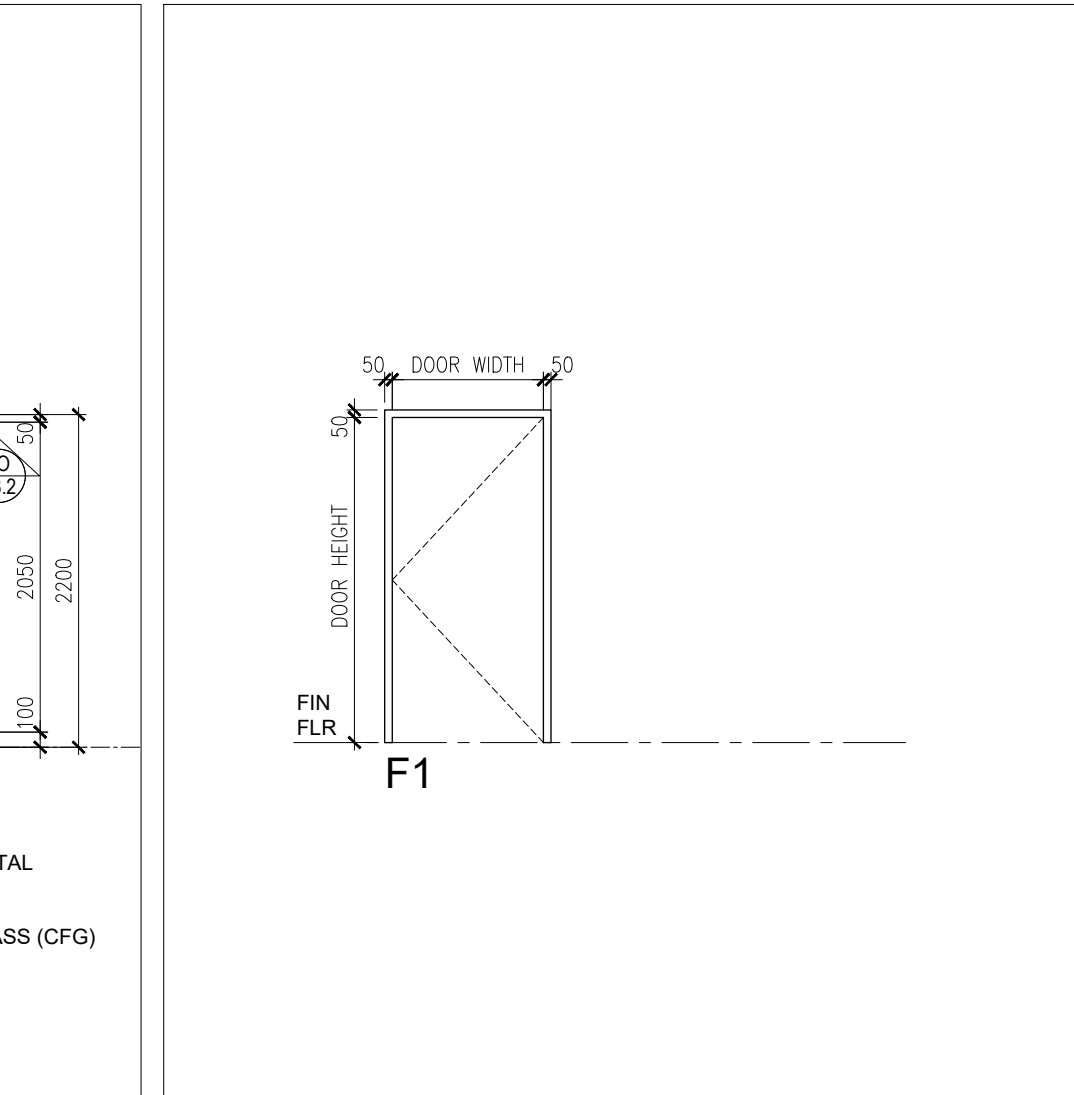

3 DOOR FRAME TYPE ELEVATION A8.1 1:50

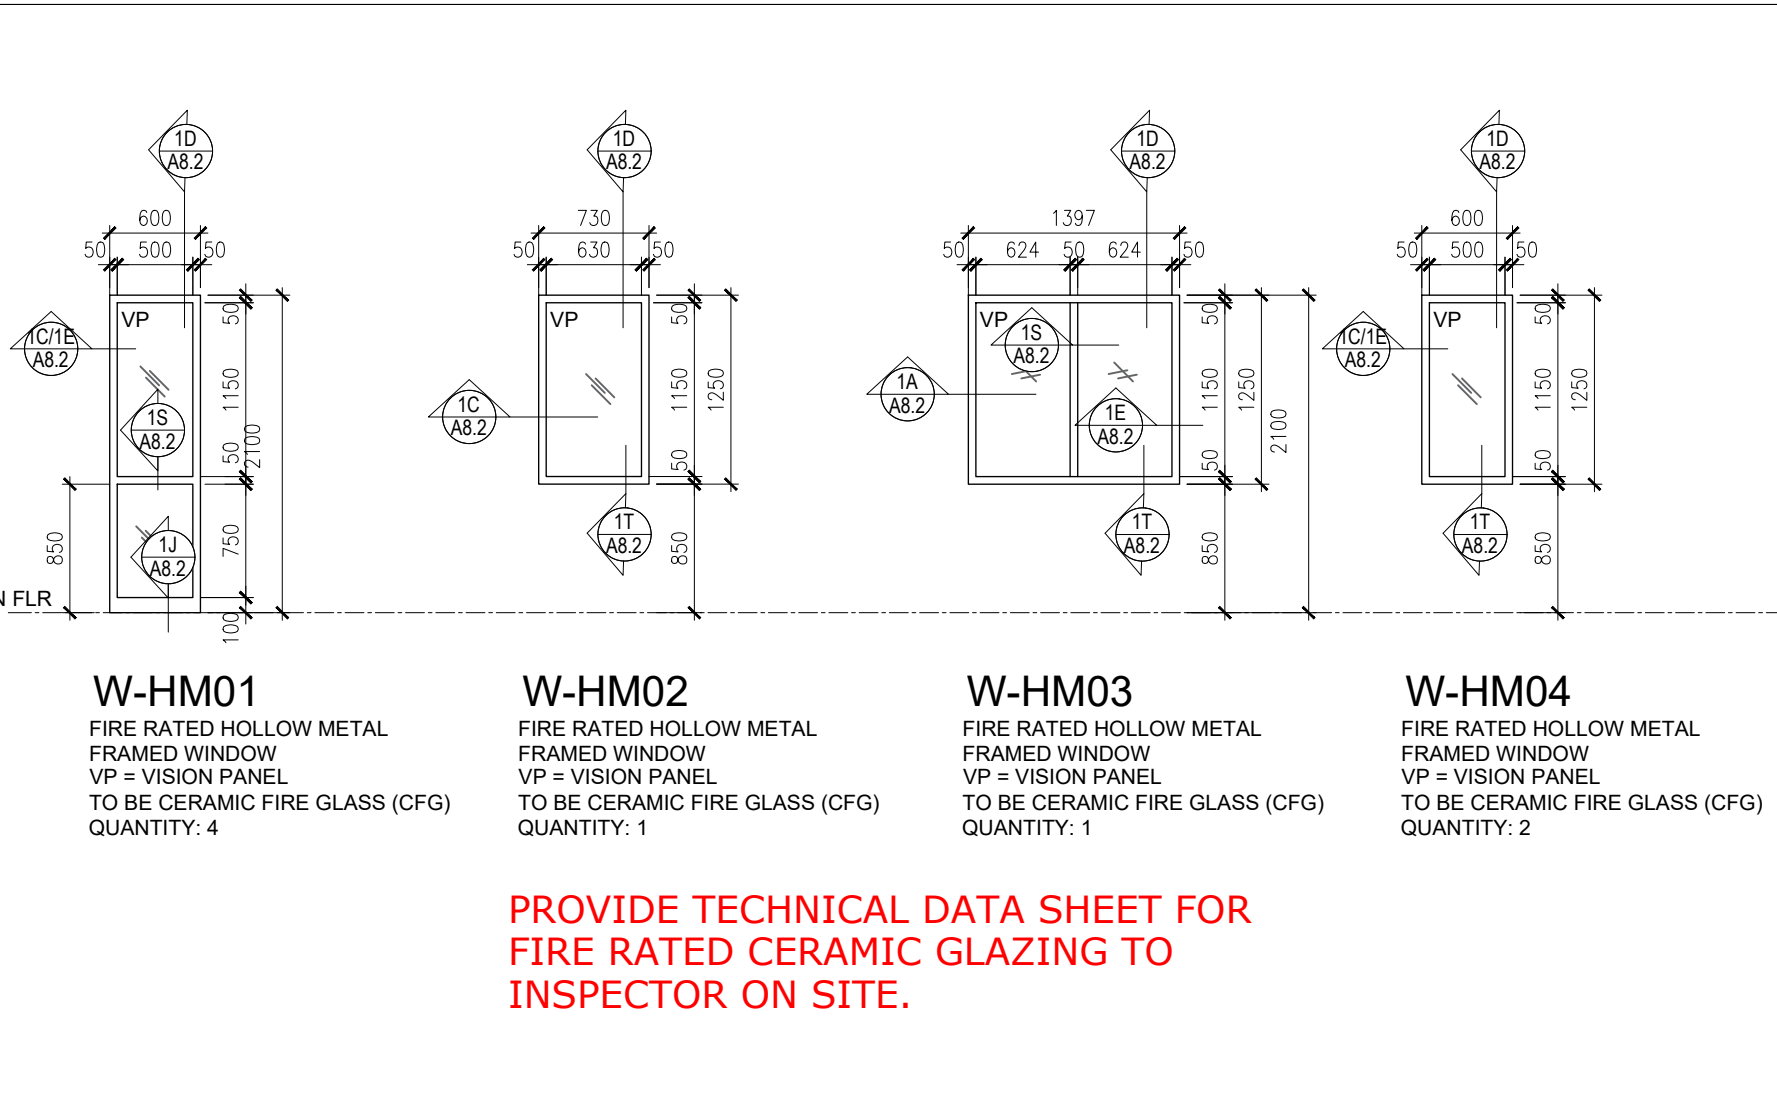

2 HOLLOW METAL WINDOW TYPES A8.1 1:50

ROOM FINISH SCHEDULE

No.	NAME	FLOOR MAT.	FIN.	BASE MAT.	WALLS NORTH MAT.	EAST MAT.	SOUTH MAT.	WEST MAT.	CEILING MAT.	FIN.	HEIGHT	REMARKS
F1	FOYER	EX CONC	EX TERR	EX POR/ POR	GB/CMU/ EX CMU	CWT/ PNT	GB	PNT	EX CMU	-	2413/ 2350	PROVIDE PAINT FINISH ON HOLLOW METAL DOORS AND FRAMES. PROVIDE NEW CERAMIC WALL TILE FINISH AT NEW GYPSUM BOARD FINISHED PARTITION WALL AND PAINT FINISH AT NEW GYPSUM BOARD FINISHED BULKHEAD. REFER TO INTERIOR ELEVATIONS ON DRAWING 5/A6.2 AND PROPOSED REFLECTED CEILING PLAN 4/A6.1 FOR SIZE AND SHAPE OF NEW GYPSUM BOARD BULKHEAD. PROVIDE NEW PORCELAIN WALL BASE AT FULL EXTENT OF NEW PARTITIONS AND AT NORTH CORRIDOR WALLS.
F2	PRINCIPAL'S OFFICE	EX CONC	RFL	RB 100	GB	PNT	EX CMU	PNT	EX CMU/ GB	PNT	2800	PROVIDE RESILIENT SHEET FLOORING AND RUBBER WALL BASE. PROVIDE PAINT FINISH AT ALL WALLS AND HOLLOW METAL DOORS AND FRAMES. REFER TO INTERIOR ELEVATIONS ON DRAWING 9/A6.1.
F3	OSR	EX CONC/ CONC	RFL	RB 100	GB	PNT	GB	PNT	GB	PNT	2440	PROVIDE RESILIENT SHEET FLOORING AND RUBBER WALL BASE. PROVIDE PAINT FINISH AT ALL WALLS AND HOLLOW METAL DOORS AND FRAMES. REFER TO INTERIOR ELEVATIONS ON DRAWING 8/A6.1.
F4	MAIN OFFICE	EX CONC/ CONC	RFL	RB 100	GB	PNT	GB	PNT	GB	PNT	2440/ 2350	PROVIDE RESILIENT SHEET FLOORING FINISHES. PROVIDE PAINT FINISH AT ALL WALLS, GYPSUM BOARD FINISHED BULKHEAD AND CEILING. HOLLOW METAL DOOR AND FRAME. REFER TO INTERIOR ELEVATIONS ON DRAWING 6/A6.1.
F5	WORKROOM	EX CONC/ CONC	RFL	RB 100	GB	PNT	GB	PNT	EX CMU/ CMU	PNT	2440	PROVIDE RESILIENT SHEET FLOORING AND RUBBER WALL BASE. PROVIDE PAINT FINISH AT ALL WALLS AND HOLLOW METAL DOORS AND FRAMES. REFER TO INTERIOR ELEVATIONS ON DRAWING 4/A6.2.
F6	WORKROOM	EX CONC/ CONC	RFL	RB 100	EX CMU	PNT	GB	PNT	GB	PNT	2800	PROVIDE RESILIENT SHEET FLOORING AND RUBBER WALL BASE. PROVIDE PAINT FINISH AT ALL WALLS AND HOLLOW METAL DOORS AND FRAMES. REFER TO INTERIOR ELEVATIONS ON DRAWING 3/A6.2.
F7	SEMINAR ROOM	EX CONC/ CONC	RFL	RB 100	GB	PNT	EX CMU	PNT	GB	PNT	2800	PROVIDE RESILIENT SHEET FLOORING AND RUBBER WALL BASE. PROVIDE PAINT FINISH AT ALL WALLS AND HOLLOW METAL DOORS AND FRAMES. REFER TO INTERIOR ELEVATIONS ON DRAWING 2/A6.2.
F8	STAFF LOUNGE	EX CONC/ CONC	RFL	RB 100	GB	PNT	GB	PNT	GB	PNT	2200/ 2800	PROVIDE RESILIENT SHEET FLOORING AND RUBBER WALL BASE. PROVIDE PAINT FINISH AT ALL WALLS AND HOLLOW METAL DOORS AND FRAMES. REFER TO INTERIOR ELEVATIONS ON DRAWING 1/A6.2.
F9	BARRIER FREE WASHROOM	EX CONC/ CONC	POR	POR	GB	CWT	GB	CWT	EX CMU/ CMU	CWT	2440	PROVIDE PORCELAIN FLOOR TILE AND BASE. PROVIDE PAINT FINISH AT HOLLOW METAL DOOR AND FRAMES. PROVIDE CERAMIC WALL TILE AT ALL WALLS. REFER TO INTERIOR ELEVATIONS ON DRAWING 5/A6.1 FOR LAYOUT OF CWT.
F10	WASHROOM	EX CONC/ CONC	POR	POR	GB	CWT	CMU	CWT	GB	CWT	2440	PROVIDE PORCELAIN FLOOR TILE AND BASE. PROVIDE PAINT FINISH AT HOLLOW METAL DOOR AND FRAME. PROVIDE CERAMIC WALL TILE AT ALL WALLS. REFER TO INTERIOR ELEVATIONS ON DRAWING 4/A6.1 FOR LAYOUT OF CWT.
F11	WASHROOM	EX CONC/ CONC	POR	POR	GB	CWT	CMU/ EX CMU	CWT	GB	CWT	2440	PROVIDE PORCELAIN FLOOR TILE AND BASE. PROVIDE PAINT FINISH AT HOLLOW METAL DOOR AND FRAME. PROVIDE CERAMIC WALL TILE AT ALL WALLS. REFER TO INTERIOR ELEVATIONS ON DRAWING 4/A6.1 FOR LOCATION OF TILES.
F16	LIBRARY	EX CONC	EX RFL	EX RB/ RB 100	EX CMU	-	EX CMU/ GB	-	EX CMU/ CMU/ GB	PNT	2700	REMOVE AND REINSTALL EXISTING ACOUSTIC CEILING TILE ASSEMBLY AS REQUIRED TO COMPLETE THE WORK. REMOVE EXISTING RUBBER WALL BASE AS REQUIRED TO COMPLETE THE WORK ON THE NORTH AND EAST WALLS. INSTALL NEW RUBBER WALL RB 100 TO MATCH EXISTING WALL BASE. INSTALL NEW RUBBER WALL BASE AT BASE OF RELOCATED MILLWORK SHELVING UNITS, AT NEW PARTITIONS AND AT EXISTING NEW WALL TO CORRIDOR.

8 ROOM FINISHES SCHEDULE A8.1 N.T.S.



GENERAL ROOM FINISHES NOTES

- WHERE NEW FLOOR FINISHES ARE INDICATED TO BE INSTALLED, EXISTING GROUT, MASTICS AND ADHESIVES ARE TO BE REMOVED FROM THE EXISTING CONCRETE FLOOR AND THE CONCRETE FLOOR SLAB IS TO BE CLEANED AND MADE GOOD IN PREPARATION FOR THE INSTALLATION OF NEW FINISHES. GRIND EXISTING CONCRETE FLOOR AS REQUIRED.
- WHERE NEW WALL BASE IS INDICATED TO BE INSTALLED, EXISTING MASTICS AND ADHESIVES ARE TO BE REMOVED FROM THE EXISTING CONCRETE WALLS AND BASE. SURFACES ARE TO BE CLEANED AND MADE GOOD IN PREPARATION FOR THE INSTALLATION OF NEW FINISHES.
- MAKE GOOD EXISTING CONCRETE FLOOR PRIOR TO INSTALLING NEW PARTITIONS. WHERE EXISTING WALLS ARE DEMOLISHED, MAKE GOOD EXISTING CONCRETE FLOOR IN PREPARATION FOR THE INSTALLATION OF NEW FLOOR FINISHES. INSTALL NEW PARTITIONS ON CONCRETE FLOOR SLAB.
- CLEAN, REPAIR AND MAKE GOOD ALL WALLS AFTER THE REMOVAL OF EXISTING WALL FINISHES, FLOOR BASE AND ALL ASSOCIATED WALL FRAMING, IN PREPARATION FOR NEW WALL FINISH.
- PAINT ALL EXPOSED NEW AND EXISTING ELECTRICAL CONDUITS AND PIPING.
- PROVIDE FLOOR TRANSITION STRIPS BETWEEN DISSIMILAR FLOORING FINISHES. REFER TO SPECIFICATIONS FOR TYPE.
- REFER TO INTERIOR ELEVATION DRAWINGS ON A6.1 AND A6.2 AND MILLWORK DRAWINGS A7.1 TO A7.4 FOR ADDITIONAL NOTES AND DESCRIPTIONS.
- PAINT ALL NEW HOLLOW METAL DOORS AND FRAMES ON BOTH SIDES.
- REFER TO ELECTRICAL DRAWINGS FOR WALL AND CEILING MOUNTED FIXTURES AND FITMENTS.
- CERAMIC WALL TILE (CWT) IS TO BE INSTALLED FROM TOP OF PORCELAIN BASE TO UNDERSIDE OF FINISHED CEILING. REFER TO FLOOR FINISH DRAWING AND INTERIOR ELEVATIONS FOR LOCATIONS.
- SITE VERIFY ALL EXISTING CONDITIONS AND SERVICES PRIOR TO INSTALLATIONS OF NEW FINISHES.
- SITE VERIFY ALL UNDERGROUND SERVICES PRIOR TO CUTTING AND INSTALLATION. REFER TO FLOOR PLANS AND MECHANICAL DRAWINGS FOR APPROXIMATE LOCATIONS.
- REFER TO ROOM FINISH SCHEDULE DRAWING A8.1 FOR GENERAL ROOM FINISH SCHEDULE NOTES AND ROOM FINISH SCHEDULE.
- LOOSE FURNITURE, CHAIRS, AND TABLES ARE NOT IN CONTRACT AND ARE SUPPLIED AND INSTALLED BY THE OWNER, UNLESS OTHERWISE NOTED IN THE DRAWINGS AND SPECIFICATIONS.
- SUPPLY AND INSTALL NEW WINDOW SHADES AT EXISTING WINDOWS IN PRINCIPAL'S OFFICE F2, SEMINAR ROOM F7 AND WORK ROOM F6 AND AT NEW WINDOW IN STAFF LOUNGE F8 AND AT ALL WINDOWS AND SCREENS IN MAIN OFFICE F4 AND STAFF LOUNGE F8. SITE VERIFY EXISTING WINDOWS TO REMAIN.
- REPAIR EXISTING TERRAZZO FLOORING IN FOYER F1 AS REQUIRED WHERE WALLS WERE DEMOLISHED AND PROVIDE MATCHING TERRAZZO FLOORING TO SUIT.

LIST OF ACRONYMS - FINISHES PLAN AND SCHEDULE

ACT-N = NEW ACOUSTIC CEILING TILE AND T-BAR GRID SYSTEM.
EX ACT = EXISTING ACOUSTIC CEILING TILE AND T-BAR GRID SYSTEM TO REMAIN.
CWT = NEW CERAMIC WALL TILE. REFER TO INTERIOR ELEVATIONS FOR EXTENT OF WALL TILE SIZE, TYPE AND LAYOUT.
CG = NEW CORNER GUARD ADHERED TO GYPSUM BOARD PARTITION CORNER.
PNT = PAINT FINISH.
POR = NEW PORCELAIN FLOOR AND TILE AND BASE TILE.
EX POR = EXISTING PORCELAIN FLOOR TILE TO REMAIN.
RFL = NEW RESILIENT FLOORING TILE.
EX RFL = EXISTING RESILIENT SHEET FLOORING TO REMAIN.
RB100 = NEW 100mm HIGH RUBBER WALL BASE.
EX RB = EXISTING 100mm HIGH RUBBER WALL BASE TO REMAIN.
GB = NEW GYPSUM BOARD FINISHED WALL.
CMU = NEW CONCRETE MASONRY WALL.
EX CMU = EXISTING CONCRETE MASONRY WALL.
EX GBD = EXISTING GYPSUM BOARD FINISH CEILING ASSEMBLY.
GBD-N = NEW GYPSUM BOARD FINISHED CEILING ASSEMBLY.
EX CONC = EXISTING CONCRETE SLAB-ON-GRADE FLOOR TO REMAIN.
CONC-N = NEW CONCRETE SLAB-ON-GRADE FLOOR.
EX TERR = EXISTING TERRAZZO FLOORING TO REMAIN.
RCP = REFER TO REFLECTED CEILING PLAN ON A2.1.

FLOOR FINISHES PLAN NOTES AND LEGEND

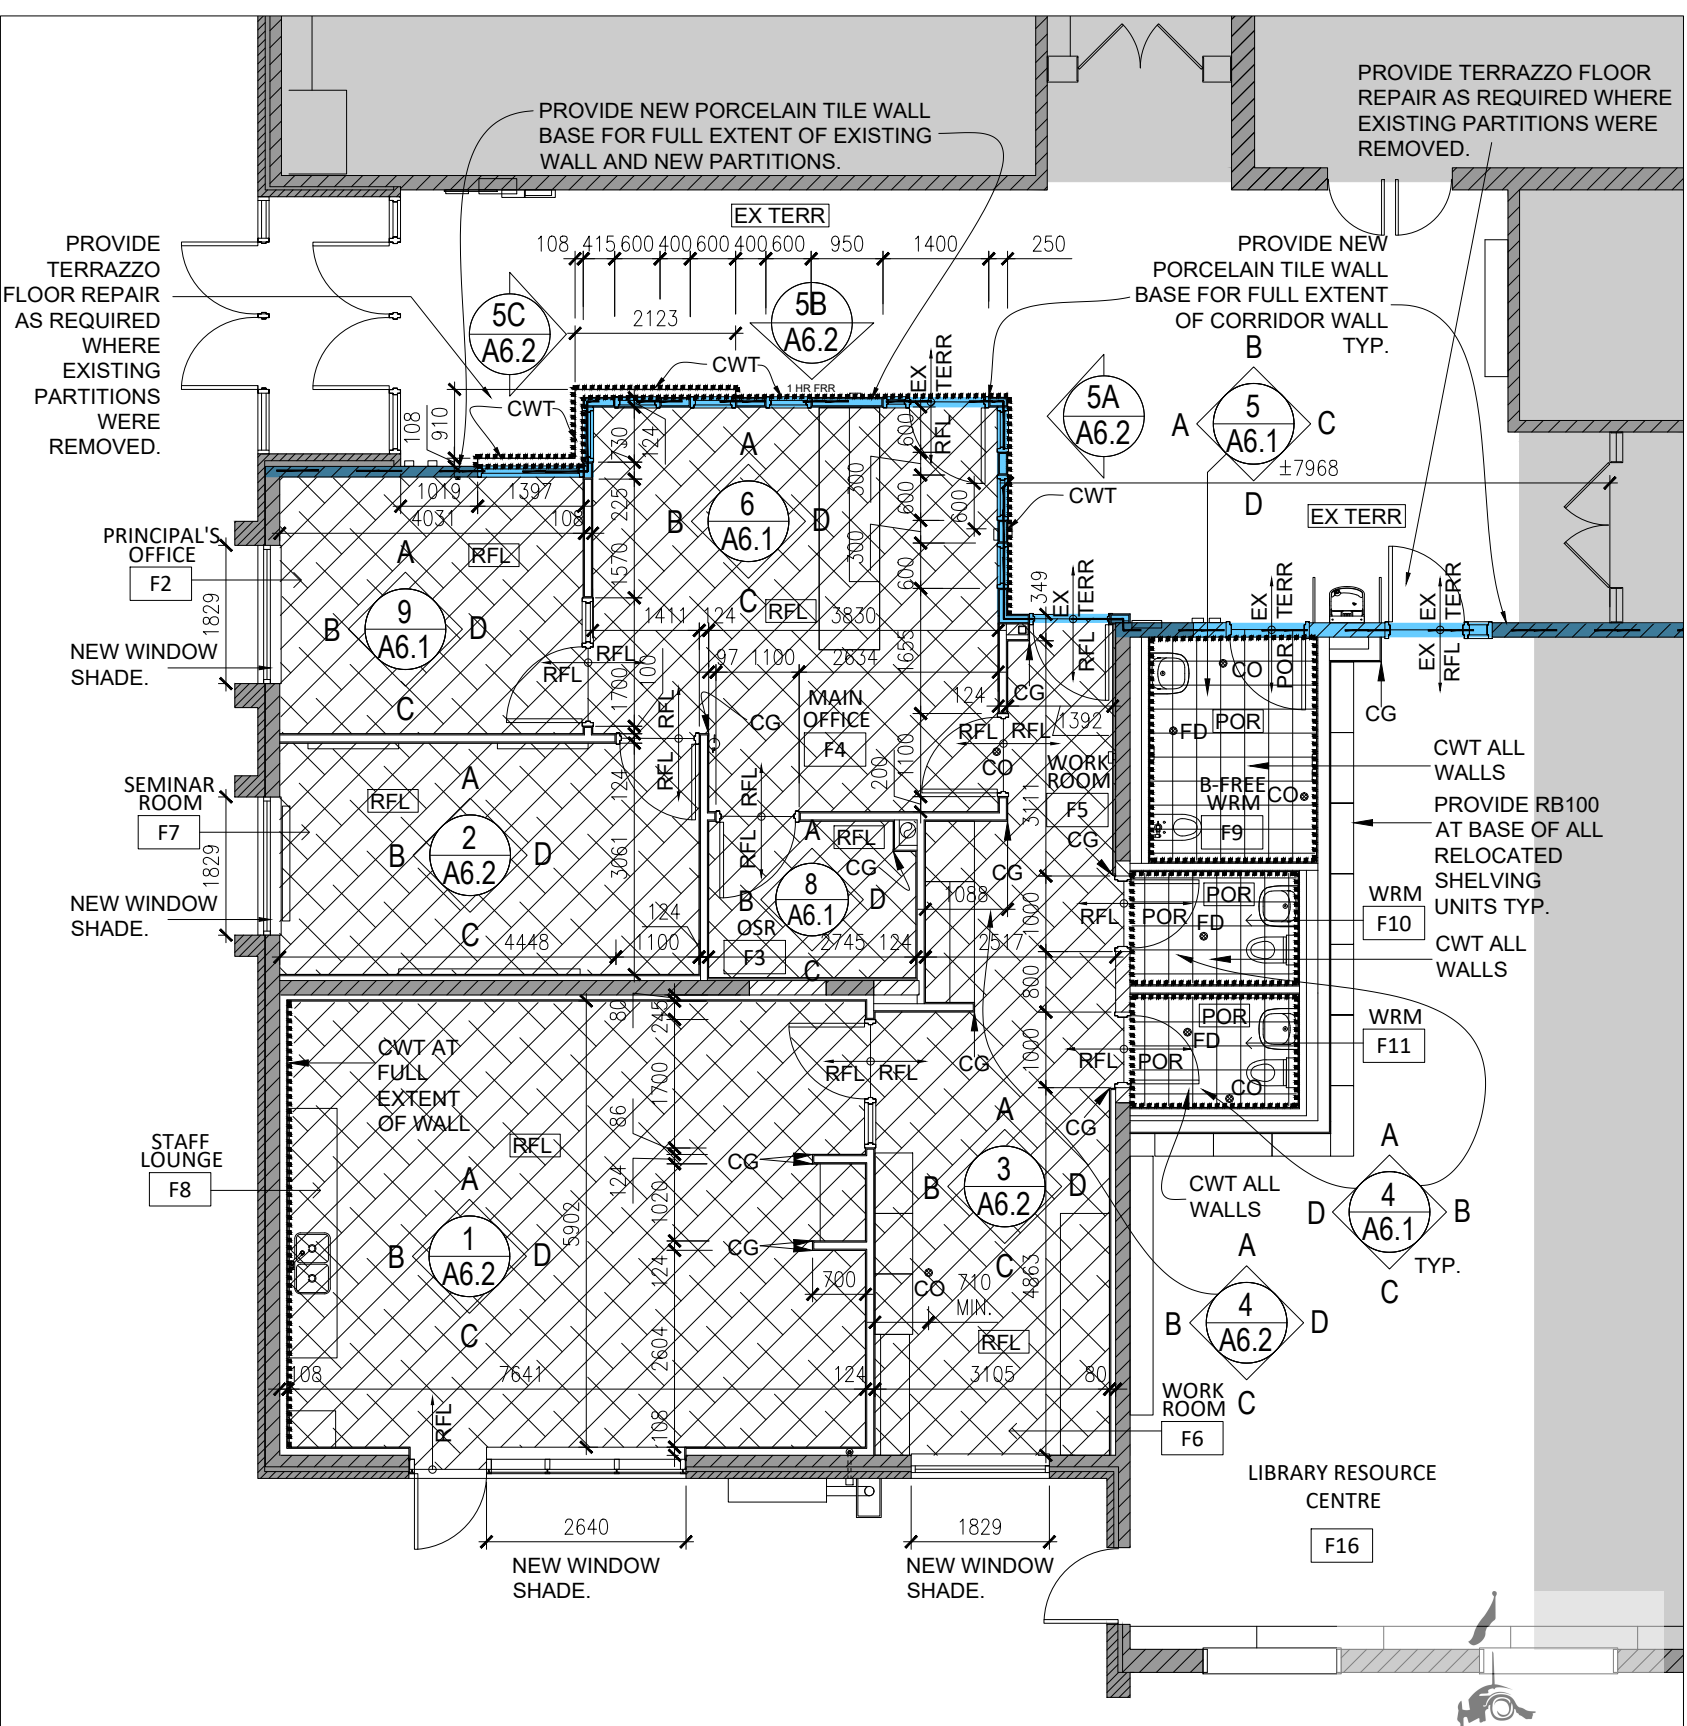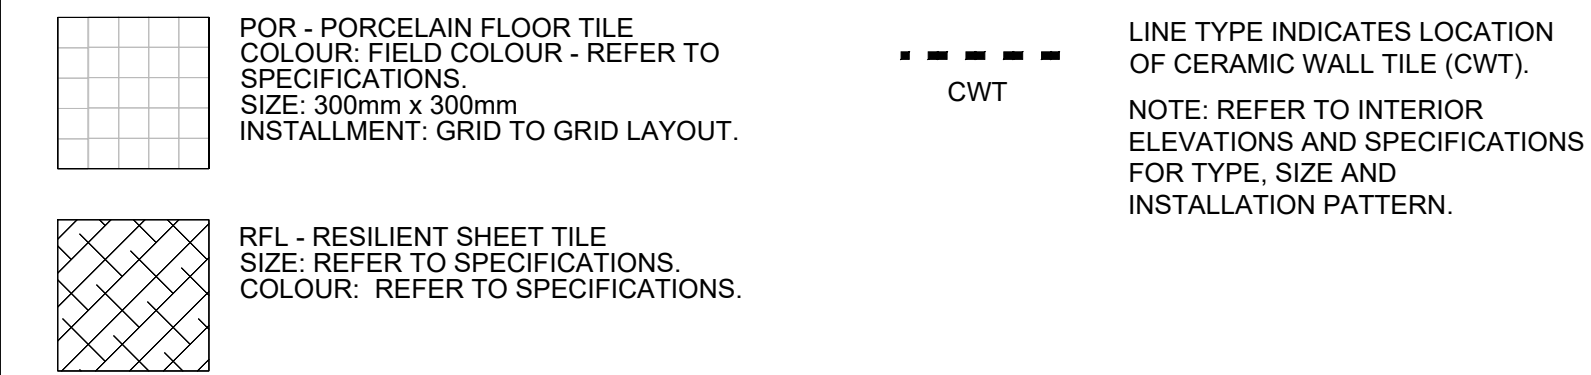

1 PROPOSED GROUND FLOOR FINISHES AND FITMENTS A8.1 1:100

NOTE: THIS DRAWING IS NOT TO BE SCALED. THE CONTRACTOR IS RESPONSIBLE FOR THE VERIFICATION OF ALL SITE CONDITIONS AND SITE MEASUREMENTS THAT ARE NOT CONSISTENT WITH THE DRAWINGS.

no.	revision	date
1.	Issued for Owner Review	Nov. 19, 2025
2.	Issued for Owner Review	Nov. 19, 2025
3.	Issued for Permit and Tender	April 17, 2026

no.	issue	date
1.	Issued for Owner Review	Nov. 19, 2025
2.	Issued for Owner Review	Nov. 19, 2025
3.	Issued for Permit and Tender	April 17, 2026

project
TRILLIUM JUNIOR PUBLIC SCHOOL INTERIOR RENOVATIONS
WATERLOO REGION DISTRICT SCHOOL BOARD

79 Laurentian Dr, Kitchener, ON N2E 1C3
drawing
DOOR & HARDWARE SCHEDULE, DOOR, FRAME, SCREEN & WINDOW ELEVATION TYPE AND DOOR DETAILS
drawing scale

AS NOTED
ward99 project number
25022 - WRDSB TRILLIUM PS

ward99 architects
drawing no.
A8.1

ward99 architects inc.
7011 Pine Valley Dr. Unit 11,
Woodbridge ON L4L 0A2
info@ward99architects.com
416 673 5880 www.ward99architects.com

Diagram illustrating a section of a fire-rated door assembly. The assembly includes a fire-rated hollow metal frame filled with mortar, a vision panel to ceramic fire glass (FG), and an existing 1HR fire-rated concrete masonry interior partition wall. The door is shown with a continuous sealant and back rod on both sides. Masonry anchor straps are shown connecting the door frame to the existing masonry partition wall. Dimensions are provided for the door height (149), vision panel height (49), and door thickness (50).

Labels and dimensions:

- FIRE RATED HOLLOW METAL FRAME FILLED WITH MORTAR.
- EXISTING 1HR FIRE RATED CONCRETE MASONRY INTERIOR PARTITION WALL.
- VISION PANEL TO CERAMIC FIRE GLASS (FG). REFER TO DOOR SCHEDULE ON DRAWING AS 1.
- MASONRY ANCHOR STRAPS TO EXISTING MASONRY PARTITION.
- CONTINUOUS SEALANT AND BACK ROD ON BOTH SIDES (TYP.)
- Dimensions: 149, 49, 50, 40, 140.

FIRE-RATED HOLLOW METAL FRAME PACKED WITH INSULATION.

FIRE-RATED GYPSUM BOARD WALL ASSEMBLY. REFER TO CONSTRUCTION.

VISION PANEL TO CERAMIC FIRE GLASS (CFG). REFER TO DOOR SCHEDULE ON DRAWING A6.1.

PROVIDE DOUBLE STUDS TYP.

CONTINUOUS SEALANT AND BACK ROD ON BOTH SIDES (TYP)

Dimensions shown:

- Vertical dimensions on the left: 40, 60, 40
- Horizontal dimension at the top: 50
- Horizontal dimension on the right: 174

1'-4 1/2"

40"

13"

50"

VISION PANEL TO CERAMIC FIRE GLASS (CFG). REFER TO DOOR SCHEDULE ON DRAWING A6.1.

FIRE-RATED HOLLOW METAL FRAME PACKED WITH INSULATION.

CONTINUOUS SEALANT AND BACK ROD ON BOTH SIDES (TYP.)

PROVIDE WOOD BLOCK REQUIRED AS PER MANUFACTURER RECOMMENDATIONS.

FIRE-RATED GYPSUM WALL ASSEMBLY. REFER CONSTRUCTION.

(PT)

Technical drawing of a door assembly showing dimensions and material specifications. The drawing includes a cross-section of the door frame and a side view of the door panel. Dimensions are provided in millimeters (mm).

Dimensions:

- Overall height: 149 mm
- Overall width: 149 mm
- Top frame thickness: 49 mm
- Bottom frame thickness: 49 mm
- Side frame thickness: 49 mm
- Door panel thickness: 49 mm
- Door panel width: 50 mm
- Door panel height: 50 mm
- Door panel depth: 49 mm

Material Specifications:

- FIRE RATED HOLLOW METAL FRAME FILLED WITH MORTAR.** (Indicated by a callout pointing to the top frame section)
- VISION PANEL TO CERAMIC FIRE GLASS (CFG), REFER TO DOOR SCHEDULE ON DRAWING A8.1.** (Indicated by a callout pointing to the door panel)
- FIRE RATED HOLLOW METAL DOOR, REFER TO DOOR SCHEDULE ON DRAWING A8.1 FOR TYPE OF DOOR.** (Indicated by a callout pointing to the door panel)

Diagram illustrating the cross-section of a fire-rated door assembly. The diagram shows the door leaf, frame, and surrounding wall structure. Key components and dimensions are labeled:

- Dimensions:**
 - Overall height: 149
 - Top section height: 40
 - Door leaf height: 60
 - Bottom section height: 49
 - Door leaf width: 50
 - Frame width: 16
 - Wall thickness: 174
- Components and Labels:**
 - FIRE-RATED HOLLOW METAL FRAME PACKED WITH INSULATION.** (Pointing to the frame area)
 - CONTINUOUS SEALANT AND BACK ROD ON BOTH SIDES (TYP.)** (Pointing to the sealant/rod at the top)
 - PROVIDE DOUBLE STUDS TYP.** (Pointing to the wall studs)
 - FIRE-RATED HOLLOW METAL DOOR. REFER TO DOOR SCHEDULE ON DRAWING A8.1 FOR TYPE OF DOOR.** (Pointing to the door leaf)
 - FIRE-RATED GYPSUM BOARD WALL ASSEMBLY. REFER TO CONSTRUCTION.** (Pointing to the wall assembly)

B. FIRE-RATED WINDOW SILL

VISION PANEL TO CERAMIC FIRE GLASS (CFG). REFER TO DOOR SCHEDULE ON DRAWING AS-1.

FIRE RATED HOLLOW METAL FRAME FILLED WITH MORTAR

CONTINUOUS SEALANT AND BACK ROD ON BOTH SIDES (TYP.)

MASONRY ANCHOR CLIP.

1HR FIRE RATED CONCRETE MASONRY UNIT. FILL CORES SOLID WITH GROUT.

Dimensions: 143, 49, 60, 40, 51, 50, 140, 16

D. FIRE-RATED SCREEN WINDOW HEAD

- FIRE-RATED GYPSUM BOARD WALL ASSEMBLY. REFER TO CONSTRUCTION.
- PROVIDE DOUBLE STUDS TYP.
- CONTINUOUS SEALANT AND BACK ROD ON BOTH SIDES (TYP.).
- FIRE-RATED HOLLOW METAL FRAME PACKED WITH INSULATION.
- VISION PANEL TO CERAMIC FIRE GLASS (CFG). REFER TO DOOR SCHEDULE ON DRAWING A8.1.

Dimensions: 124 (width), 19 (height), 149 (depth). Internal depth segments: 49, 60, 40.

F. FIRE-RATED DOOR HEAD WITH PDO

Technical drawing showing a cross-section of a fire-rated door head assembly. The drawing includes dimensions and callouts for various components.

Dimensions:

- Top width: 24
- Bottom width: 49, 60, 40
- Bottom total width: 149
- Vertical dimensions on the right: 12, 50, 133

Callouts and Notes:

- FIRE-RATED GYPSUM BOARD WALL ASSEMBLY. REFER TO CONSTRUCTION.
- PROVIDE DOUBLE STUDS TYP.
- CONTINUOUS SEALANT AND BACK ROD ON BOTH SIDES (TYP.)
- FIRE-RATED HOLLOW METAL FRAME PACKED WITH INSULATION.
- FIRE RATED HOLLOW METAL DOOR. REFER TO DOOR SCHEDULE ON DRAWING A8.1 FOR TYPE OF DOOR.

Diagram illustrating the fire-rated door sill assembly. The total width of the sill is 149. The dimensions are divided into three sections: 40, 60, and 49. The assembly includes a fire-rated hollow metal door, a floor anchor clip, and a sill plate. The door is labeled "FIRE RATED HOLLOW METAL DOOR. REFER TO DOOR SCHEDULE ON DRAWING A8.1 FOR TYPE OF DOOR." The floor anchor clip is labeled "FLOOR ANCHOR CLIP BEYOND AT BOTH JAMBS."

[illegible]

K. FIRE-RATED DOOR HEAD

1HR FIRE RATED CONCRETE MASS INTERIOR PARTITION WALL. REFER TO CONSTRUCTION ASSEMBLY.

STEEL BEAM UNTIL REFER TO STRUCTURAL DRAWINGS.

CONTINUOUS SEALANT AND BACK ROD ON BOTH SIDES (TYP.)

FIRE RATED HOLLOW METAL FRAME FILLED WITH MORTAR.

FIRE-RATED DOOR. REFER TO DOOR SCHEDULE ON DRAWING A8.1 FOR TYPE OF DOOR.

Dimensions: 189, 135, 224, 40, 49, 50, 17, 0, 17, 0.

L FIRE-RATED DOOR HEAD WITH PDO

- 1HR FIRE RATED CONCRETE MASONRY INTERIOR PARTITION WALL. REFER TO CONSTRUCTION ASSEMBLY.
- STEEL BEAM Lintel REFER TO STRUCTURAL DRAWINGS
- SURFACE MOUNTED AUTOMATIC POWER DOOR OPERATOR SECURED ABOVE DOOR HEADER LOCATION. REFER TO ELECTRICAL DRAWINGS.
- CONTINUOUS SEALANT AND BACK ROD ON BOTH SIDES (TYP.)
- FIRE RATED HOLLOW METAL FRAME FILLED WITH MORTAR
- FIRE RATED DOOR. REFER TO DOOR SCHEDULE ON DRAWING A8.1 FOR TYPE OF DOOR.

Dimensions:

- Vertical dimensions: 0, 50, 75, 100, 125, 150, 175, 200, 225, 250, 275, 300, 325, 350, 375, 400, 425, 450, 475, 500, 525, 550, 575, 600, 625, 650, 675, 700, 725, 750, 775, 800, 825, 850, 875, 900, 925, 950, 975, 1000.
- Horizontal dimensions: 40, 135, 49, 224.

M. FIRE-RATED SCREEN HEAD

1HR FIRE RATED CONCRETE MASONRY INTERIOR PARTITION WALL. REFER TO CONSTRUCTION ASSEMBLY.

STEEL BEAM UNTEL REFER TO STRUCTURAL DRAWINGS.

CONTINUOUS SEALANT AND BACK ROD ON BOTH SIDES (TYP.)

FIRE RATED HOLLOW METAL FRAME FILLED WITH MORTAR.

VISION PANEL TO CERAMIC FIRE GLASS (CFG). REFER TO DOOR SCHEDULE ON DRAWING A8.1.

Dimensions: 40, 135, 49, 224, 50, 50, 17A

40

135

224

49

METAL FRAME FILLED WITH MORTAR.

MASONRY INTERIOR PARTITION WALL REFER TO CONSTRUCTION ASSEMBLY.

VISION PANEL TO CERAMIC FIRE GLASS (CFG), REFER TO DOOR SCHEDULE ON DRAWING AS.1.

CONTINUOUS SEALANT AND BACK ROD ON BOTH SIDES (TYP.)

MASONRY ANCHOR CLIP.

P19

40

135

49

274

FIRE RATED HOLLOW METAL FRAME FILLED WITH MORTAR.

1HR FIRE RATED CONCRETE MASONRY INTERIOR PARTITION WALL REFER TO CONSTRUCTION ASSEMBLY

FIRE RATED HOLLOW METAL DOOR REFER TO DOOR SCHEDULE ON DRAWING A8.1 FOR TYPE OF DOOR

CONTINUOUS SEAL/IT AND BACK RCG ON BOTH SIDES (TYP.)

MASONRY ANCHOR CLIP

EXISTING 1HR FIRE RATED CONCRETE MASONRY INTERIOR PARTITION WALL

Technical drawing of a fire-rated door assembly showing cross-sections and dimensions. The drawing includes the following labels and dimensions:

- Labels:**
 - FIRE RATED HOLLOW METAL FRAME FILLED WITH MORTAR.
 - FIRE RATED HOLLOW METAL DOOR. REFER TO DOOR SCHEDULE ON DRAWING A8.1 FOR TYPE OF DOOR.
 - VISION PANEL TO CERAMIC FIRE GLASS (FG). REFER TO DOOR SCHEDULE ON DRAWING A8.1.
- Dimensions:**
 - Overall height: 274
 - Top frame height: 40
 - Frame height (excluding top and bottom): 135
 - Bottom frame height: 40
 - Door height: 274
 - Top door height: 40
 - Door height (excluding top and bottom): 135
 - Bottom door height: 40
 - Top frame width: 19
 - Frame width (excluding top and bottom): 50
 - Bottom frame width: 19

Technical drawing of a door frame showing dimensions and components. The drawing includes a side view of the door and a cross-section of the frame. Dimensions are indicated in inches: 40, 135, and 49. The door is labeled 'FIRE RATED HOLLOW METAL DOOR. REFER TO DOOR SCHEDULE ON DRAWING A8.1 FOR TYPE OF DOOR.' The frame is labeled 'FLOOR ANCHOR CLIP BEYOND AT BOTH JAMBS.' The drawing also shows a 'DOOR STOP' and a 'DOOR HINGE'.

Diagram illustrating the fire-rated floor assembly with a fire-rated hollow metal sill. The assembly includes a fire-rated hollow metal sill, floor anchor clips, and a vision panel to be installed. The sill is secured to the floor assembly with floor anchor clips and filled with mortar. The assembly is shown with dimensions: 100mm for the sill height, 100mm for the concrete thickness, and 100mm for the mortar thickness. The sill is labeled "FIRE RATED HOLLOW METAL SILL" and "FLOOR ANCHOR CLIP". The concrete is labeled "CONCRETE" and the mortar is labeled "MORTAR". The assembly is shown with a "FINISHED FLOOR" on top and a "VISION PANEL TO BE" on the side.

FIRE RATED HOLLOW METAL FRAME FILLED WITH MORTAR.

VISION PANEL TO CERAMIC FIRE GLASS (CFG). REFER TO ROOF SCHEDULE ON DRAWING AB.1.

Dimensions: 19, 50, 19, 40, 40, 40, 40.

49 60 40

10

50

VISION PANEL TO CERAMIC FIRE GLASS (CFG) REFER TO DOOR SCHEDULE ON DRAWING A8.1.

FIRE-RATED HOLLOW METAL FRAME PACKED WITH INSULATION.

CONTINUOUS SEALANT AND BACK ROD ON BOTH SIDES (TYP.)

PROVIDE DOUBLE STUDS TYP.

FIRE-RATED GYPSUM BOARD WALL ASSEMBLY. REFER TO CONSTRUCTION.

GYPSUM BOARD FINISHED WALL ASSEMBLY. REFER TO CONSTRUCTION.

(R6)

(P7)

3 BULLNOSED CORNER BASE DETAIL AT MASONRY PARTITIONS
A8.2 1:25

A. SCREEN HEAD

- 124
- CYPRESS BOARD FINISHED WALL ASSEMBLY. REFER TO CONSTRUCTION.
- PROVIDE DOUBLE STUDS TYP.
- CONTINUOUS SEALANT AND BACK ROD ON BOTH SIDES (TYP.)
- HOLLOW METAL FRAME
- VISION PANEL TO TEMPERED GLASS (TGL). REFER TO DOOR SCHEDULE ON DRAWING A8.1.
- 49 60 40
- 149

B. DOOR HEAD

- 124
- CYPRESS BOARD FINISHED WALL ASSEMBLY. REFER TO CONSTRUCTION.
- PROVIDE DOUBLE STUDS TYP.
- CONTINUOUS SEALANT AND BACK ROD ON BOTH SIDES (TYP.)
- HOLLOW METAL FRAME
- REFER TO DOOR SCHEDULE ON DRAWING A8.1 FOR TYPE OF DOOR.
- 50 24
- 49 60 40
- 149

C. INTERMEDIATE MULLION

- HOLLOW METAL FRAME
- 19 50 19
- 149 40 60 49
- VISION PANEL TO TEMPERED GLASS (TGL). REFER TO DOOR SCHEDULE ON DRAWING A8.1.
- REFER TO DOOR SCHEDULE ON DRAWING A8.1 FOR TYPE OF DOOR.

Technical drawing of a window assembly showing a hollow metal frame and wall assembly. The drawing includes dimensions for the frame and wall, and labels for various components.

HOLLOW METAL FRAME

WALL ASSEMBLY. REFER TO CONSTRUCTION.

PROVIDE DOUBLE

VISION PANEL TO

19

50

10

149

49

60

40

124

(P2)

Technical drawing of a fire-rated door assembly, showing side and top views with dimensions and callouts.

Dimensions:

- Side View (Left):
 - Overall Height: 149
 - Top Section Height: 49
 - Bottom Section Height: 60
 - Bottom Section Height (Inset): 40
- Top View (Right):
 - Overall Width: 124
 - Inset Width: 50
 - Inset Height: 19

Callouts and Notes:

- HOLLOW METAL FRAME
- GYPSUM BOARD FINISHED WALL ASSEMBLY. REFER TO CONSTRUCTION.
- (P2)
- REFER TO DOOR SCHEDULE ON DRAWING A8.1 FOR TYPE OF FIRE RATED DOOR.
- PROVIDE DOUBLE STUDS TYP.
- CONTINUOUS SEALANT AND BACK ROD ON BOTH SIDES (TYP.)

CONCRETE MASONRY INTERIOR PARTITION WALL. REFER TO CONSTRUCTION ASSEMBLY.

STEEL BEAM LINTEL. REFER TO STRUCTURAL DRAWINGS.

CONTINUOUS SEALANT AND BACK ROD ON BOTH SIDES (TYP.)

HOLLOW METAL FRAME

HOLLOW METAL DOOR. REFER TO DOOR SCHEDULE ON DRAWINGS A8.1 FOR TYPE OF DOOR.

J. DOOR
HOLLOW

40
135
49
224

40
135
49
224

REFER TO
ON DRAW
TYPE.

Technical drawing showing a cross-section of a door and partition assembly. The drawing includes dimensions and labels for various components.

Dimensions:

- Overall height: 274
- Top section height: 46
- Middle section height: 153
- Bottom section height: 49
- Partition height: 190

Labels and Callouts:

- HOLLOW METAL FRAME
- PARTITION WILL REFER TO CONSTRUCTION ASSEMBLY.
- REFER TO DOOR SCHEDULE OR DRAWING A8.1 FOR DOOR TYPE.
- CONTINUOUS SEALANT AND BACK ROD ON BOTH SIDES (TYP.)
- MASONRY ANCHOR CLIP
- P1

[illegible]

project

TRILLIUM JUNIOR PUBLIC SCHOOL INTERIOR RENOVATIONS
WATERLOO REGION DISTRICT SCHOOL BOARD

79 Laurentian Dr, Kitchener, ON N2E 1C3

A8.2

2 HOLLOW METAL DOOR AND SCREEN DETAILS
8.2 1:5