

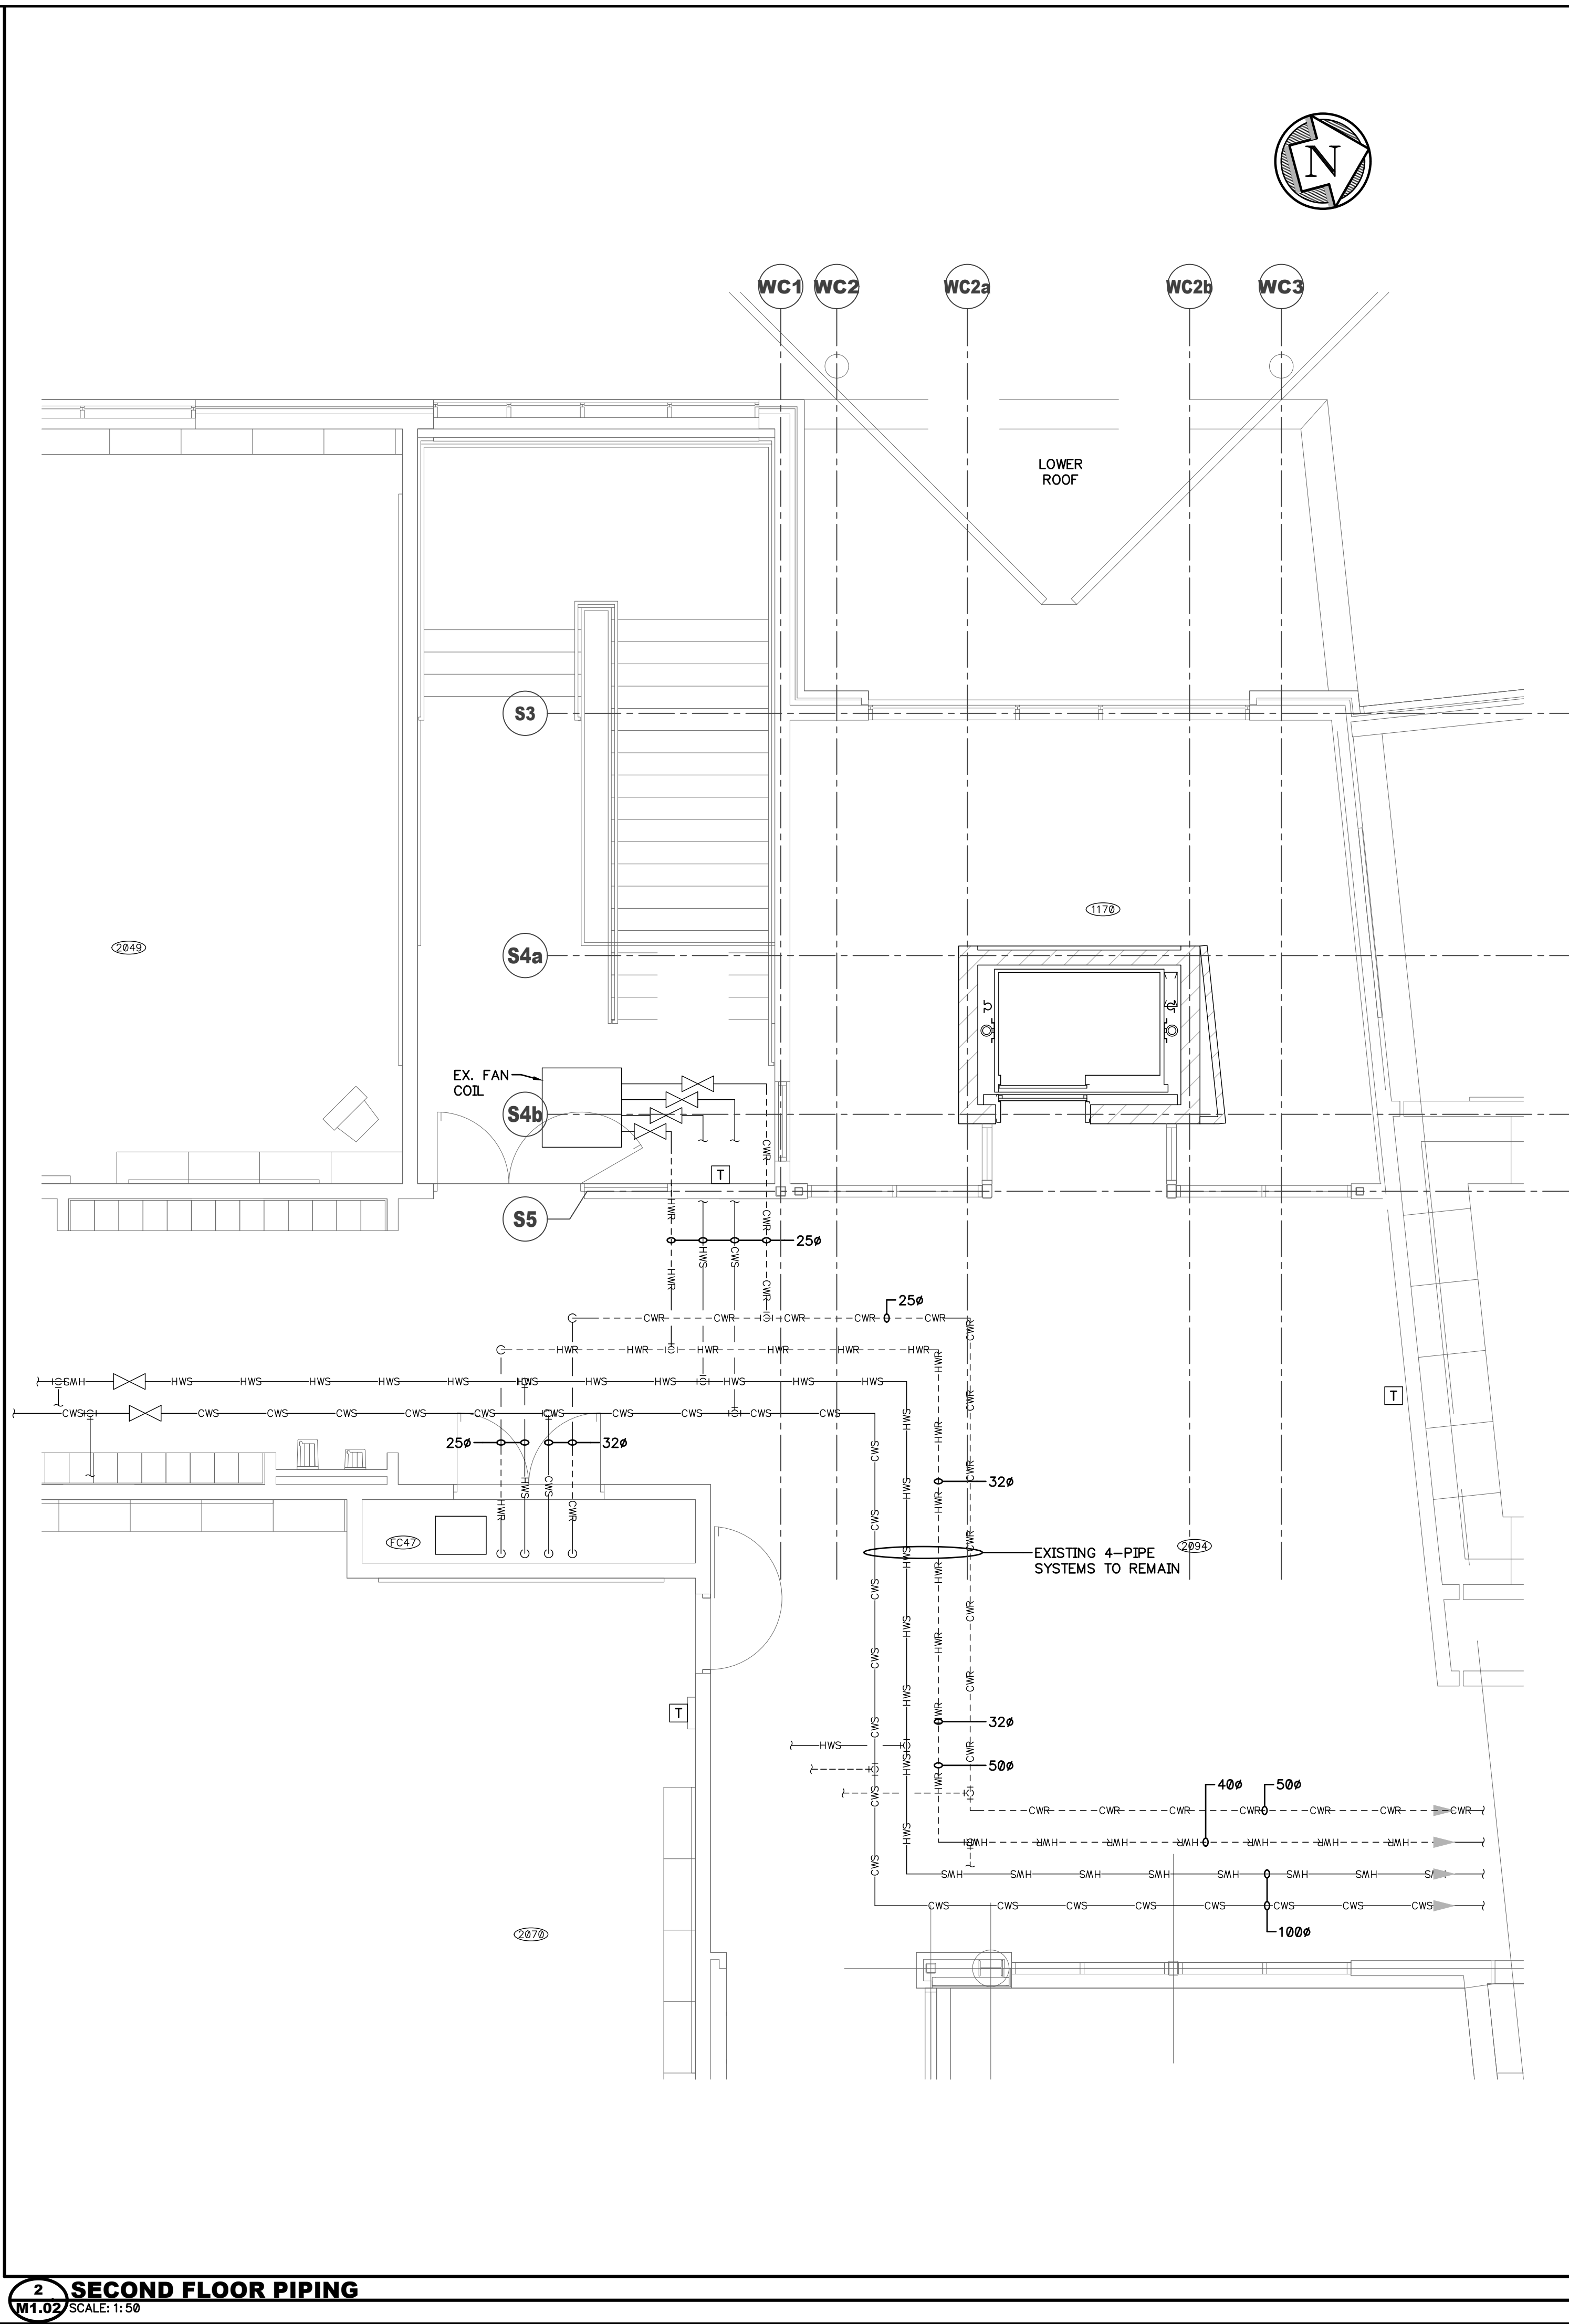
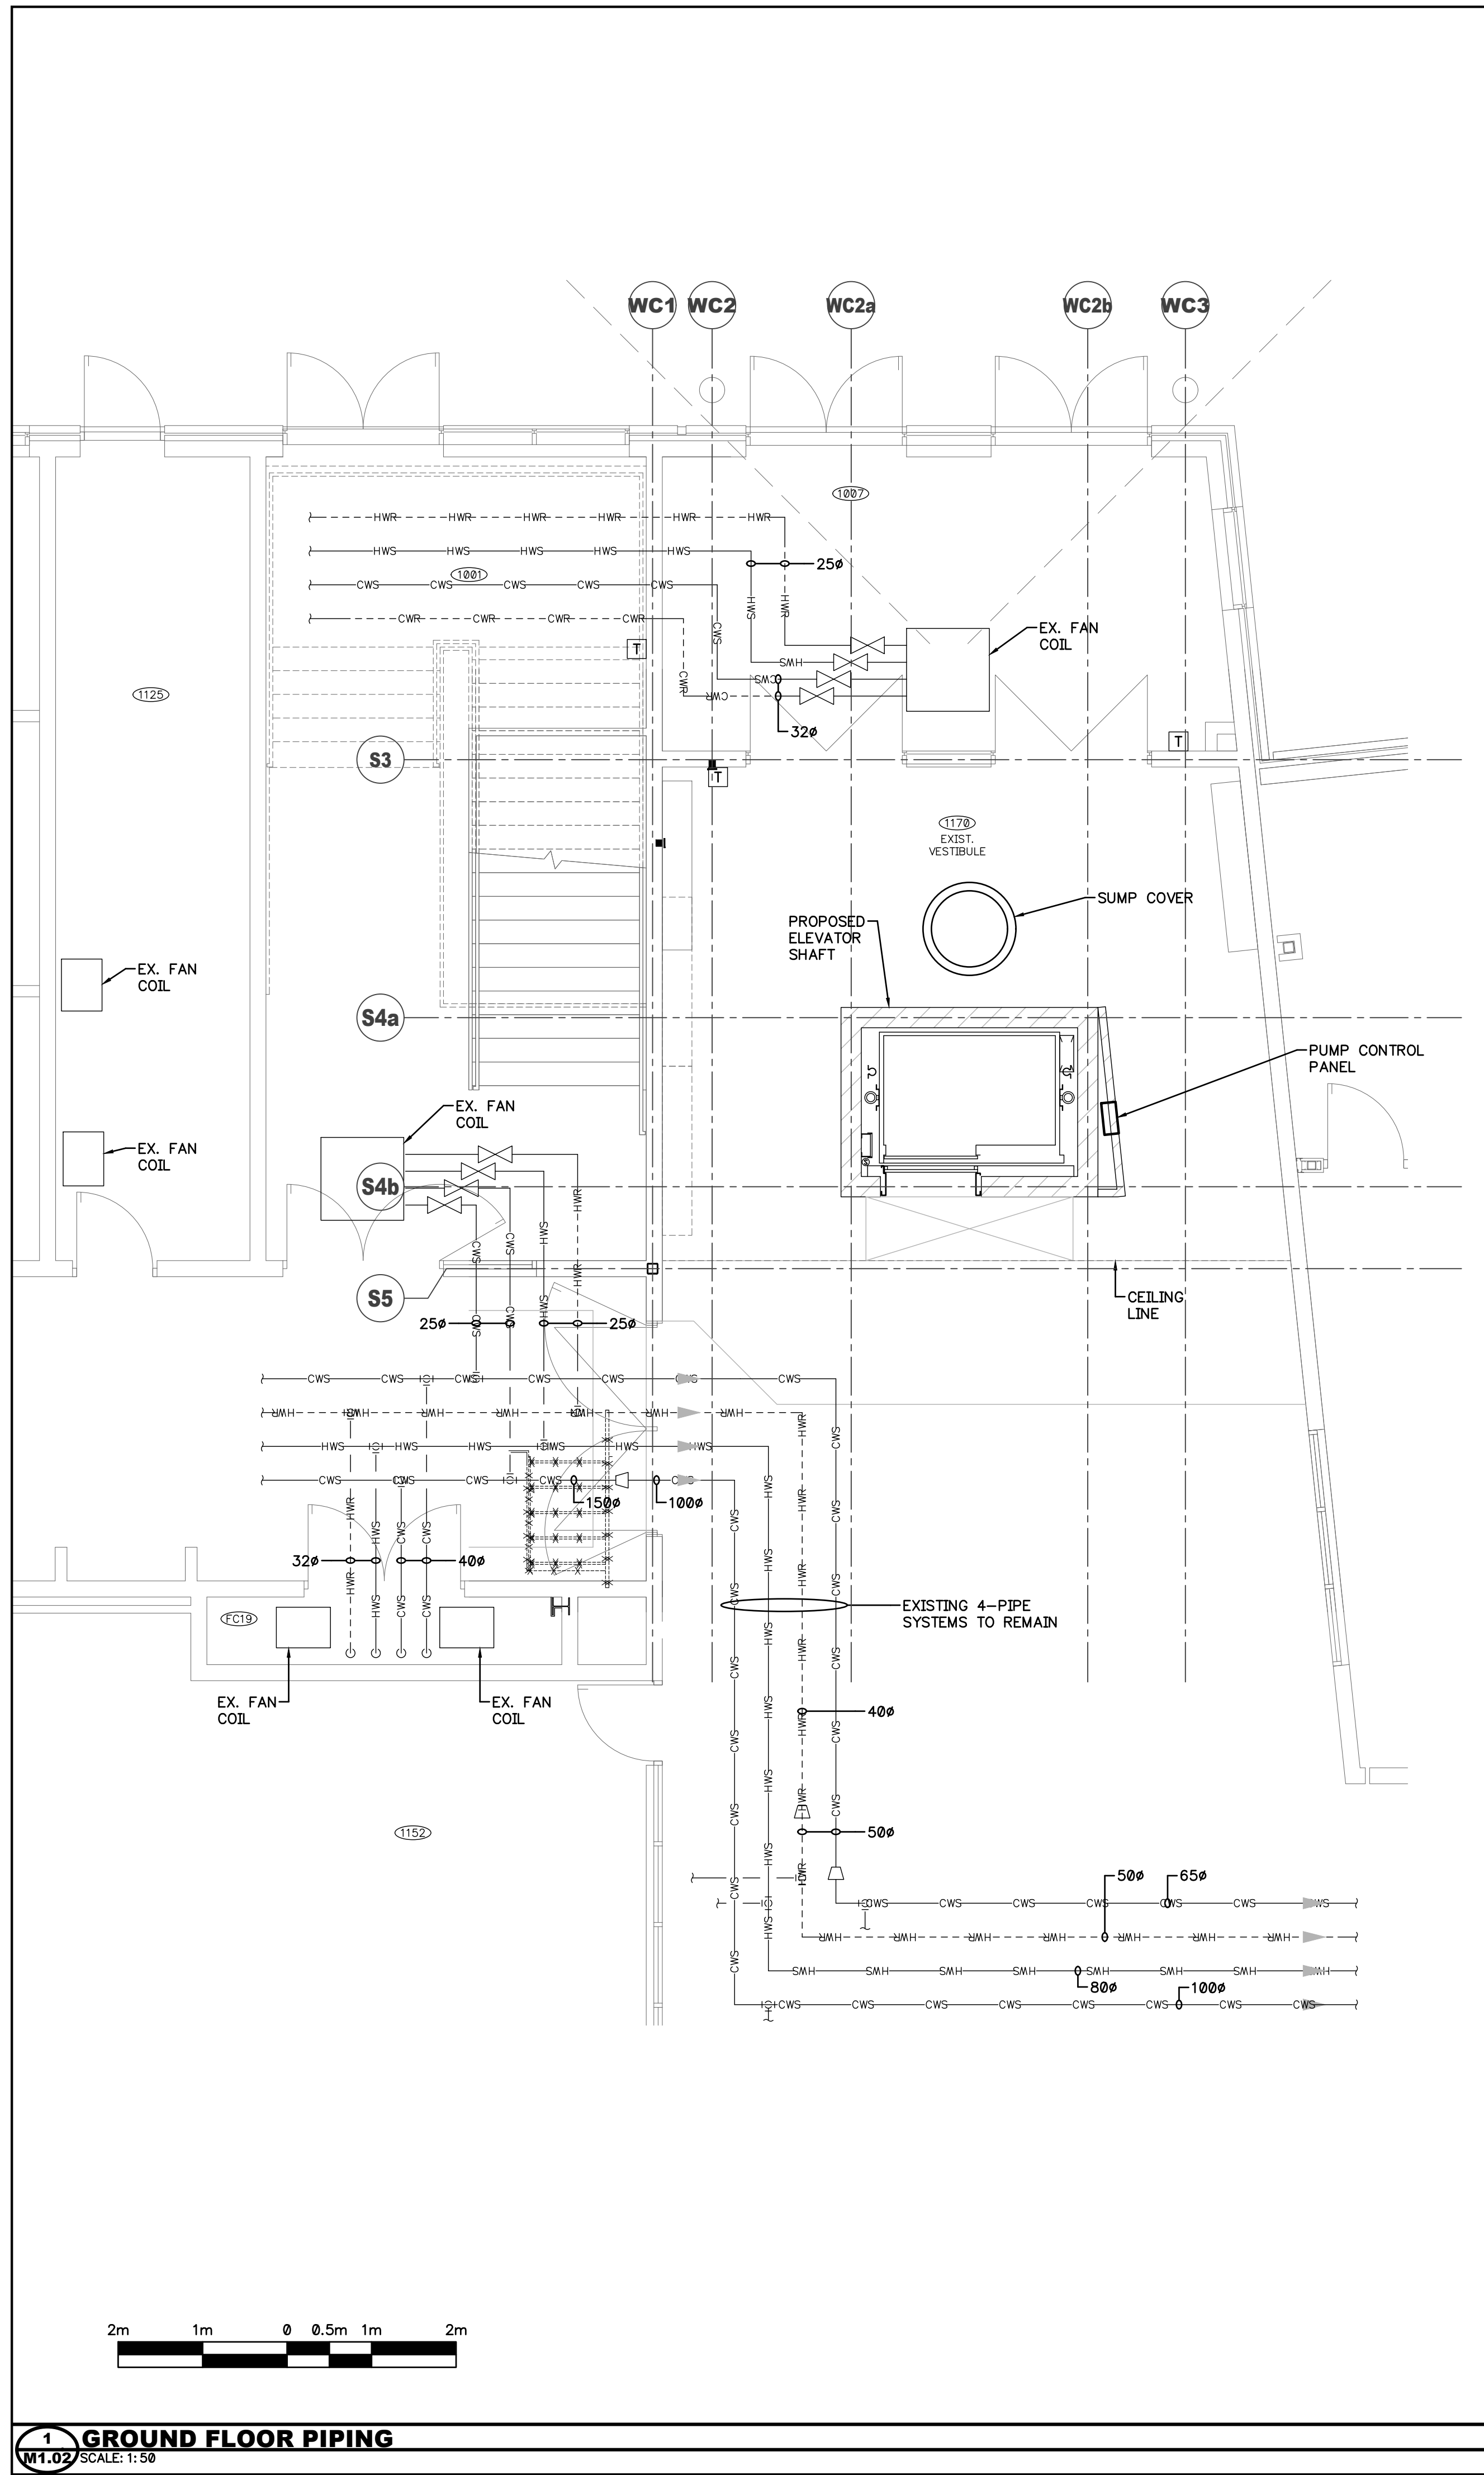


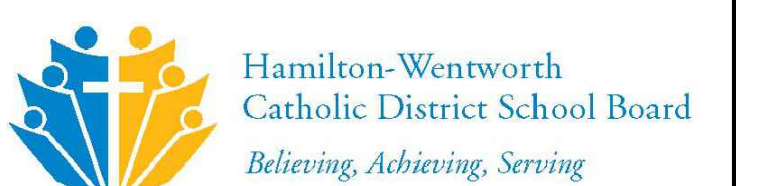

Filer Engineering Ltd.
1046 Botanical Drive
Burlington, Ontario
L7T 1V1
Phone: (905) 526-7411
PROJ. NO: F1503

2	6/24/26	ISSUED—REVISED LOCATION
1	4/21/26	ISSUED
No.	MM/DD/YY	DESCRIPTION

REVISIONS

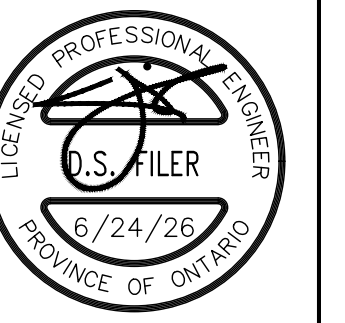



3600 BILLINGS COURT, SUITE 100
BURLINGTON, ONTARIO L7N 3N6
TEL: (905) 308-7771

**ELEVATOR
FOR
BISHOP TONNOS
CATHOLIC SECONDARY SCHOOL**

**100 PANABAKER DR.
ANCASTER ONTARIO**

PIPING PLANS

SCALE	DRAWN	PROJECT No.
AS NOTED	ARC	125804
DATE	CHECKED	DRAWING No.
APRIL 2026	DSF/BP	M1.02
		DWG: 2 of 5

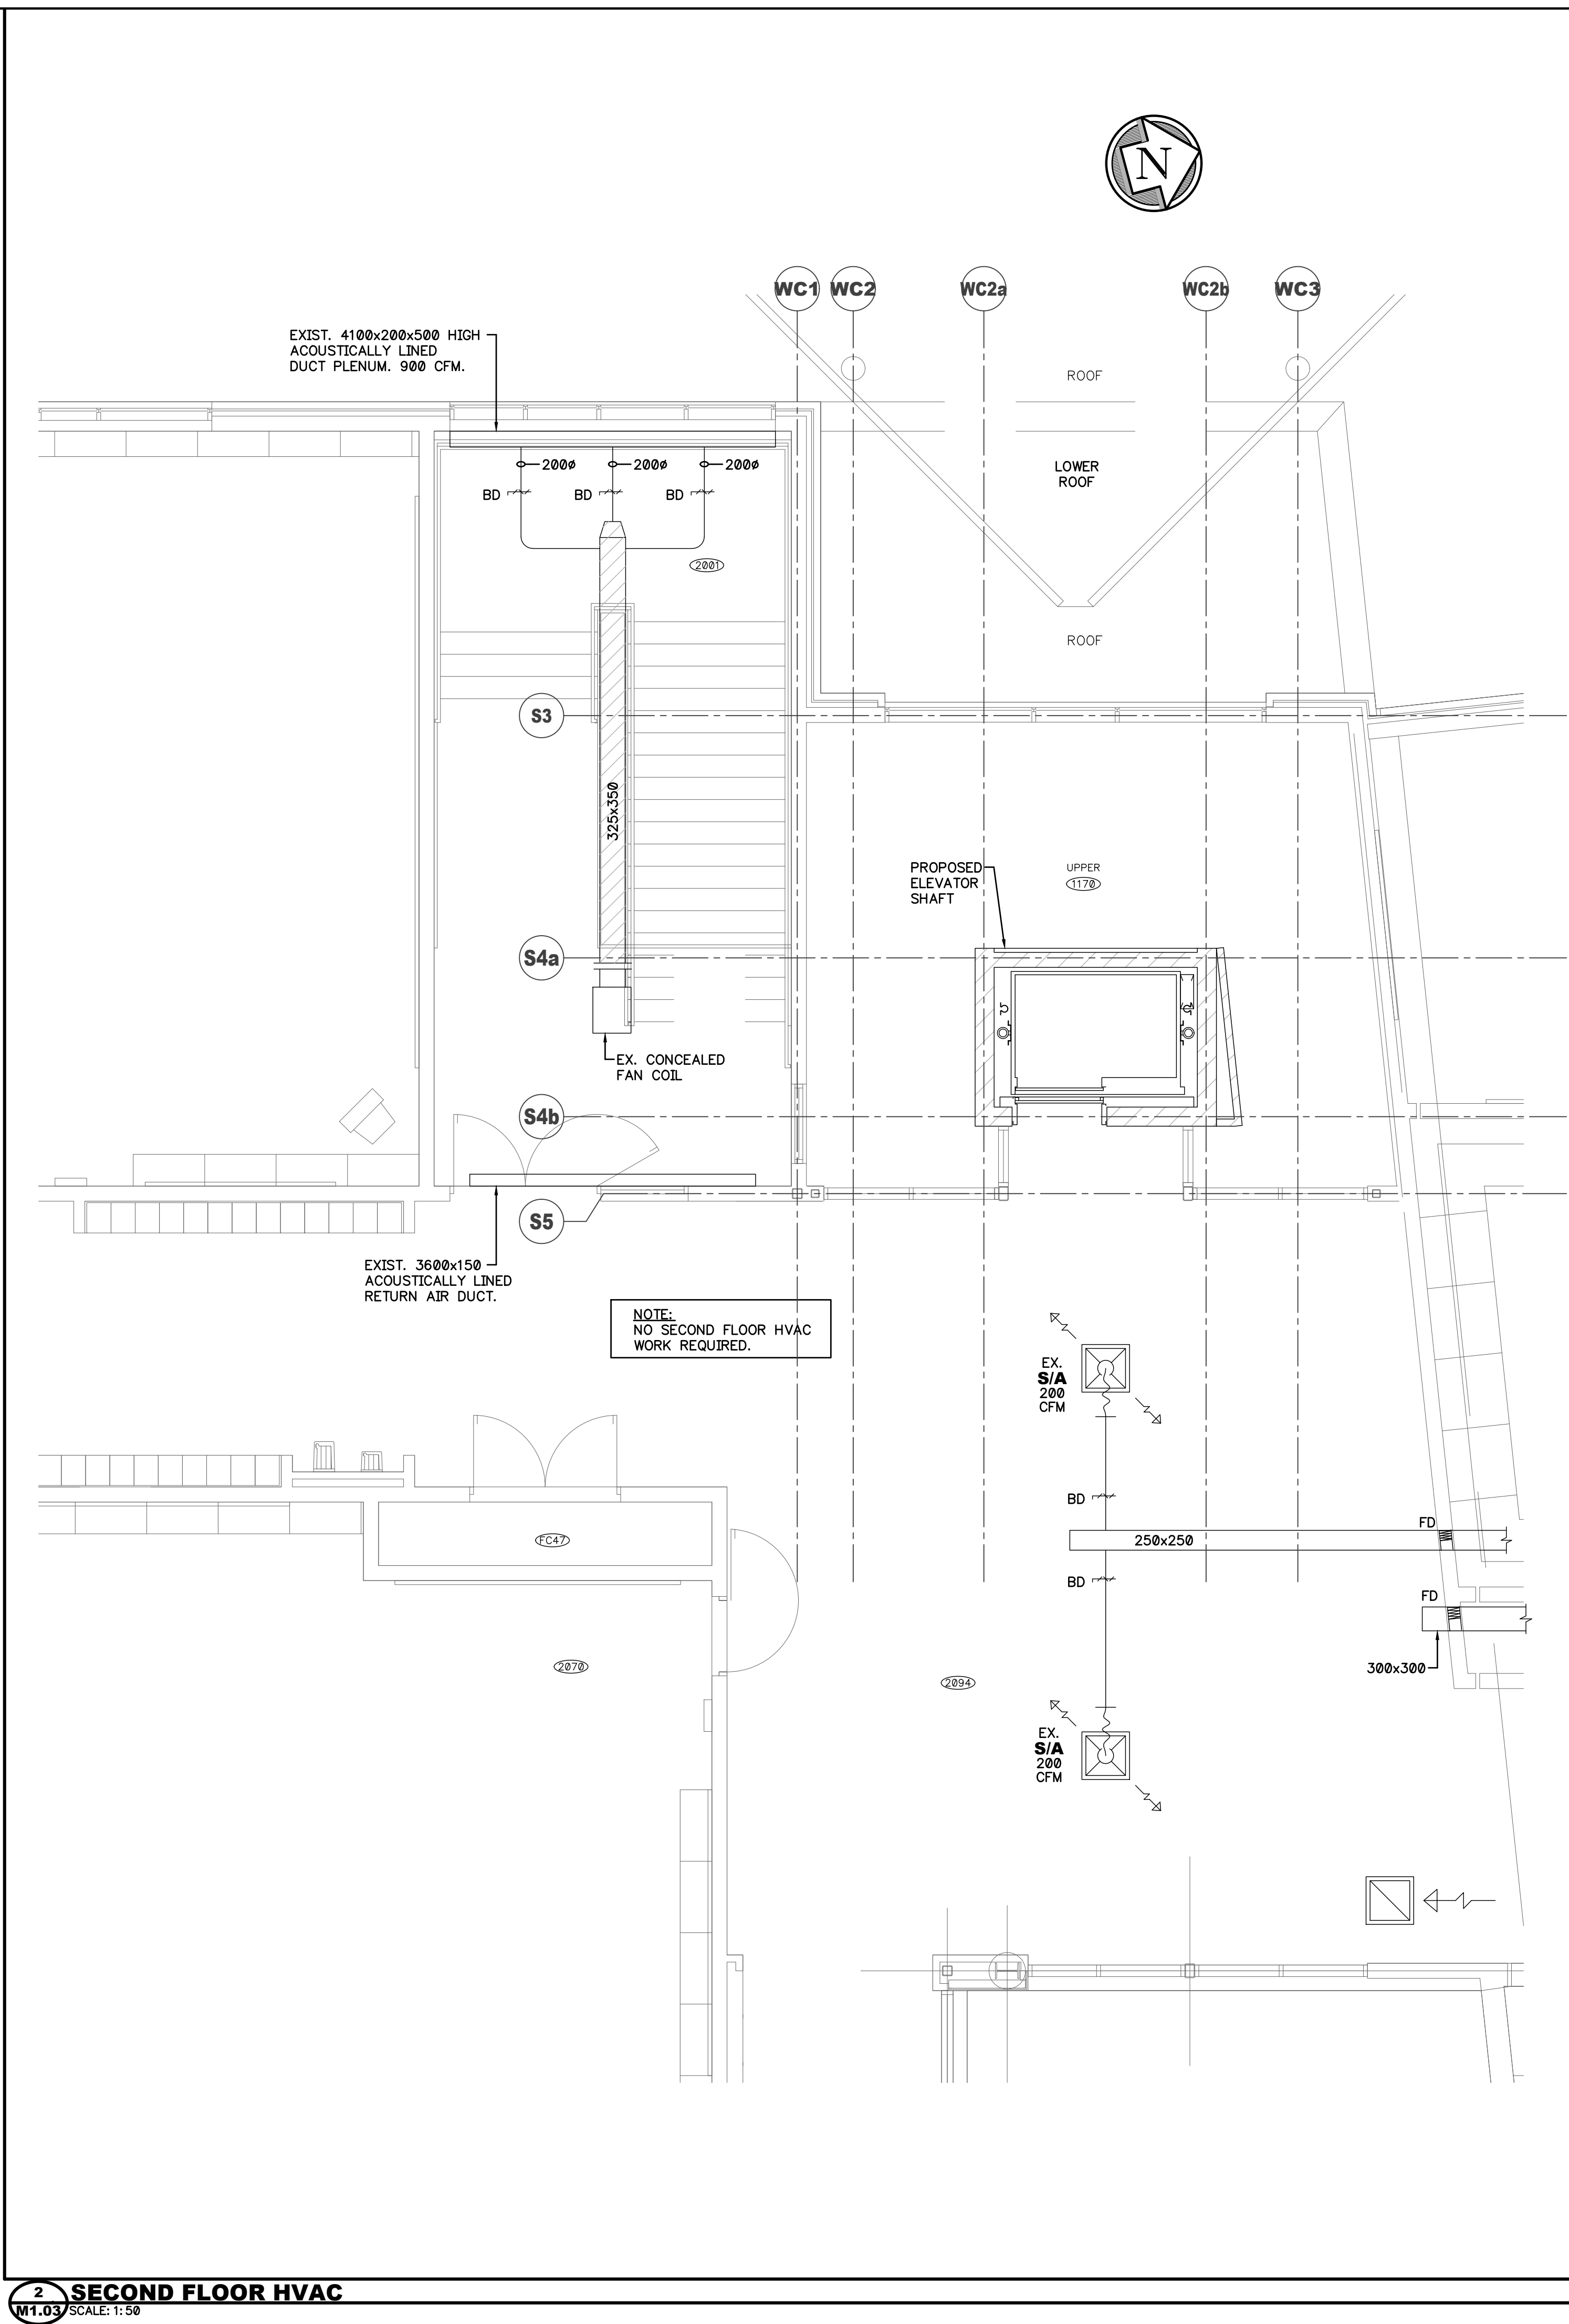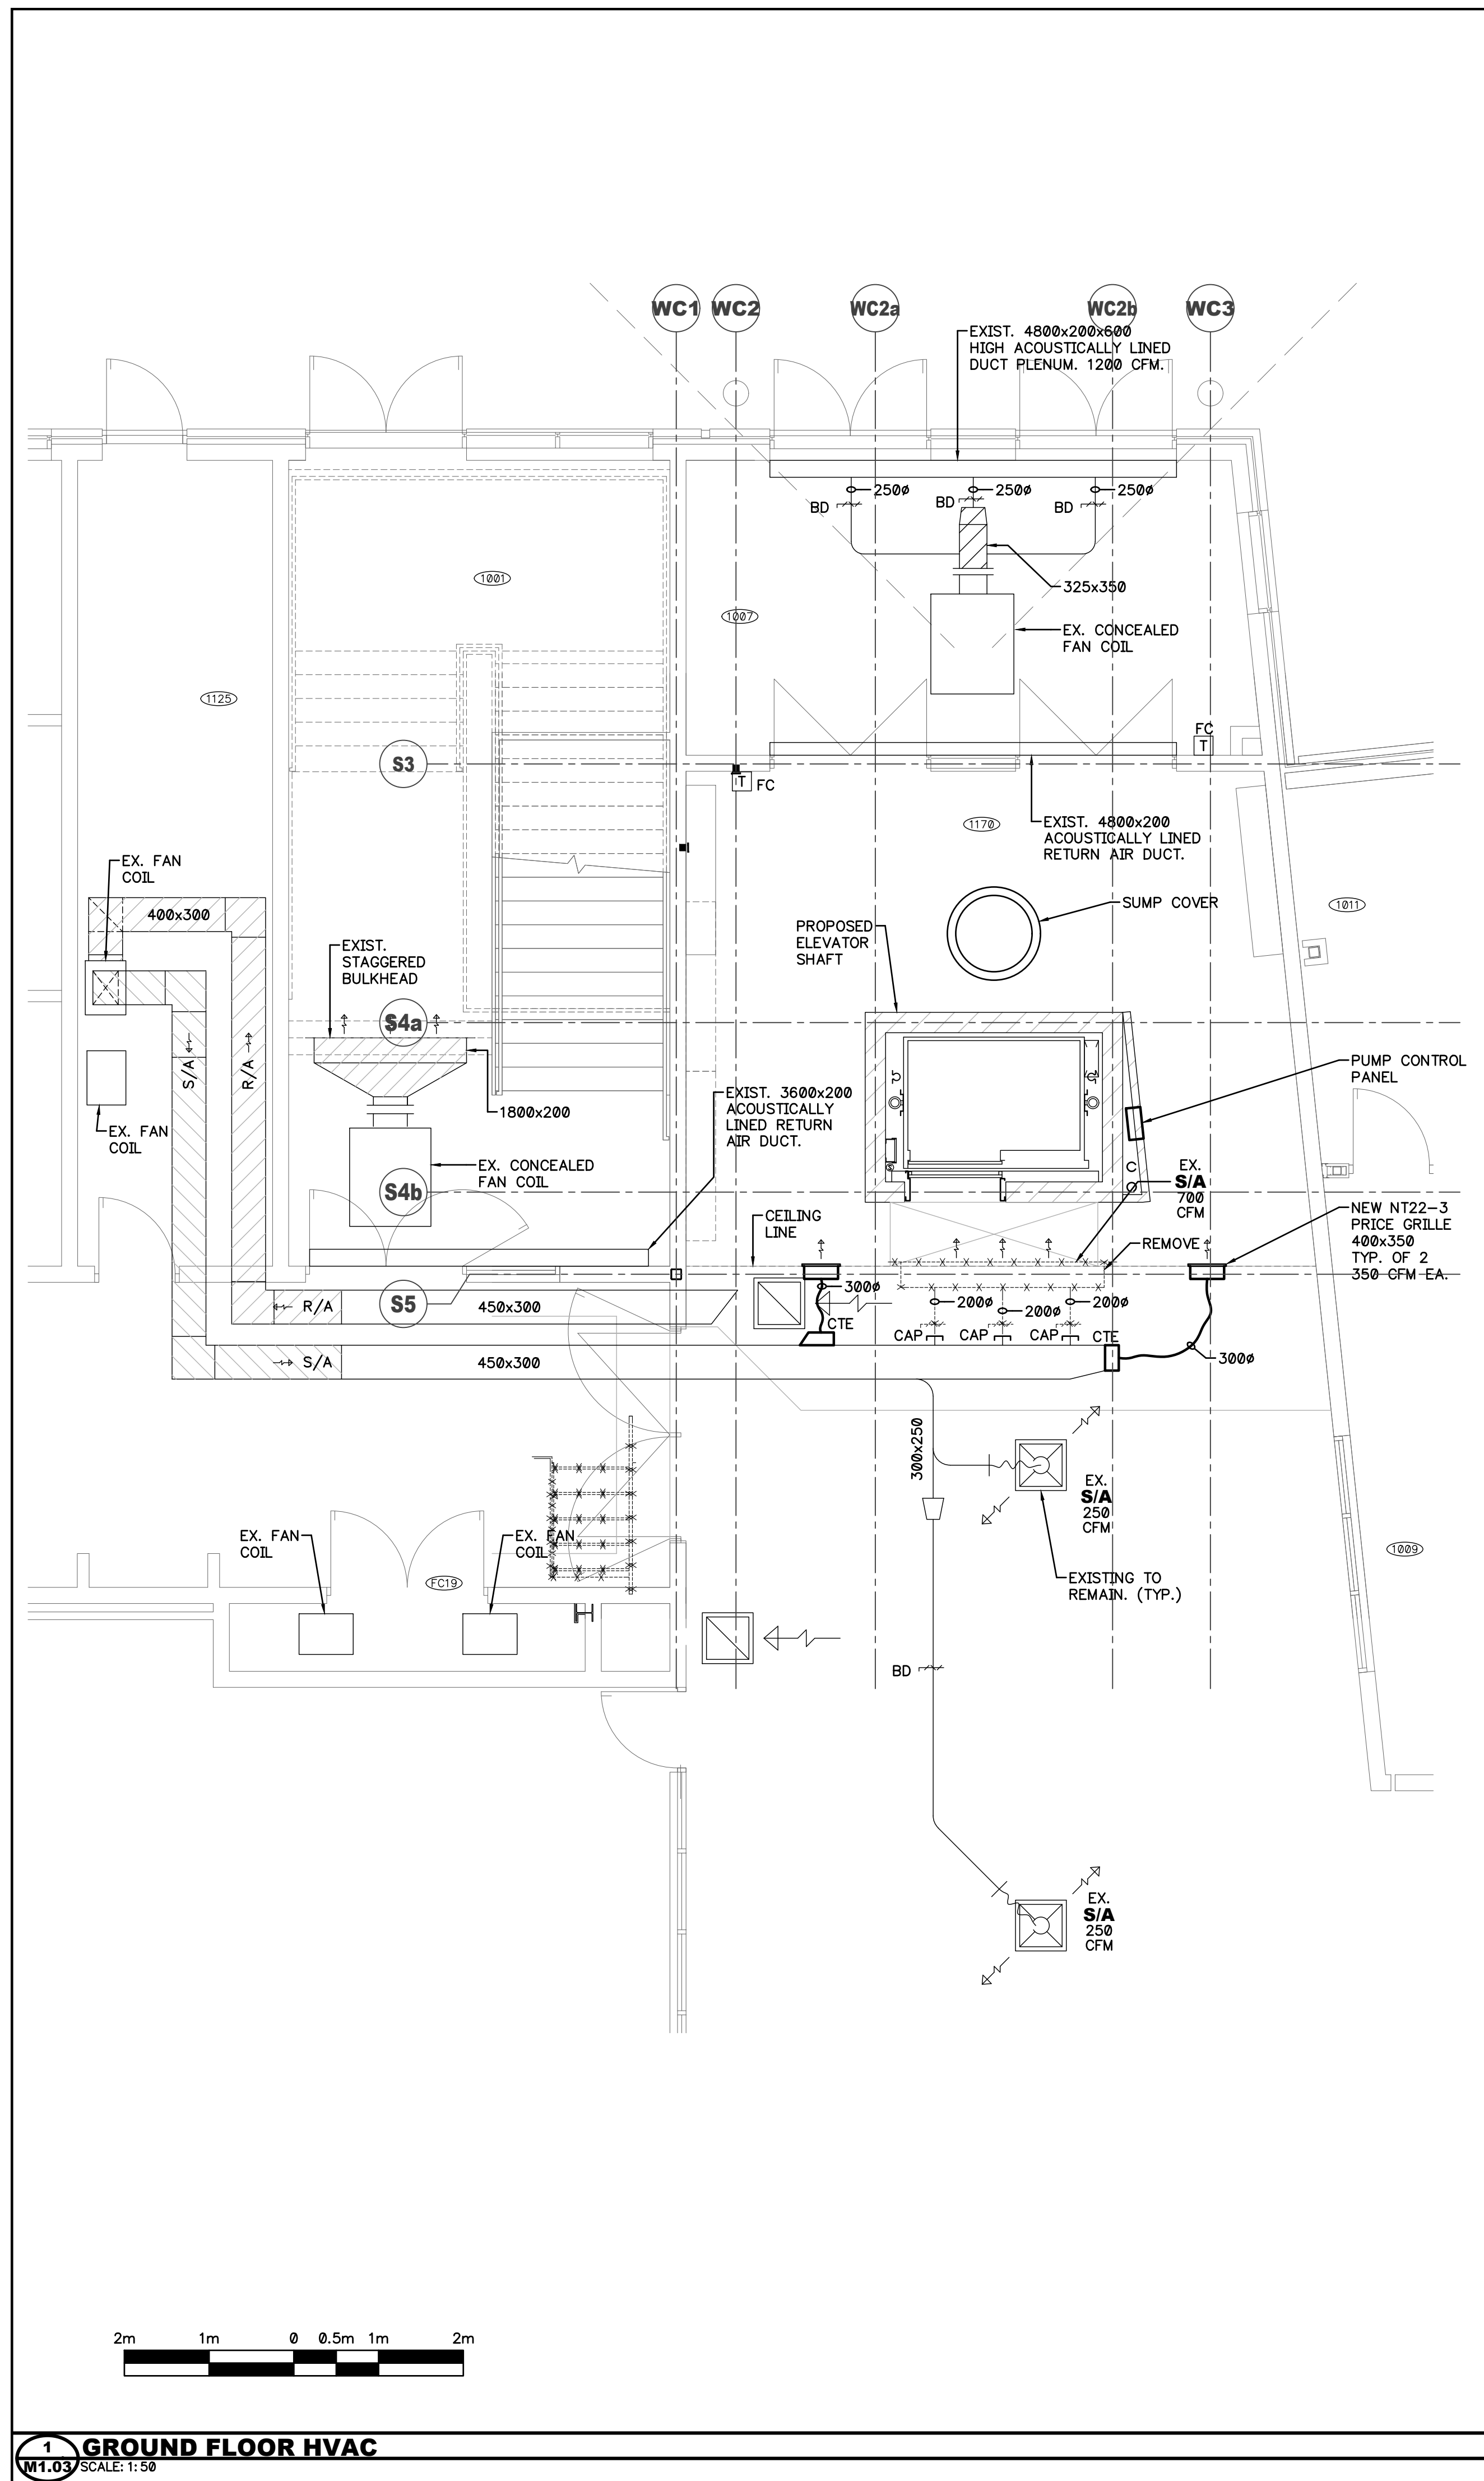

Filer Engineering Ltd.
 1046 Botanical Drive
 Burlington, Ontario
 L7T 1V1
 Phone: (905) 526-7411
 PROJ. NO: F1503

2	6/24/26	ISSUED—REVISED LOCATION
1	4/21/26	ISSUED
No.	MM/DD/YY	DESCRIPTION

REVISIONS

Hamilton-Wentworth Catholic District School Board
Believing, Achieving, Serving


SVEDAS / ARCHITECTS INC.
 3600 BILLINGS COURT, SUITE 100
 BURLINGTON, ONTARIO L7N 3N6
 TEL: (905) 308-7771

**ELEVATOR
 FOR
 BISHOP TONNOS
 CATHOLIC SECONDARY SCHOOL**


**100 PANABAKER DR.
 ANCASTER ONTARIO**

**HVAC
 PLANS**

SCALE	DRAWN	PROJECT No.
AS NOTED	ARC	125804
DATE	CHECKED	DRAWING No.
APRIL 2026	DSF/BP	M1.03
		DWG: 3 of 5

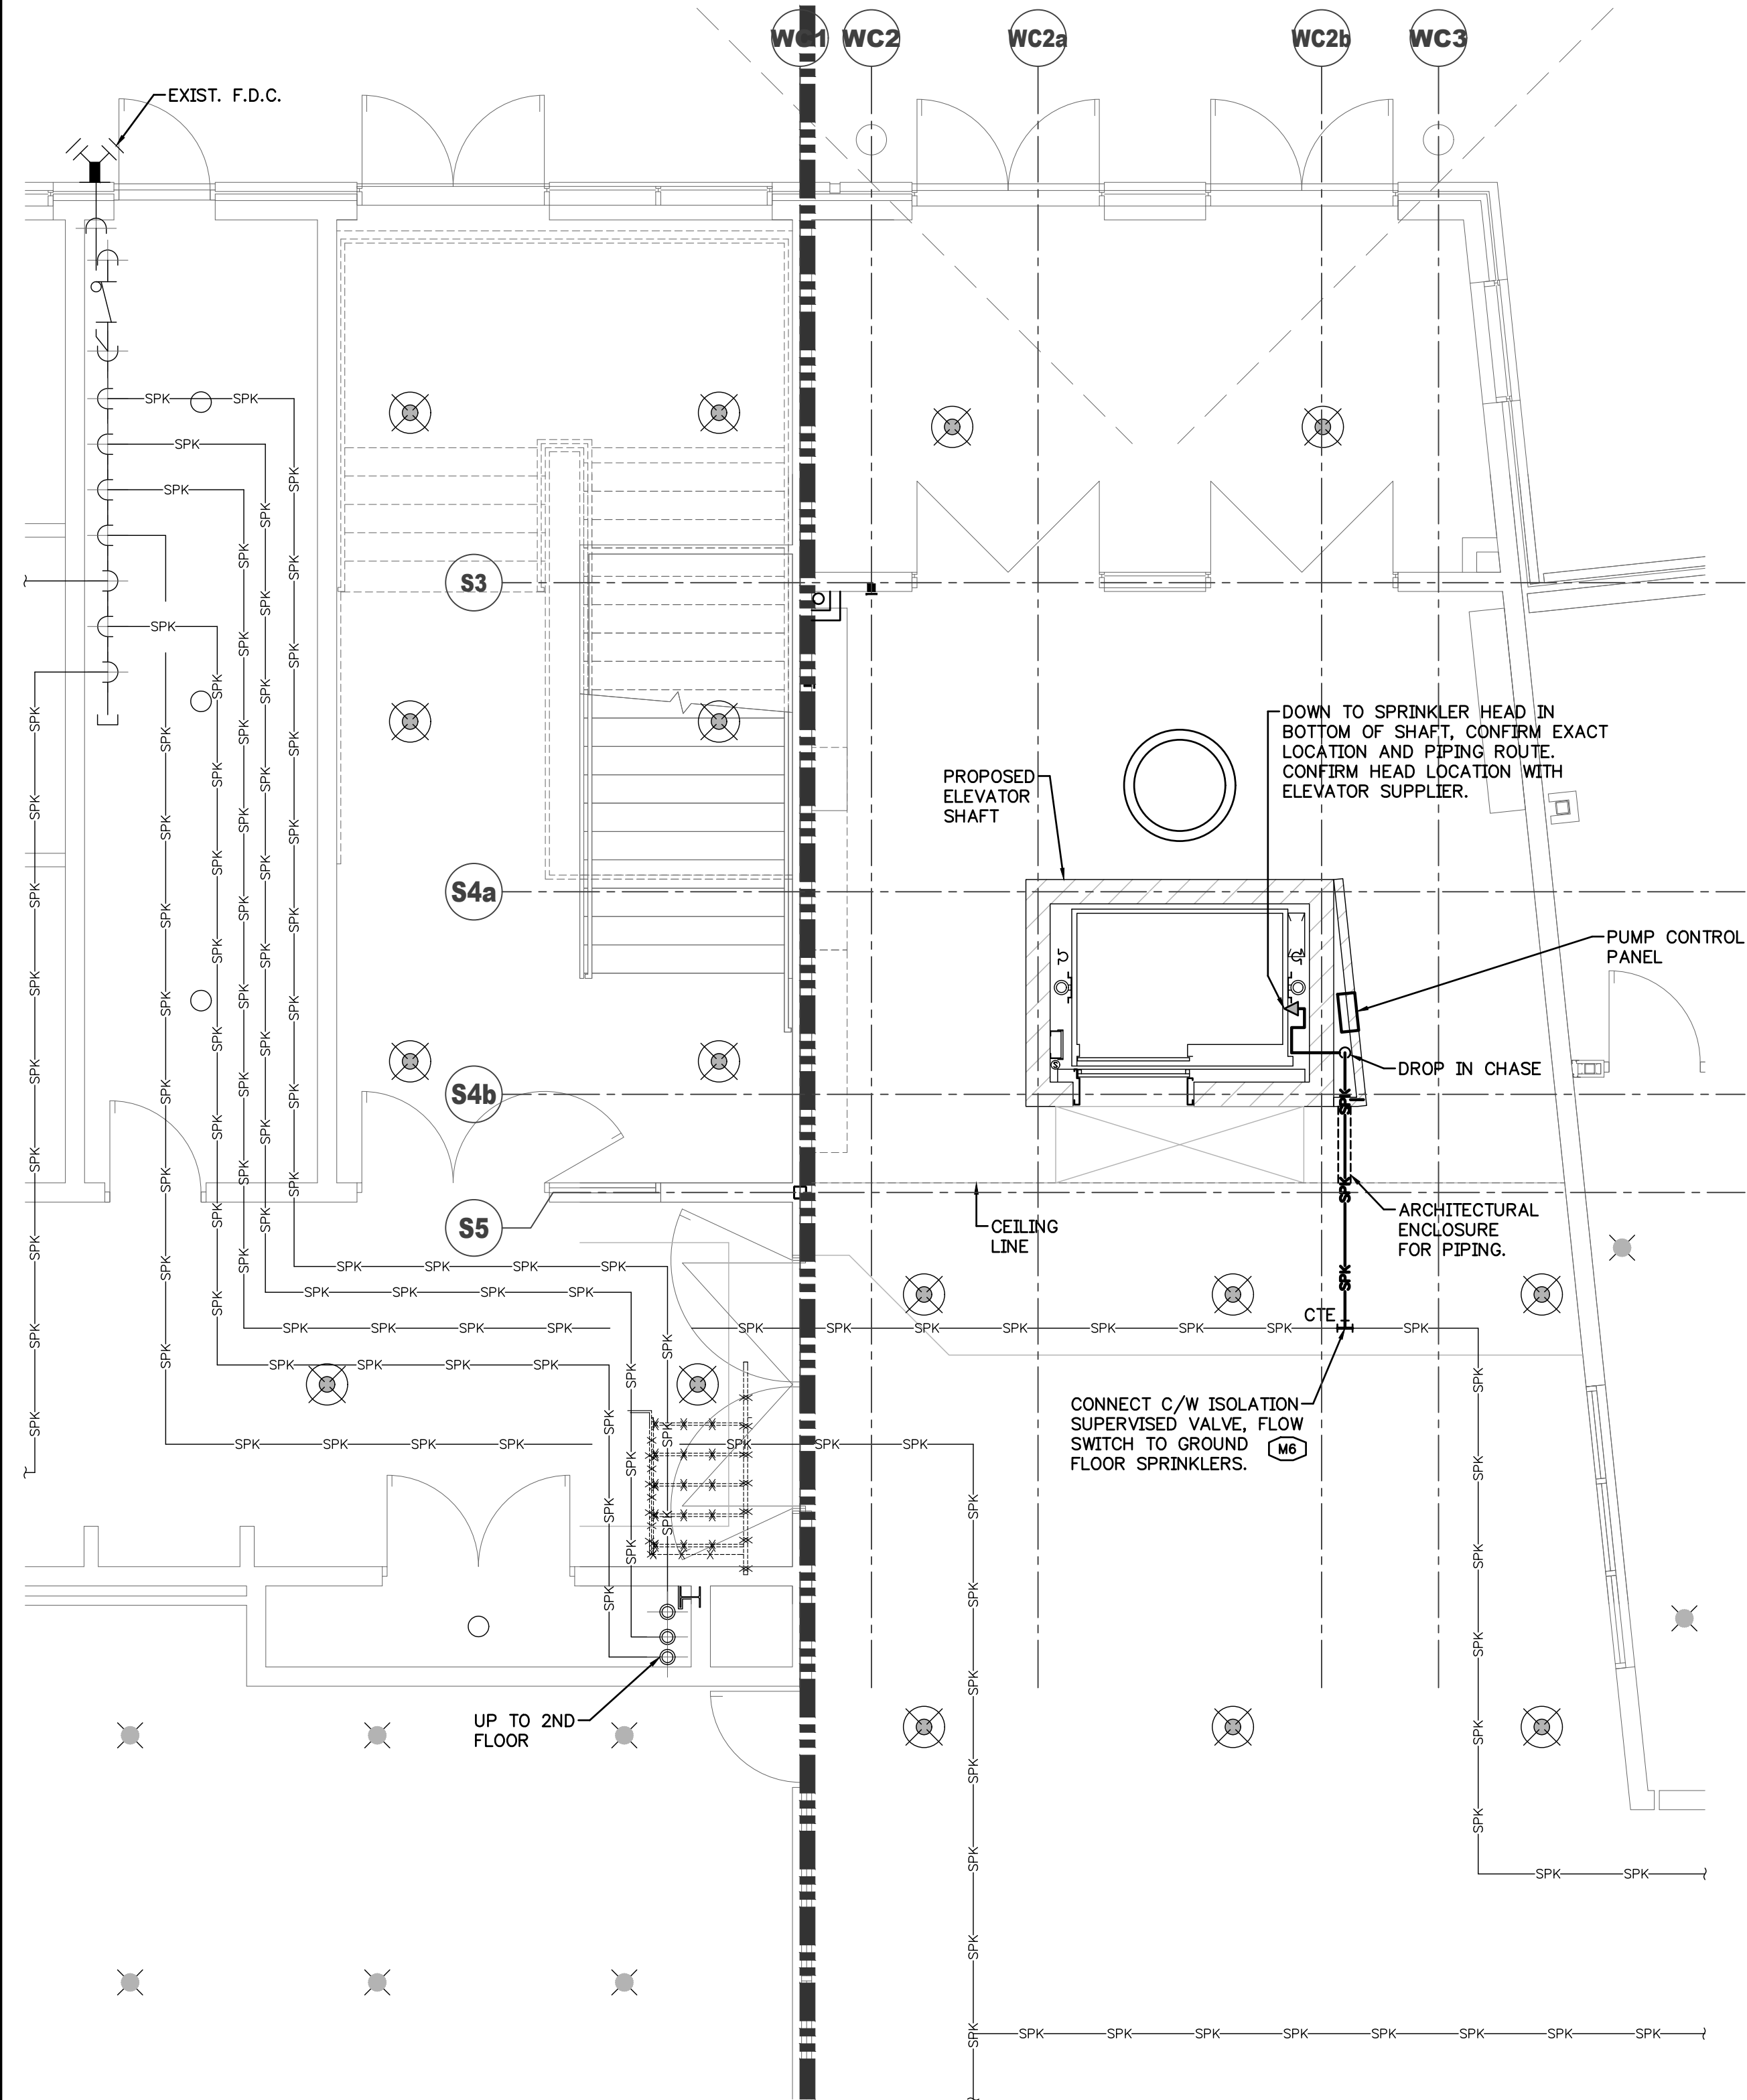

1 GROUND FLOOR SPRINKLER
M1.04 SCALE: 1:50

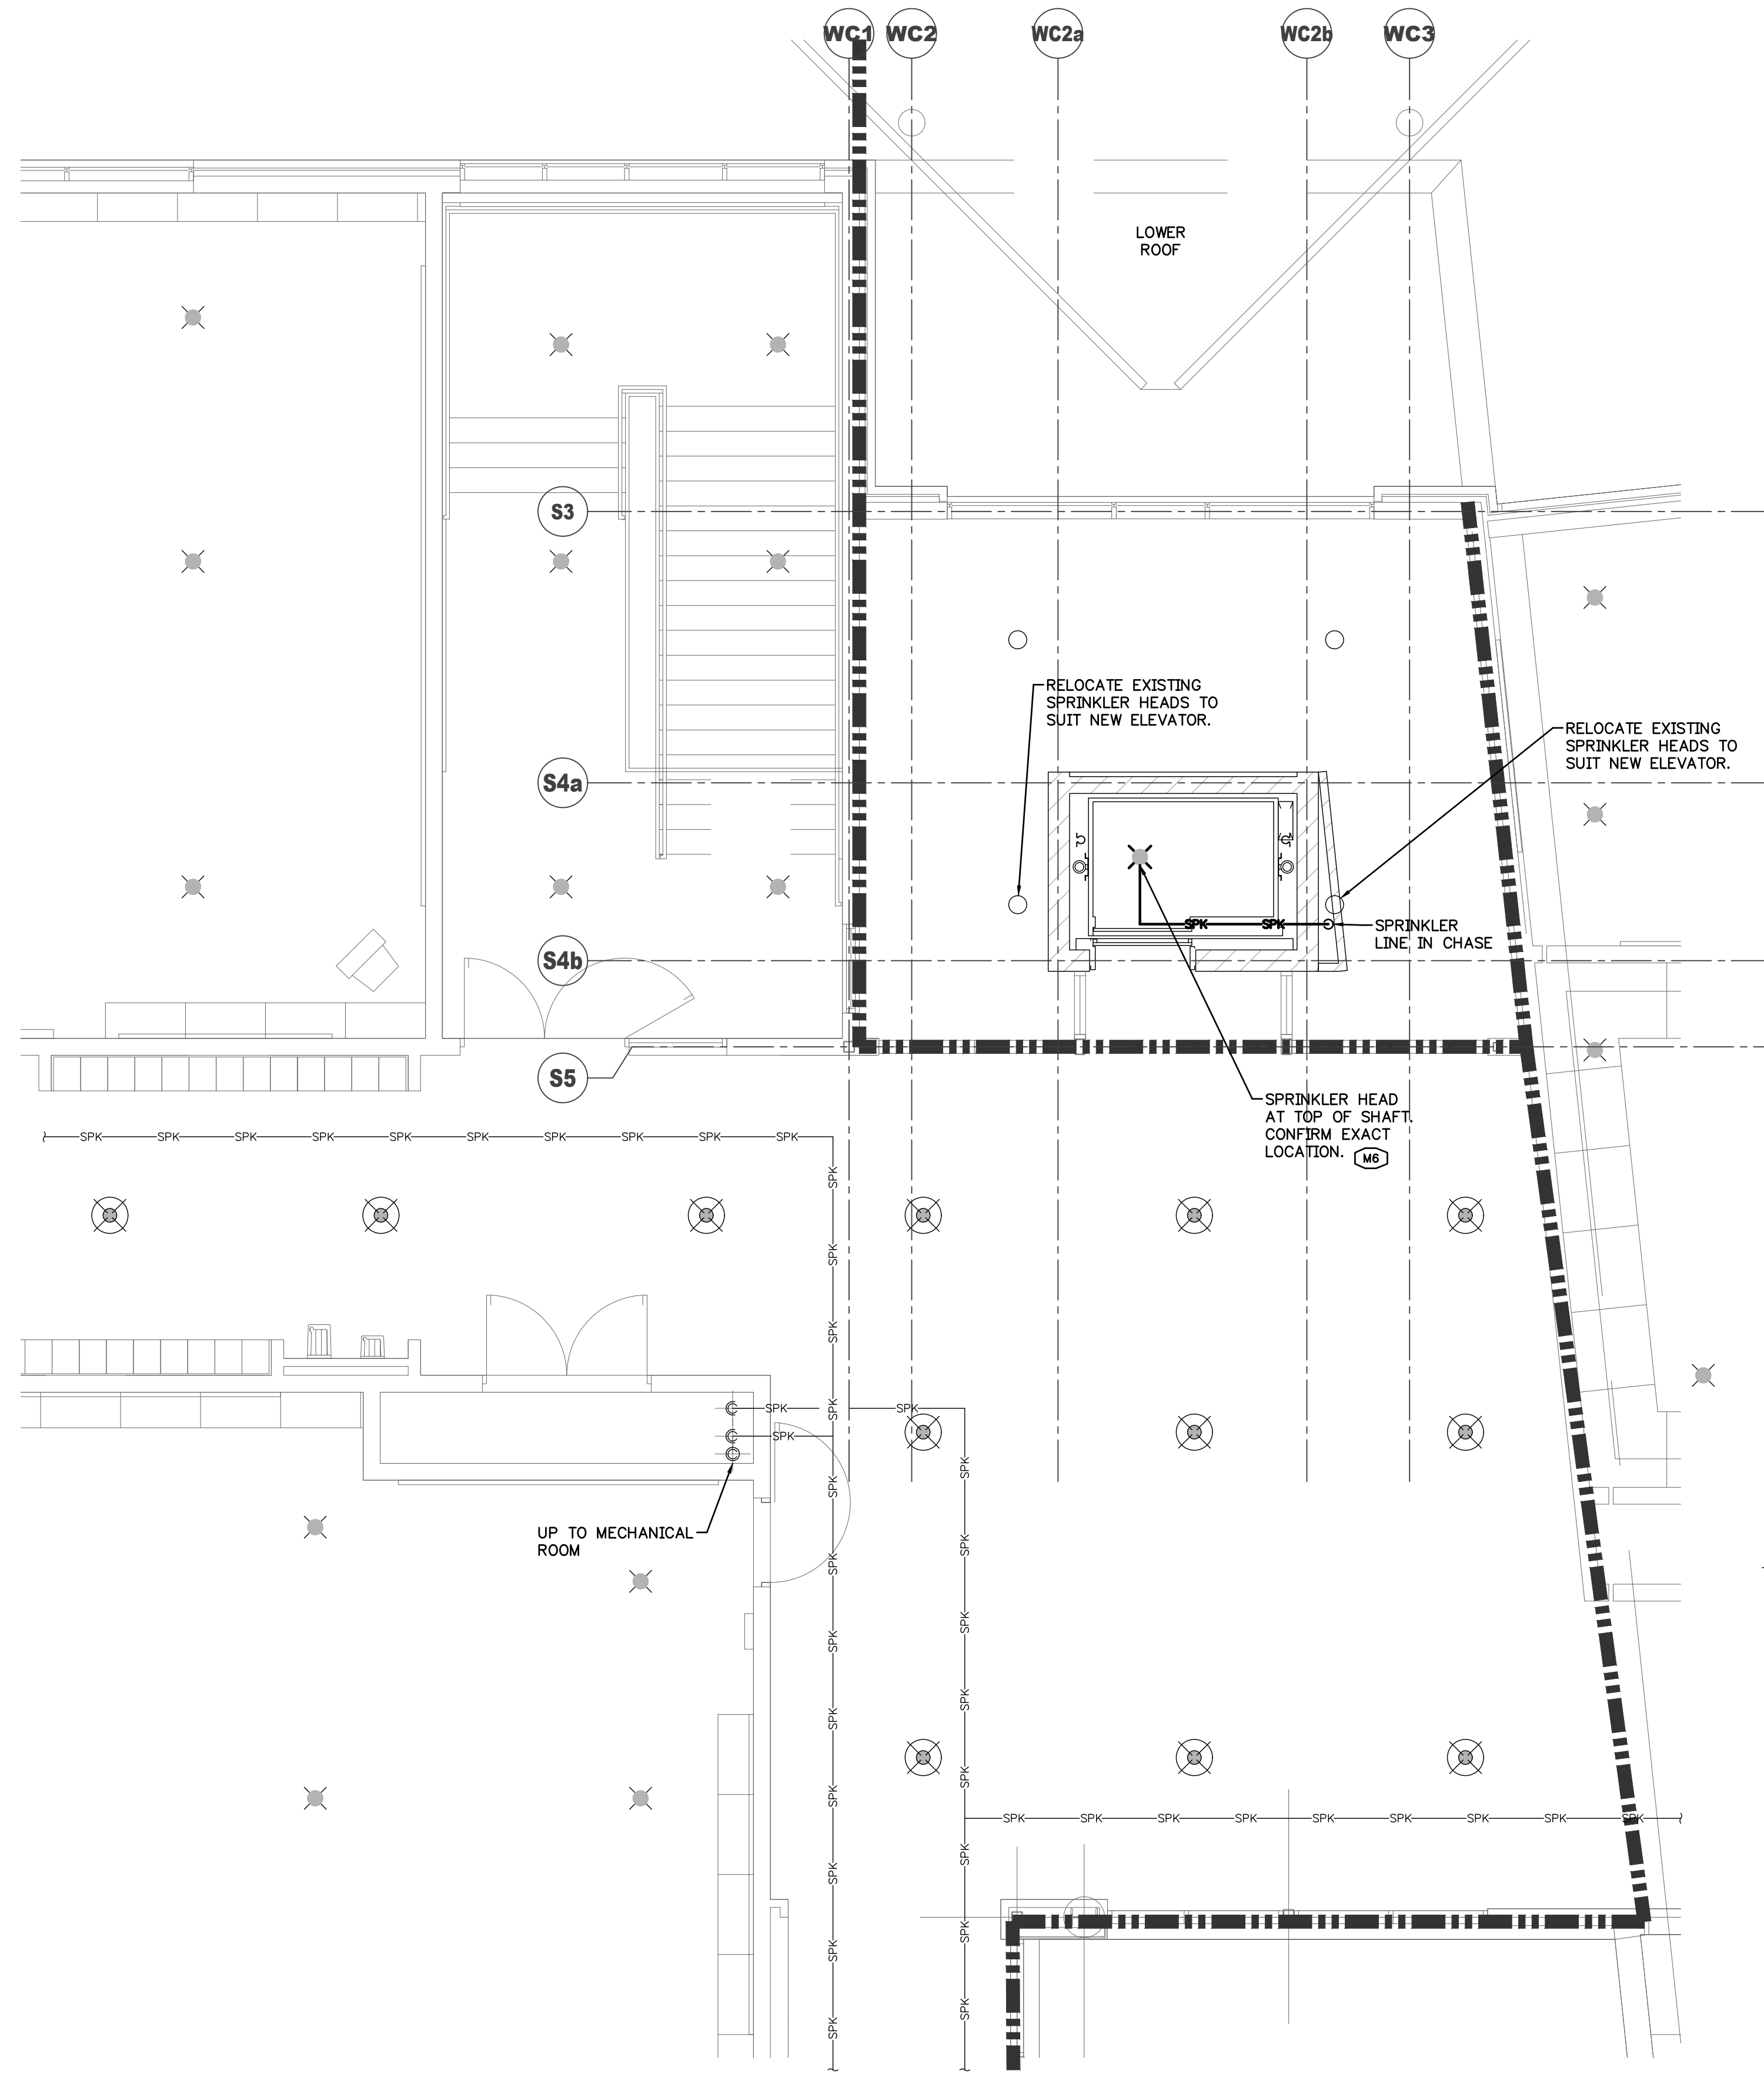


2 SECOND FLOOR SPRINKLER
M1.04 SCALE: 1:50

Filer Engineering Ltd.

1046 Botanical Drive
Burlington, Ontario
L7T 1V1
Phone: (905) 526-7411
PROJ. NO: F1503

2	6/24/26	ISSUED—REVISED LOCATION
1	4/21/26	ISSUED
No.	MM/DD/YY	DESCRIPTION

REVISIONS

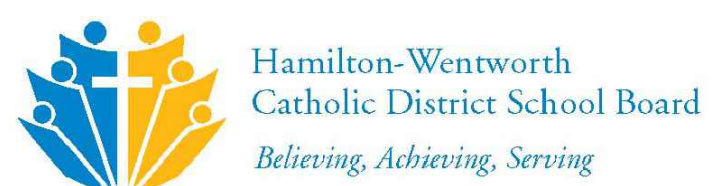

SVEDAS / ARCHITECTS INC.

3600 BILLINGS COURT, SUITE 100
BURLINGTON, ONTARIO L7N 3N6
TEL. (905) 308-7771

ELEVATOR
FOR
BISHOP TONNOS
CATHOLIC SECONDARY SCHOOL

100 PANABAKER DR.
ANCASTER ONTARIO

SPRINKLER
PLANS

SCALE	DRAWN	PROJECT No.
AS NOTED	ARC	125804
DATE	CHECKED	DRAWING No.
APRIL 2026	DSF/BP	M1.04
		DWG: 4 of 5

