









FILENAME: C:\NBS Design\NBS DESIGN JOBS\2026\26-006 SH - 26-080 - Bishop Tonnos Elevator E0.01-E3.03 Rev2.dwg
PLOT DATE: Jul 02, 2026 8:10pm
ARCH D 24X36

DEMOLITION NOTES:	
1.	EXISTING LIGHT FIXTURES TO BE REMOVED AND RETAINED FOR POSSIBLE RE-USE. REDUNDANT FIXTURES TO BE RETAINED FOR OWNER REVIEW AND POSSIBLE RETENTION. DISPOSE OF REDUNDANT FIXTURES OFF-SITE AS DIRECTED. CAP AND MAKE WIRING SAFE. RETAIN EXISTING LIGHTING CIRCUITS FOR POSSIBLE RE-USE.
2.	REMOVE EXISTING RECEPTACLES AND SWITCHES AS SHOWN. CAP AND MAKE WIRING SAFE. DISCONNECT AT ASSOCIATED BREAKER AND LABEL "SPARE". RETAIN EXISTING RECEPTACLE CIRCUITS FOR RE-USE.
3.	EXISTING P/A SPEAKERS TO BE REMOVED BY OWNER'S APPROVED P/A SUBCONTRACTOR. RETAIN FOR OWNER REVIEW AND POSSIBLE RETENTION. DISPOSE OF REDUNDANT UNITS OFF-SITE AS DIRECTED. DISCONNECT, CAP AND MAKE ASSOCIATED WIRING SAFE. RETAIN CIRCUITS FOR RE-USE.
4.	EXISTING FIRE ALARM EQUIPMENT AND ASSOCIATED WIRING TO BE REMOVED AND RETAINED FOR RE-INSTALLATION OR OWNER REVIEW AND POSSIBLE RETENTION. DISPOSE OF REDUNDANT DEVICES OFF-SITE AS DIRECTED. RETAIN EXISTING CIRCUITS FOR RE-USE.
5.	EXISTING EMERGENCY / EXIT LIGHTING UNITS TO BE REMOVED, RETAINED FOR RE-INSTALLATION OR FOR OWNER REVIEW AND POSSIBLE RETENTION. DISPOSE OF REDUNDANT UNITS OFF-SITE AS DIRECTED. DISCONNECT, CAP AND MAKE ASSOCIATED WIRING SAFE. RETAIN CIRCUITS FOR RE-USE.
6.	DISCONNECT POWER FEEDS TO EXISTING MECHANICAL EQUIPMENT TO BE REMOVED/RELOCATED BY MECHANICAL CONTRACTOR. RETAIN CIRCUITS FOR RE-USE.
7.	PROVIDE STAINLESS STEEL COVER PLATES AS REQUIRED FOR ALL REDUNDANT OUTLET BOXES TO REMAIN IN EXISTING WALLS.

NEW LIGHTING & LIFE SAFETY NOTES:	
1.	PROVIDE NEW INTERIOR LIGHT FIXTURES AS SHOWN. WIRE TO NEW OR EXISTING LOCAL LIGHTING CIRCUITS AS NECESSARY. PROVIDE NEW STANDARD, DIMMING &/OR OCCUPANCY SENSOR LIGHT SWITCHES AS INDICATED.
2.	PROVIDE NEW EMERGENCY / EXIT "RUNNING MAN" LIGHTING UNITS AS REQUIRED. WIRE TO NEW AC/DC EMERGENCY LIGHTING CIRCUITS AS INDICATED.
3.	PROVIDE NEW FIRE ALARM SYSTEM DEVICES AS SHOWN. WIRE TO NEW OR EXISTING FIRE ALARM ZONES ON EXISTING FIRE ALARM SYSTEM AS INDICATED.

NEW POWER & COMMUNICATIONS NOTES:	
1.	SUPPLY AND INSTALL NEW RECEPTACLES AS SHOWN. WIRE TO NEW OR EXISTING BREAKERS IN NEW LOCAL PANEL BOARDS AS INDICATED. MAXIMUM FOUR (4) RECEPTACLES PER 15A CIRCUIT.
2.	PROVIDE RECESSED OUTLET BOXES FOR NEW DATA / TELEPHONE OUTLETS AS SHOWN. RETAIN OWNER'S APPROVED DATA / TELEPHONE SUBCONTRACTOR TO SUPPLY, INSTALL, TERMINATE AND TEST DATA & TELEPHONE JACKS C/W CAT6 WIRING FOR DATA AND CAT3 WIRING FOR TELEPHONE.
3.	PROVIDE NEW POWER FEEDS TO NEW MECHANICAL EQUIPMENT AS REQUIRED. WIRE TO NEW SUITABLY SIZED BREAKERS IN NEW LOCAL PANEL BOARDS AS SHOWN.
4.	PROVIDE NEW POWER FEEDS TO NEW EQUIPMENT AS INDICATED. EQUIPMENT SUPPLIED BY OTHERS.
5.	COORDINATE ELEVATOR DISCONNECTS LOCATION IN SHAFT, ELEVATOR POWER REQUIREMENTS/FEED LOCATION WITH ELEVATOR SUPPLIER BEFORE COMMENCING WORK.

BISHOP TONNES CATHOLIC SECONDARY SCHOOL - NEW ELEVATOR				
Light Fixture Schedule				
Type	Description	Base Bid	Approved Alternates	Watts
A	120V, LED, 4000K, Surface wall mounted light fixture. Mount to clear elevator.	Keene RoughLite Cat # VVXL-14-NW-G1-8	Lithonia LED Vaportight cat # OLVTVWM	14
B	152mm (6") dia., 120V, LED, 1500 Lumen, 3500K, 0-10V Dimming, Gypsum board recess mounted Downlight fixture.	Lightolier ModuLite Cat # M6RDL25F935VWHZ10U c/w 6RNSR frame kit	Lithonia LBR6 Downlight Cat # LBR6 25LM 35K WR WD MVOLT UC21 c/w VWF8543	27
C	120V, LED, 3500K, Recess wall mounted direct/indirect decorative wall sconce fixture. Architect to select fixture/diffuser color finish. MH = 3400mm	OCL Cat # BA2-S15A-24-XX-XXX-LED2-935K-UNV-DM1	No Alternates	15

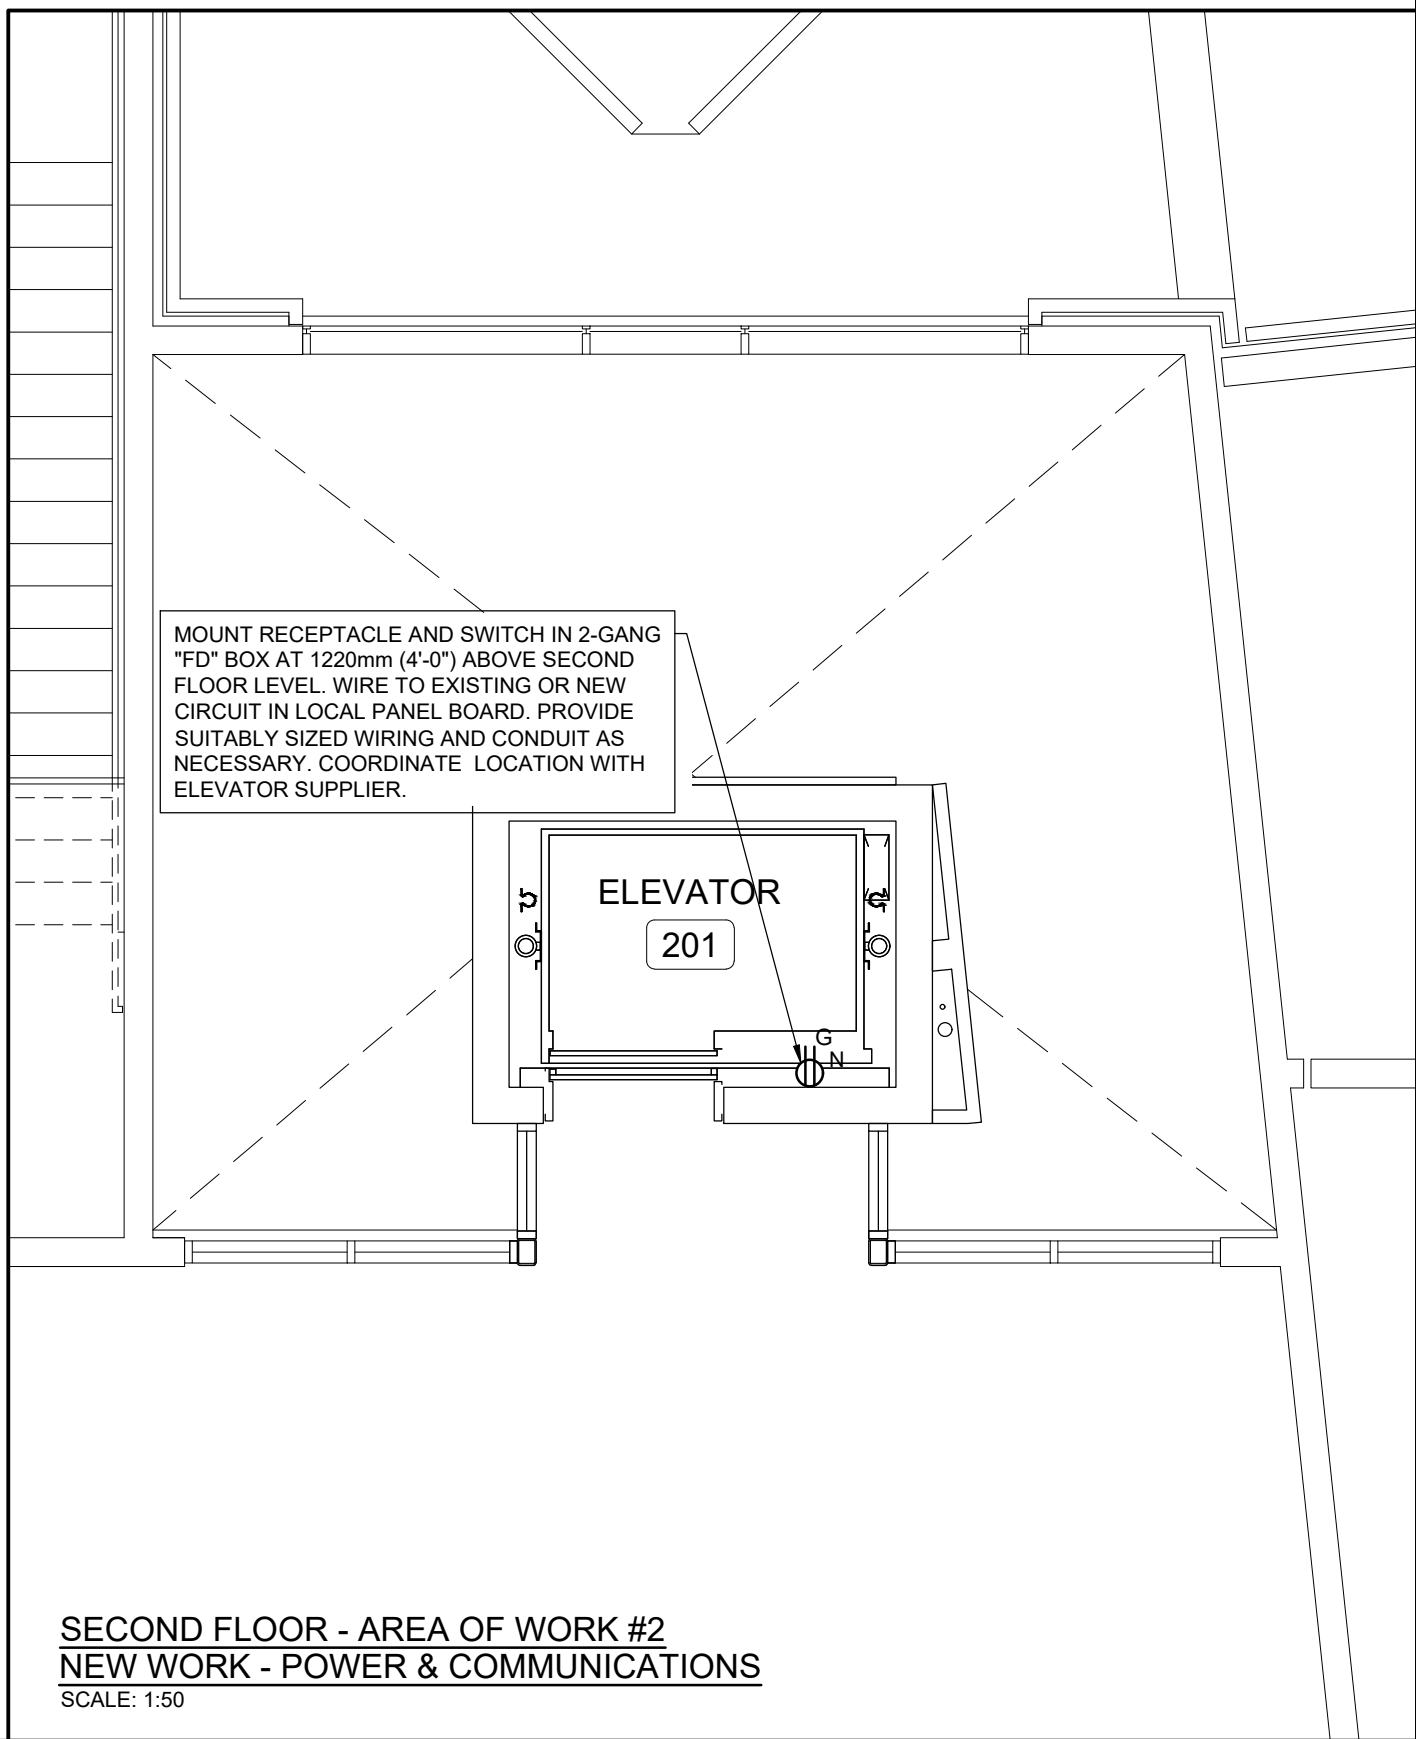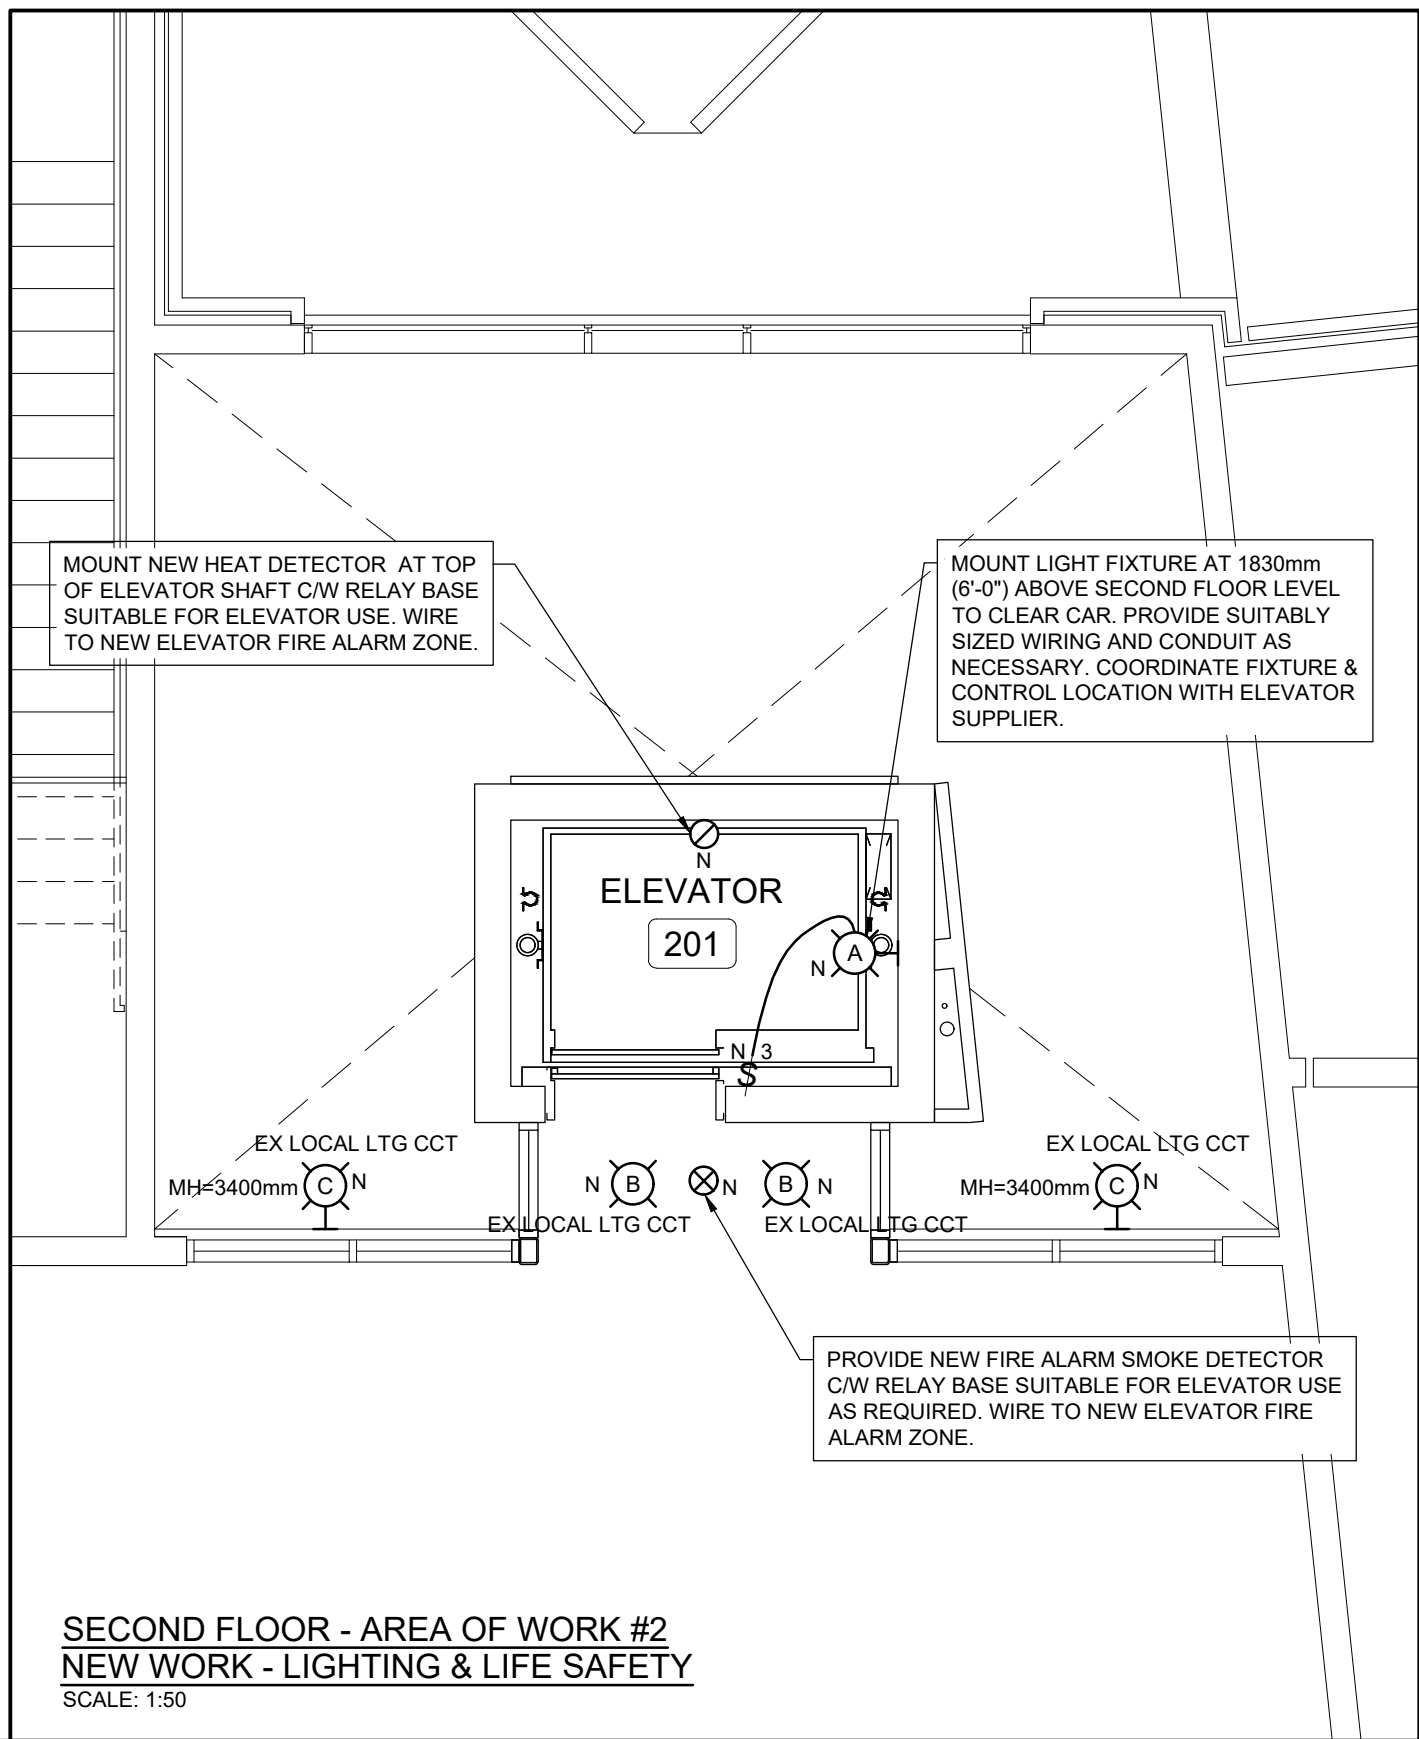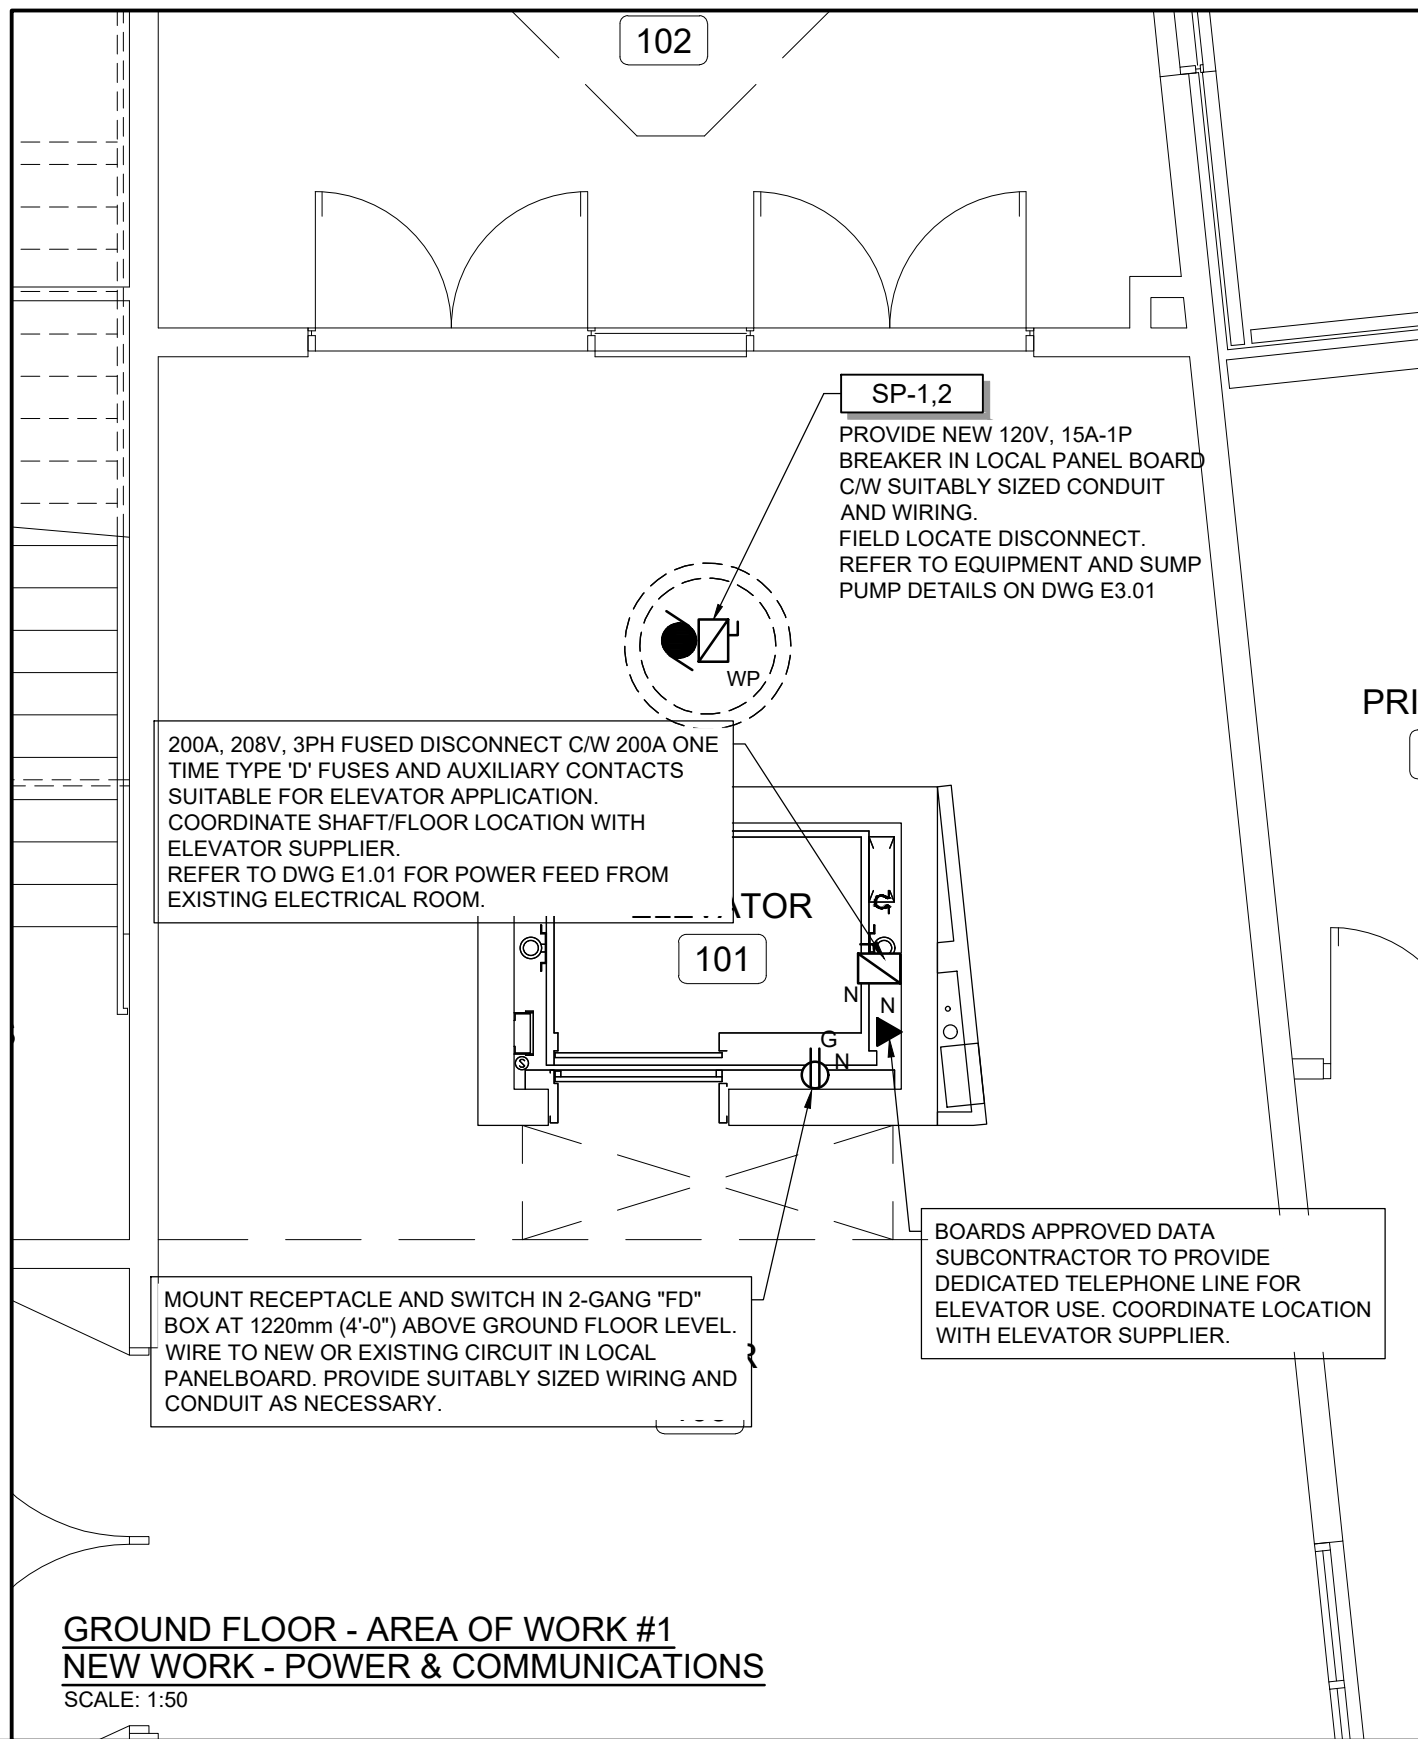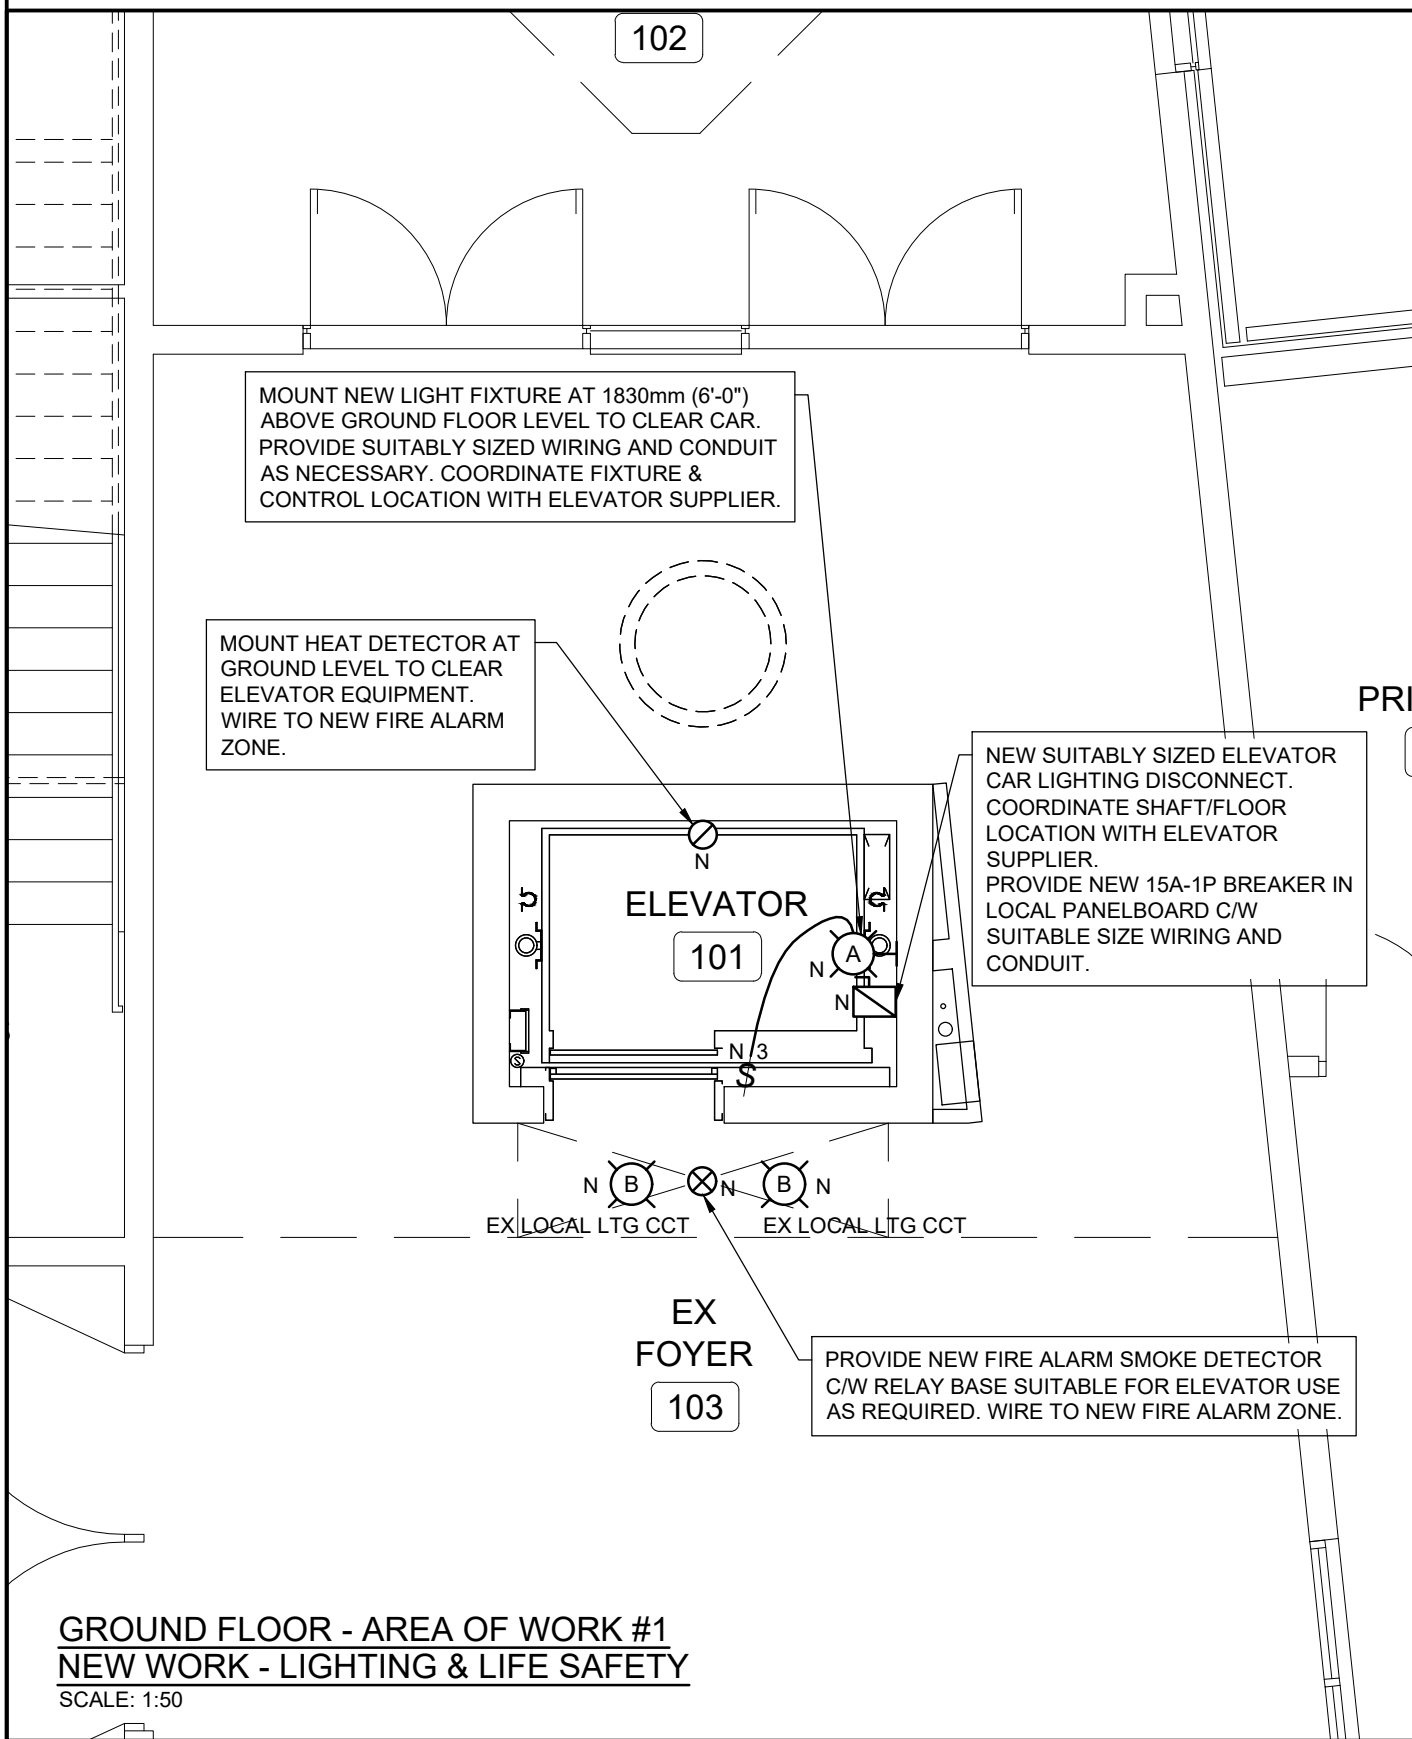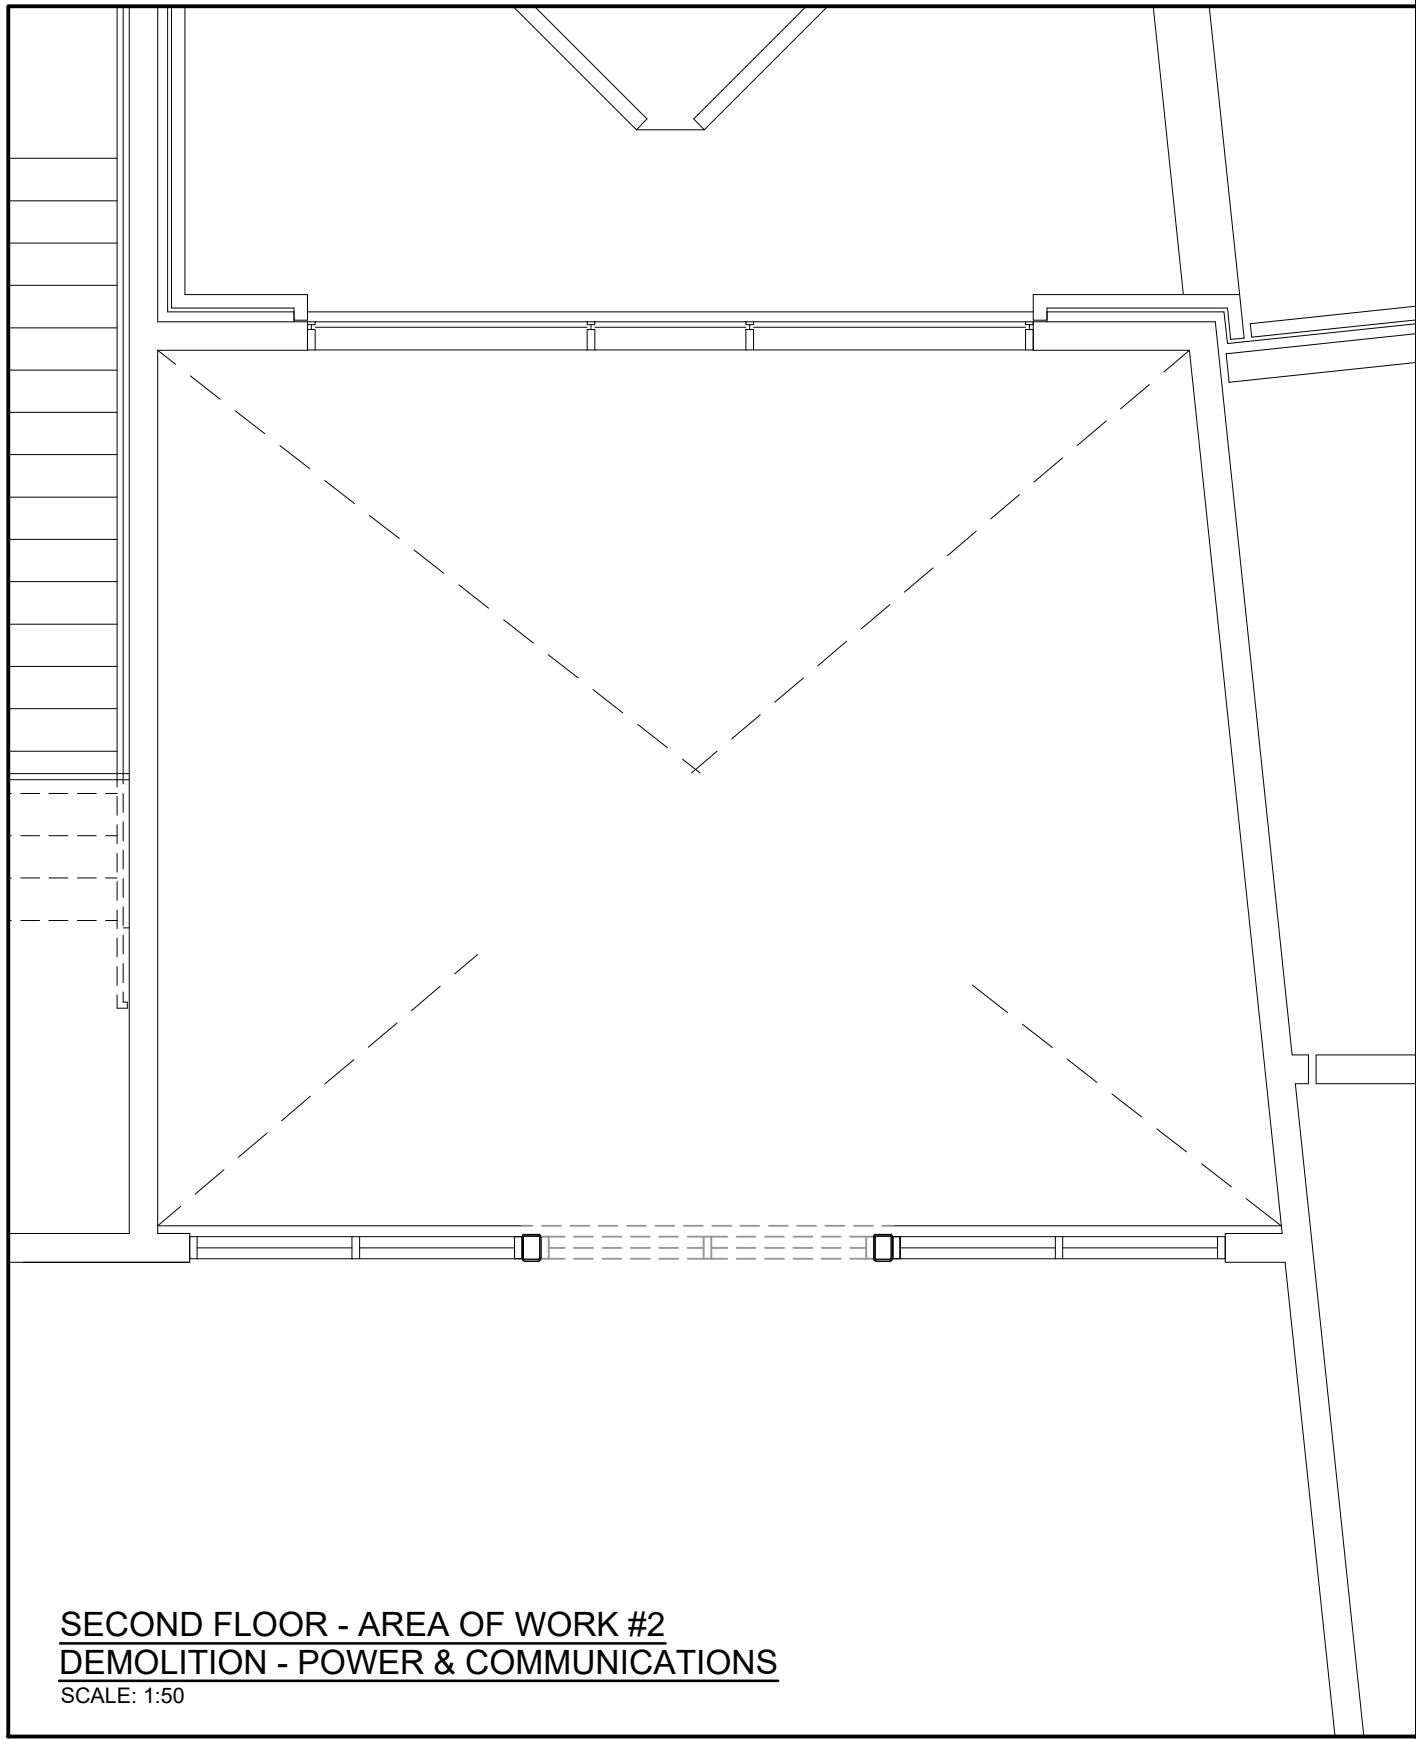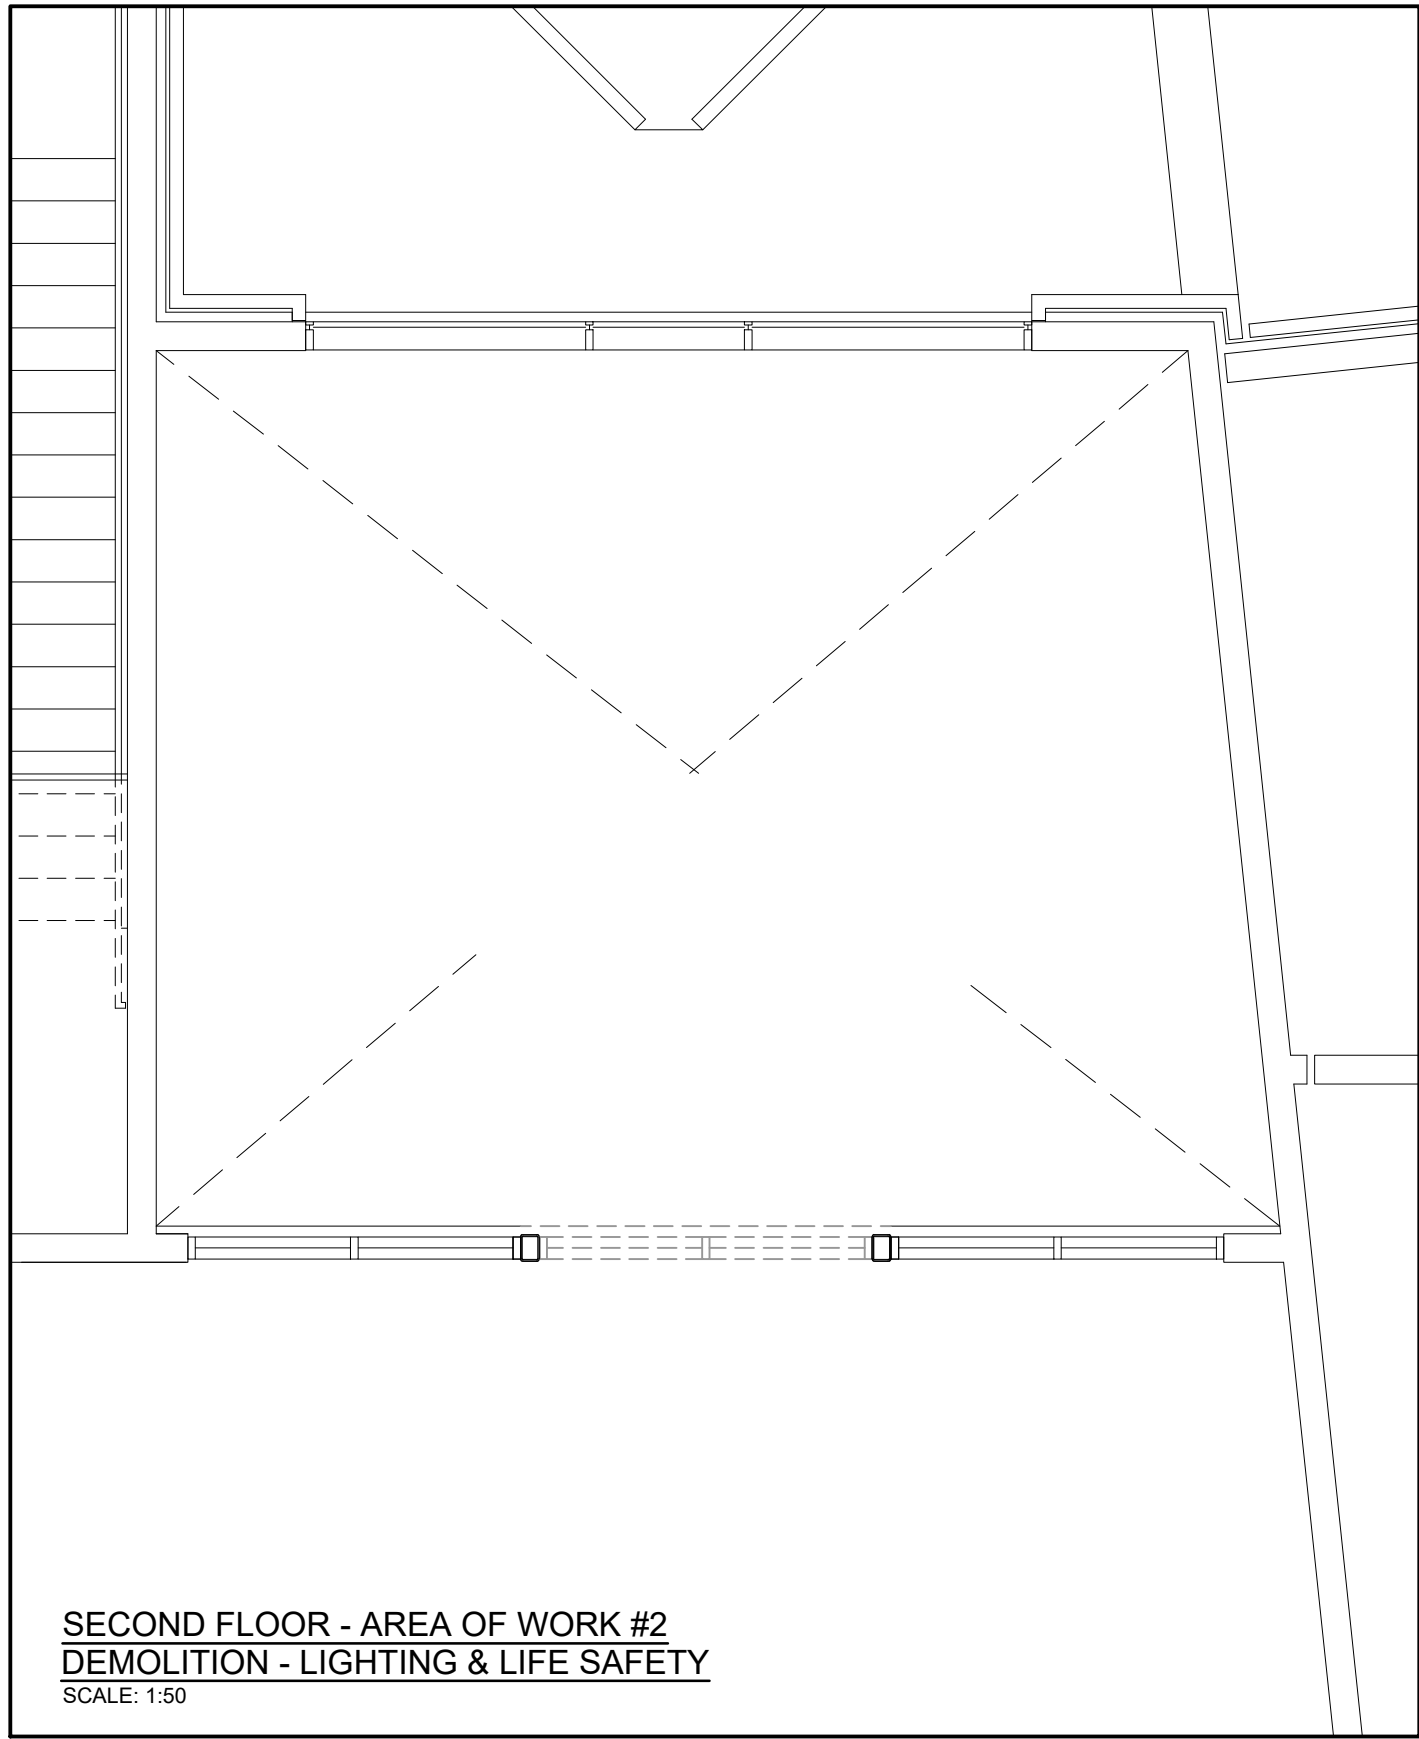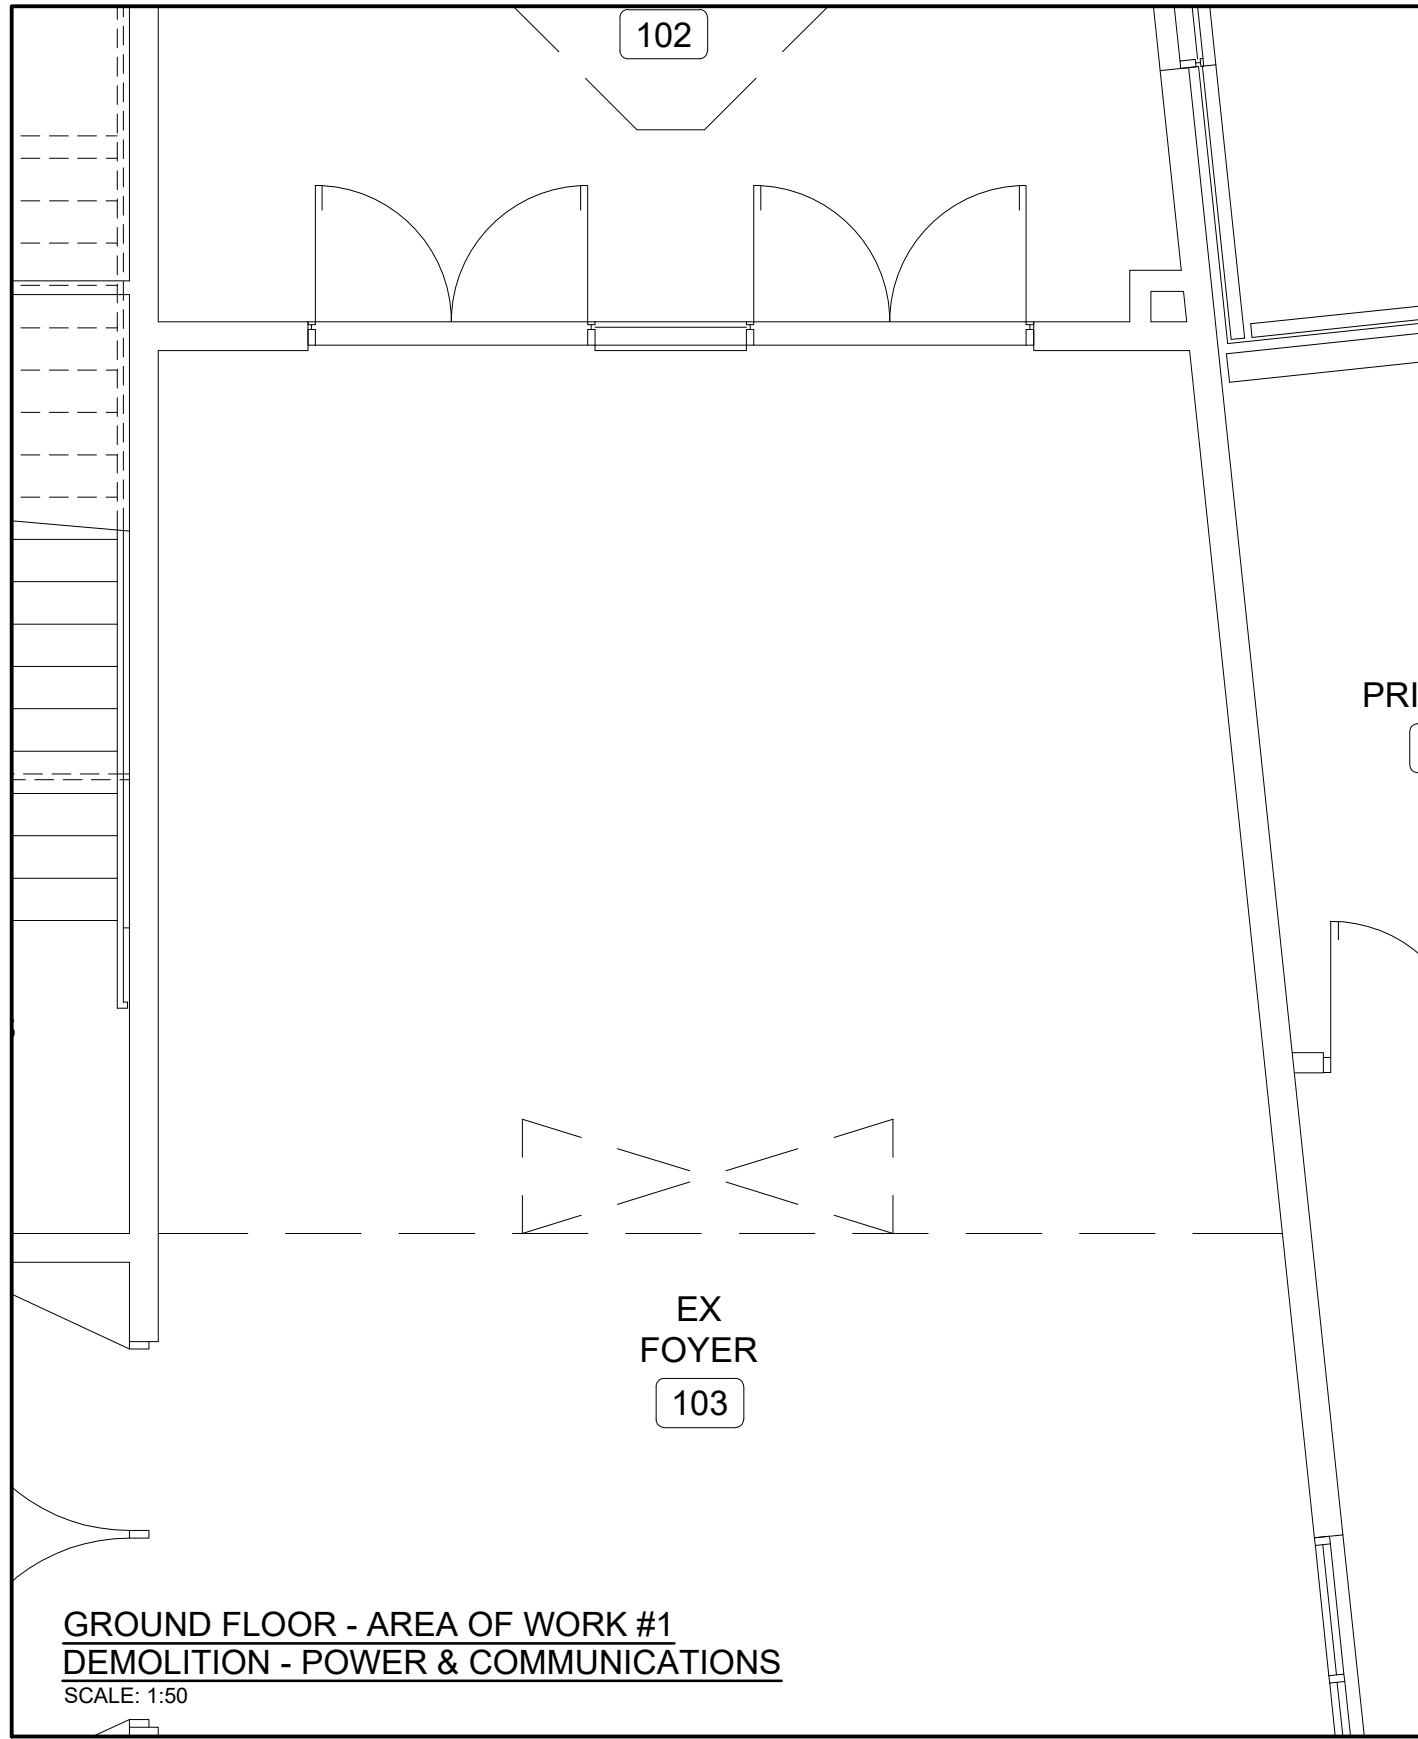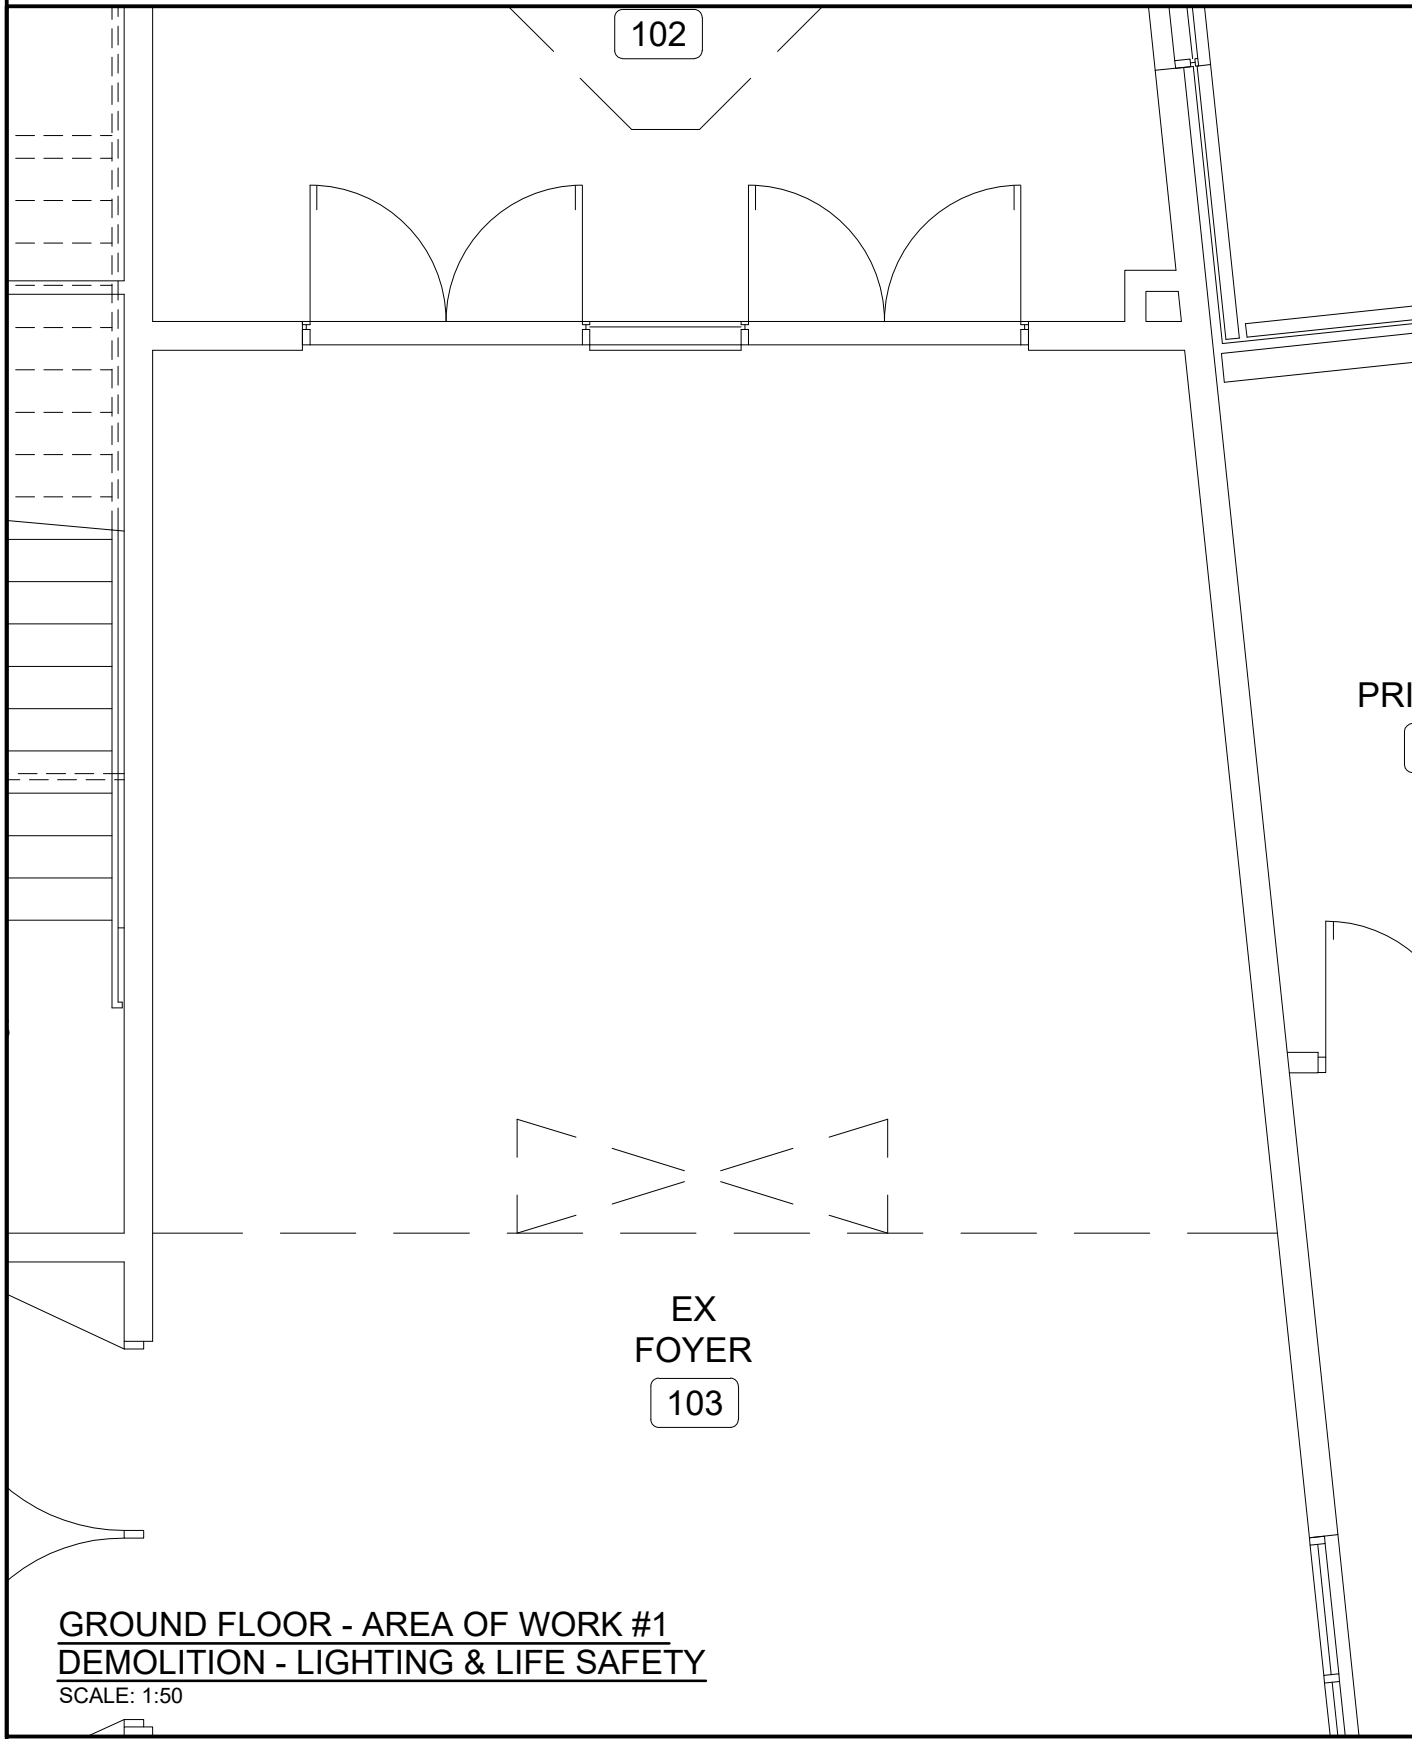

DRAWING LIST	
E0.01	KEY & FIRE PLAN - NOTES, LEGENDS & SCHEDULES
E1.01	EXISTING SCHOOL - NEW WORK
E1.02	GROUND & SECOND FLOOR AREA OF WORK #1 & #2
	DEMOLITION & NEW WORK - LIGHTING & LIFE SAFETY POWER & COMMUNICATIONS
E3.01	DETAILS
E3.02	ELECTRICAL SPECIFICATIONS - 1 OF 2
E3.03	ELECTRICAL SPECIFICATIONS - 2 OF 2

2	2026/07/02	ISSUED FOR TENDER
1	2026/06/30	ISSUED FOR PERMIT
0	2026/05/12	ISSUED
A	2026/04/21	ISSUED FOR COORDINATION
No.	YYYY/MM/DD	DESCRIPTION

REVISIONS

PROJECT NORTH

NRG DESIGN Inc.
40 Hepburn Crescent, Hamilton ON L9C 7S4
Mobile: (905) 802-7341

SEI
Electrical Engineering
12 Argyle Street N., Caledonia, ON, N3W 1B6
www.sei-ee.com

Hamilton-Wentworth Catholic District School Board
Believing. Achieving. Serving

SVEDAS / ARCHITECTS INC.

3600 BILLINGS COURT, SUITE 100
BURLINGTON, ONTARIO L7N 3N6
TEL: (905) 308-7771

ELEVATOR FOR BISHOP TONNOS CATHOLIC SECONDARY SCHOOL

100 PANABAKER DR.
ANCASTER ONTARIO

ELECTRICAL GROUND & SECOND FLOOR - AREA OF WORK #1 & #2 DEMOLITION & NEW WORK LIGHTING & LIFE SAFETY POWER & COMMUNICATIONS

SCALE	DRAWN	PROJECT No.
AS NOTED	G.J.L.	26-006
DATE	CHECKED	DRAWING No.
2026/04/07	K.S.	E1.02