

FILENAME: C:\NRS Design\NRS DESIGN JOBS\ - 2026 -\26-006 SM - 26-080 - Bishop Tonnos Elevator E0.01-E3.03 Rev2.dwg
PLOT DATE: Jul 02, 2026 4:09pm
ARCH D 24X36

- DEMOLITION NOTES:**
- EXISTING LIGHT FIXTURES TO BE REMOVED AND RETAINED FOR POSSIBLE RE-USE. REDUNDANT FIXTURES TO BE RETAINED FOR OWNER REVIEW AND POSSIBLE RETENTION. DISPOSE OF REDUNDANT FIXTURES OFF-SITE AS DIRECTED. CAP AND MAKE WIRING SAFE. RETAIN EXISTING LIGHTING CIRCUITS FOR POSSIBLE RE-USE.
 - REMOVE EXISTING RECEPTACLES AND SWITCHES AS SHOWN. CAP AND MAKE WIRING SAFE. DISCONNECT AT ASSOCIATED BREAKER AND LABEL "SPARE". RETAIN EXISTING RECEPTACLE CIRCUITS FOR RE-USE.
 - EXISTING P/A SPEAKERS TO BE REMOVED BY OWNER'S APPROVED P/A SUBCONTRACTOR. RETAIN FOR OWNER REVIEW AND POSSIBLE RETENTION. DISPOSE OF REDUNDANT UNITS OFF-SITE AS DIRECTED. DISCONNECT, CAP AND MAKE ASSOCIATED WIRING SAFE. RETAIN CIRCUITS FOR RE-USE.
 - EXISTING FIRE ALARM EQUIPMENT AND ASSOCIATED WIRING TO BE REMOVED AND RETAINED FOR RE-INSTALLATION OR OWNER REVIEW AND POSSIBLE RETENTION. DISPOSE OF REDUNDANT DEVICES OFF-SITE AS DIRECTED. RETAIN EXISTING CIRCUITS FOR RE-USE.
 - EXISTING EMERGENCY / EXIT LIGHTING UNITS TO BE REMOVED, RETAINED FOR RE-INSTALLATION OR FOR OWNER REVIEW AND POSSIBLE RETENTION. DISPOSE OF REDUNDANT UNITS OFF-SITE AS DIRECTED. DISCONNECT, CAP AND MAKE ASSOCIATED WIRING SAFE. RETAIN CIRCUITS FOR RE-USE.
 - DISCONNECT POWER FEEDS TO EXISTING MECHANICAL EQUIPMENT TO BE REMOVED/RELOCATED BY MECHANICAL CONTRACTOR. RETAIN CIRCUITS FOR RE-USE.
 - PROVIDE STAINLESS STEEL COVER PLATES AS REQUIRED FOR ALL REDUNDANT OUTLET BOXES TO REMAIN IN EXISTING WALLS.

- NEW LIGHTING & LIFE SAFETY NOTES:**
- PROVIDE NEW INTERIOR LIGHT FIXTURES AS SHOWN. WIRE TO NEW OR EXISTING LOCAL LIGHTING CIRCUITS AS NECESSARY. PROVIDE NEW STANDARD, DIMMING &/OR OCCUPANCY SENSOR LIGHT SWITCHES AS INDICATED.
 - PROVIDE NEW EMERGENCY / EXIT "RUNNING MAN" LIGHTING UNITS AS REQUIRED. WIRE TO NEW AC/DC EMERGENCY LIGHTING CIRCUITS AS INDICATED.
 - PROVIDE NEW FIRE ALARM SYSTEM DEVICES AS SHOWN. WIRE TO NEW OR EXISTING FIRE ALARM ZONES ON EXISTING FIRE ALARM SYSTEM AS INDICATED.

- NEW POWER & COMMUNICATIONS NOTES:**
- SUPPLY AND INSTALL NEW RECEPTACLES AS SHOWN. WIRE TO NEW OR EXISTING BREAKERS IN NEW LOCAL PANEL BOARDS AS INDICATED. MAXIMUM FOUR (4) RECEPTACLES PER 15A CIRCUIT.
 - PROVIDE RECESSED OUTLET BOXES FOR NEW DATA / TELEPHONE OUTLETS AS SHOWN. RETAIN OWNER'S APPROVED DATA / TELEPHONE SUBCONTRACTOR TO SUPPLY, INSTALL, TERMINATE AND TEST DATA & TELEPHONE JACKS C/W CAT6 WIRING FOR DATA AND CAT3 WIRING FOR TELEPHONE.
 - PROVIDE NEW POWER FEEDS TO NEW MECHANICAL EQUIPMENT AS REQUIRED. WIRE TO NEW SUITABLY SIZED BREAKERS IN NEW LOCAL PANEL BOARDS AS SHOWN.
 - PROVIDE NEW POWER FEEDS TO NEW EQUIPMENT AS INDICATED. EQUIPMENT SUPPLIED BY OTHERS.
 - COORDINATE ELEVATOR DISCONNECTS LOCATION IN SHAFT, ELEVATOR POWER REQUIREMENTS/FEED LOCATION WITH ELEVATOR SUPPLIER BEFORE COMMENCING WORK.

DRAWING LIST

- E0.01 KEY & FIRE PLAN - NOTES, LEGENDS & SCHEDULES
E1.01 EXISTING SCHOOL - NEW WORK
E1.02 GROUND & SECOND FLOOR AREA OF WORK #1 & #2
DEMOLITION & NEW WORK - LIGHTING & LIFE SAFETY POWER & COMMUNICATIONS
DETAILS
E3.01 ELECTRICAL SPECIFICATIONS - 1 OF 2
E3.03 ELECTRICAL SPECIFICATIONS - 2 OF 2

2	2026/07/02	ISSUED FOR TENDER
1	2026/06/30	ISSUED FOR PERMIT
0	2026/05/12	ISSUED
A	2026/04/21	ISSUED FOR COORDINATION
No.	YYYY/MM/DD	DESCRIPTION
REVISIONS		

PROJECT NORTH

NRG DESIGN Inc.
40 Hepburn Crescent, Hamilton ON L9C 7S4
Mobile: (905) 802-7341

SEI
Electrical Engineering
12 Argyle Street N., Caledonia, ON, N3W 1B6
www.sei-ee.com

Hamilton-Wentworth Catholic District School Board
Believing. Achieving. Serving

SVEDAS / ARCHITECTS INC.
3600 BILLINGS COURT, SUITE 100
BURLINGTON, ONTARIO L7N 3N6
TEL: (905) 308-7771

ELEVATOR FOR BISHOP TONNOS CATHOLIC SECONDARY SCHOOL


100 PANABAKER DR.
ANCASTER ONTARIO

ELECTRICAL

EXISTING SCHOOL - NEW WORK

SCALE	DRAWN	PROJECT No.
AS NOTED	G.J.L.	26-006
DATE	CHECKED	DRAWING No.
2026/04/07	K.S.	E1.01

GROUND FLOOR - EXISTING SCHOOL - NEW WORK
SCALE: 1:250

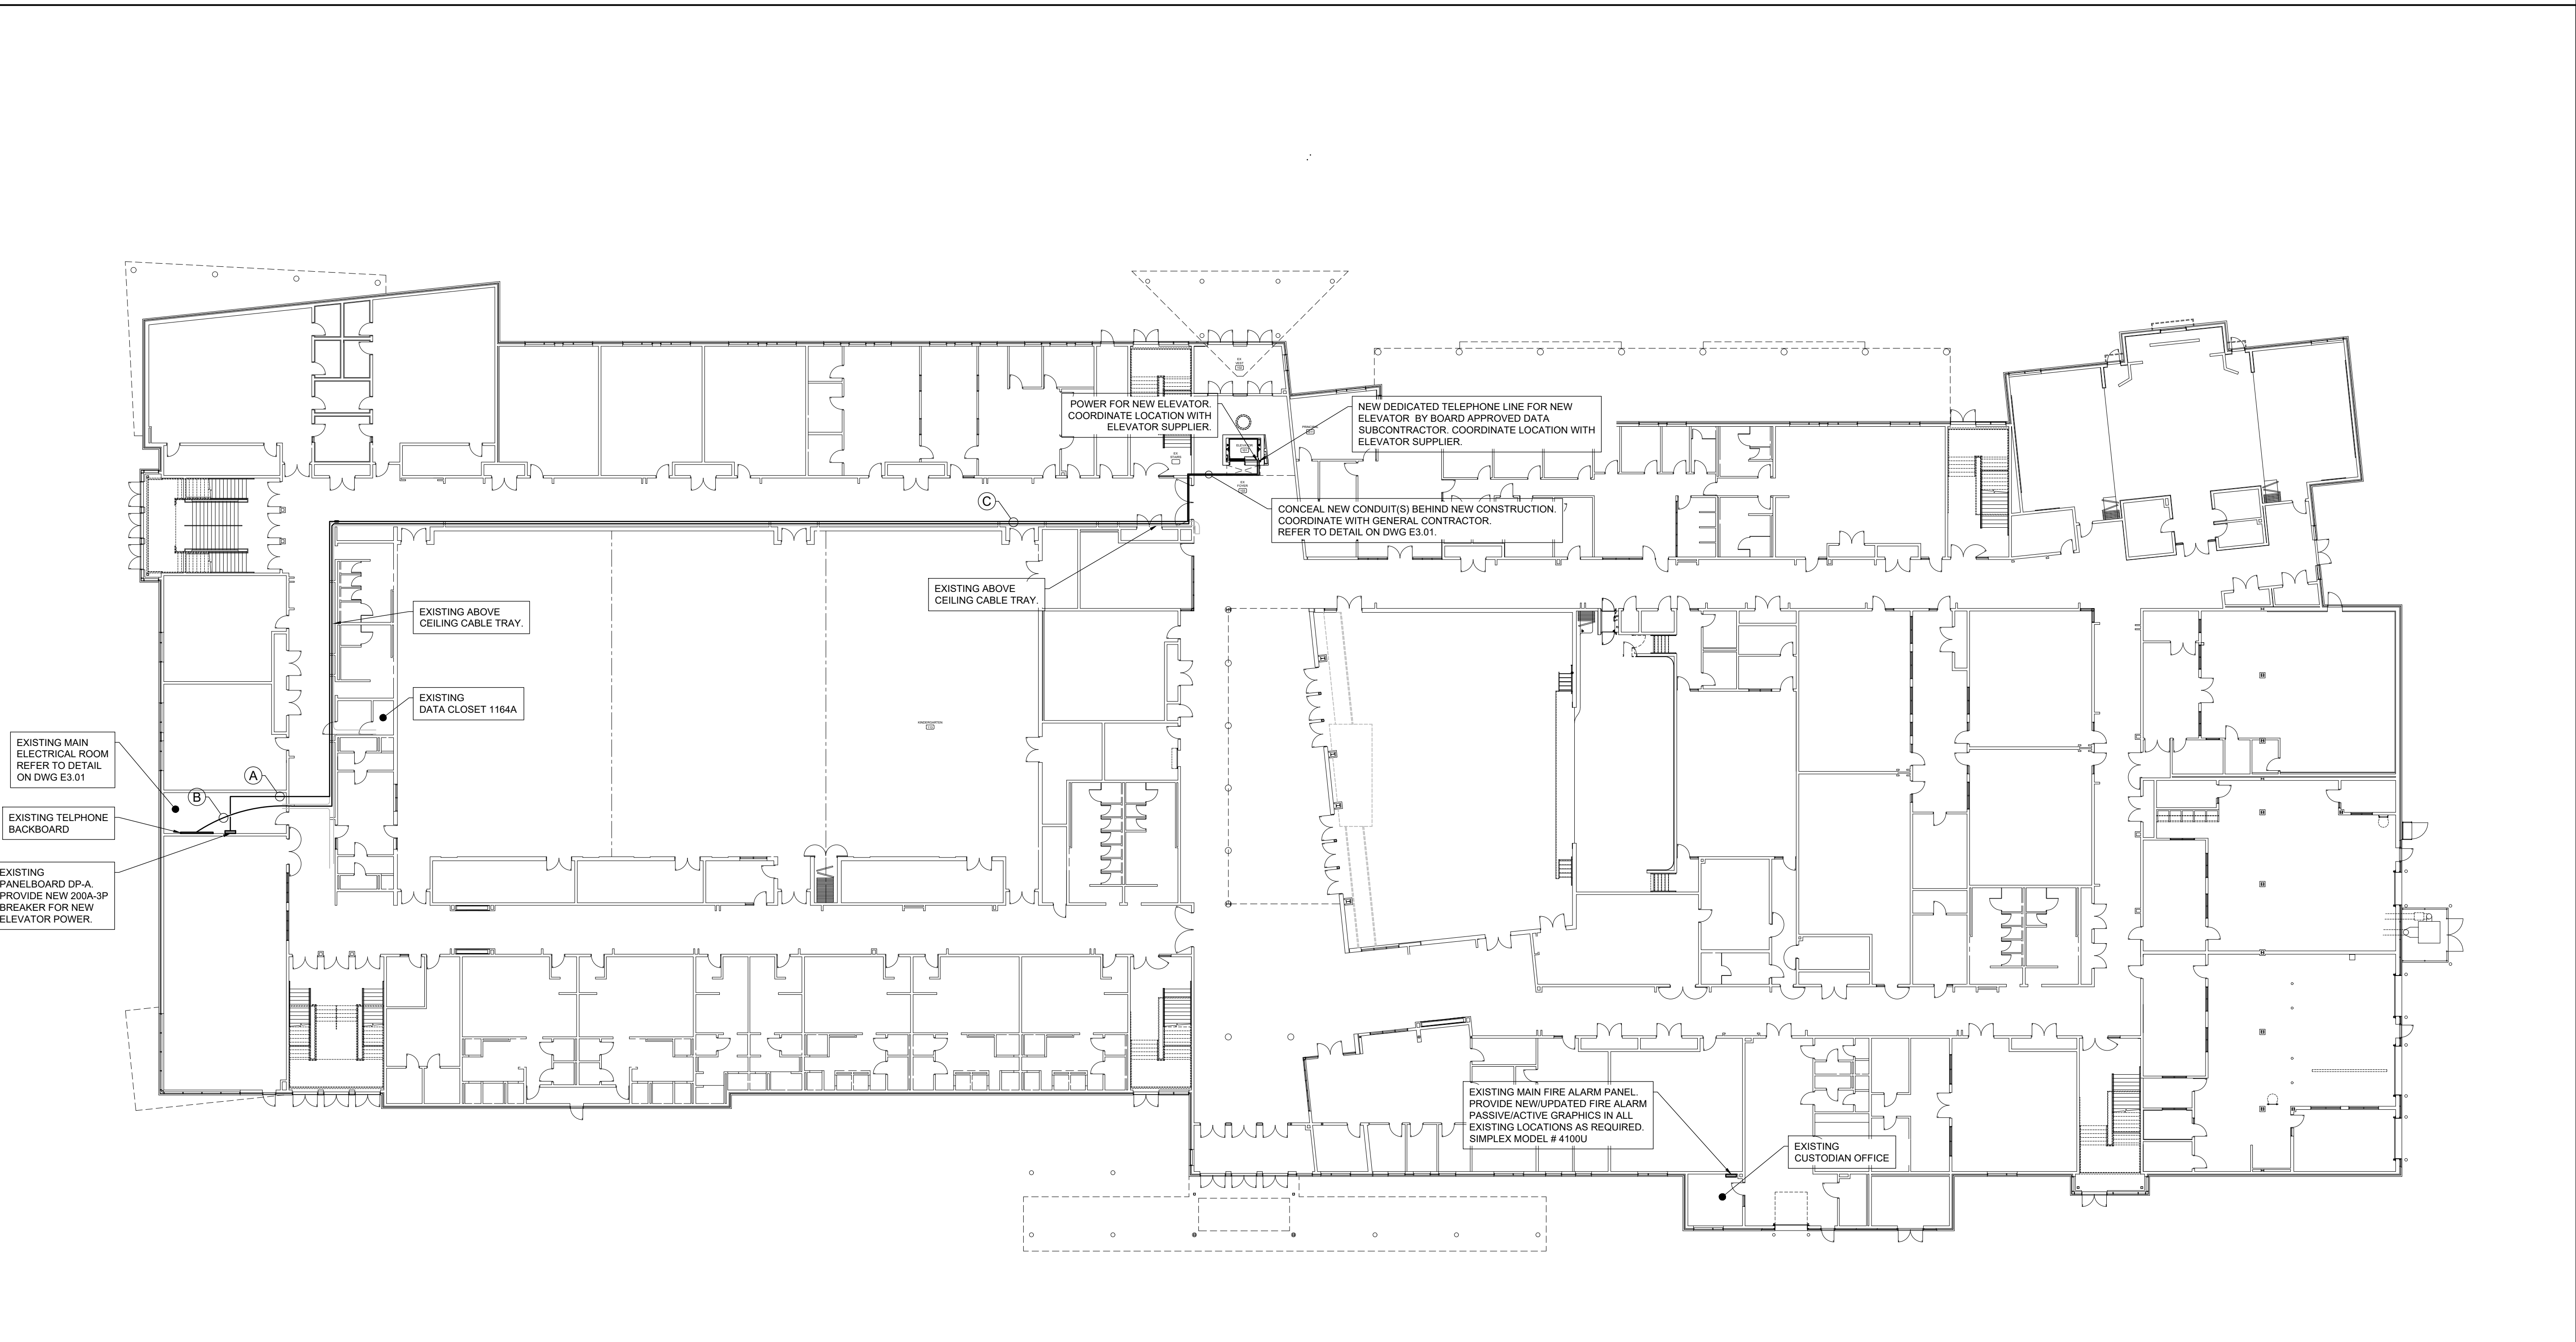

CONDUIT & WIRE SCHEDULE

- (A) NEW 4 - #3/0 AWG RW90 COPPER + GND IN 1 - 50mm (2") DIA. EMT CONDUIT FOR POWER ABOVE CORRIDOR CEILINGS. RUN INTO EXISTING MAIN ELECTRICAL ROOM.
- (B) NEW TELEPHONE LINE IN EXISTING ABOVE CORRIDOR CEILING CABLE TRAY. RUN INTO EXISTING MAIN ELECTRICAL ROOM.
- (C) NEW 4 - #3/0 AWG RW90 COPPER + GND IN 1 - 50mm (2") DIA. EMT CONDUIT FOR POWER ABOVE CORRIDOR CEILINGS AND NEW TELEPHONE LINE IN EXISTING ABOVE CORRIDOR CEILING CABLE TRAY. RUN INTO EXISTING MAIN ELECTRICAL ROOM.